


FIRE ALARM ABBREVIATION	
E	EXISTING TO REMAIN
ETR	EXISTING TO BE RELOCATED
ETBR	EXISTING TO BE REMOVED
N	NEW
R	RELOCATE
REC	ELEVATOR RECALL
PIV	PISTON INDICATOR VALVE
DDCV	DOUBLE DETECTOR CHECK VALVE

FIRE ALARM SYMBOLS	
[FACP]	FIRE ALARM CONTROL PANEL
[FAAP]	FIRE ALARM ANNUCIATOR PANEL
[PS1]	FIRE ALARM POWER SUPPLY 1
[PS2]	FIRE ALARM POWER SUPPLY 2
[F]	ADDRESSABLE MANUAL PULL STATION
[SD]	ADDRESSABLE PHOTOELECTRIC SMOKE DETECTOR
[D]	ADDRESSABLE DUCT DETECTOR
[R]	REMOTE ALARM/TEST SWITCH
[HD]	ADDRESSABLE HEAT DETECTOR
[TS]	TAMPER SWITCH
[FS]	FLOW SWITCH
[LH]	HORN/STROBE DEVICE
[L]	STROBE LIGHT
[R]	RELAY
[M]	MONITOR MODULE

RECEIVED
 MAR 06 2018
 BUILDING DEPARTMENT
 BCPS

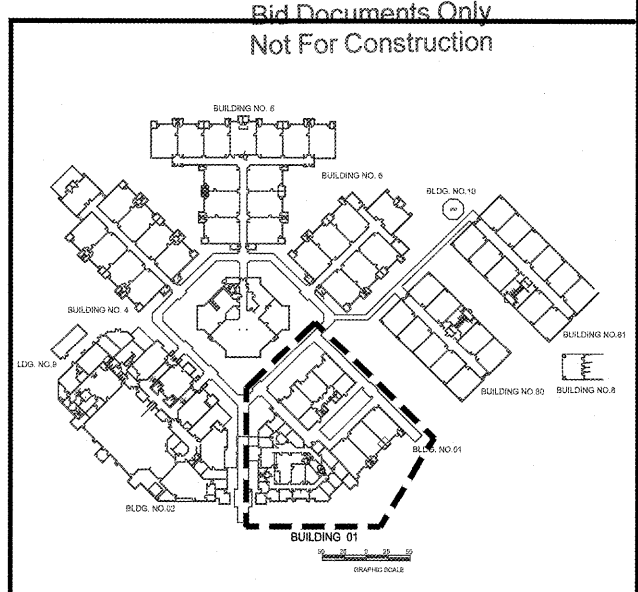

2 PARTIAL DEMOLITION FIRE ALARM FLOOR PLAN BUILDING 01
 SCALE: 1/8" = 1'-0"

1 KEY PLAN
 SCALE: 1" = 100'-0"

REVISIONS	BUILDING DEPARTMENT COMMENTS
1	02/23/18

SEA CASTLE
 ELEMENTARY SCHOOL
 9600 MIRAMAR BOULEVARD
 MIRAMAR, FLORIDA 33025



THE SCHOOL BOARD OF BROWARD COUNTY

PARTIAL DEMOLITION
 FIRE ALARM FLOOR PLAN
 BUILDING 01

JOB PHASE: 100% SUBMITTAL
 SBBC PROJECT: P.001632
 DATE: 12.13.16
 SCALE: AS SHOWN
 DRAWN BY: HA
 CHECKED BY: E.H.
 CAE PROJECT NO. 2015.55

FL LICEN# 171739048
 ERIC J. HAMMOND
 PROFESSIONAL ENGINEER
 MECHANICAL/ELECTRICAL
 STATE OF FLORIDA
 LICENSE# 39048
 MA 30048
 ERIC J. HAMMOND
 PROFESSIONAL ENGINEER
 MECHANICAL/ELECTRICAL
 STATE OF FLORIDA
 LICENSE# 39048
 MA 30048

DRAWING No.

DE-301

THIS IS A VIOLATION OF THE LAW FOR ANY PERSON, UNLESS ACTING UNDER THE DIRECTION OF A LICENSED ARCHITECT, TO ALTER THESE PLANS AND SPECIFICATIONS. THIS DOCUMENT CONTAINS PROPERTY INFORMATION AND SHALL NOT BE USED OR REPRODUCED, IN WHOLE OR IN PART, WITHOUT THE PRIOR WRITTEN CONSENT OF CRAIN ATLANTIS ENGINEERING, INC. COPYRIGHT 2014 CRAIN ATLANTIS ENGINEERING, INC.