

NO.	REVISIONS

SEA CASTLE
 ELEMENTARY SCHOOL
 9600 MIRAMAR BOULEVARD
 MIRAMAR, FLORIDA 33025
 THE SCHOOL BOARD OF BROWARD COUNTY

PARTIAL DEMOLITION
 FIRE ALARM FLOOR PLAN
 BUILDING 03


JOB PHASE: 100% SUBMITTAL
 SBEC PROJECT: P 001632
 DATE: 12.13.16
 SCALE: AS SHOWN
 DRAWN BY: HA
 CHECKED BY: E.H.
 CAE PROJECT NO. 2015.55
 FL LICENSE PE# 39048

ERIC HAMMOND
 PROFESSIONAL ENGINEER
 SEAL
 DRAWING No.

DE-303


FIRE ALARM ABBREVIATIONS	
E	EXISTING TO REMAIN
ETR	EXISTING TO BE RELOCATED
ETBR	EXISTING TO BE REMOVED
N	NEW
R	RELOCATED
RC	ELEVATOR RECALL
PIV	POST INDICATOR VALVE
DDCV	DOUBLE DETECTOR CHECK VALVE

FIRE ALARM SYMBOLS	
	FIRE ALARM CONTROL PANEL
	FIRE ALARM ANNUNCIATOR PANEL
	FIRE ALARM POWER SUPPLY 1
	FIRE ALARM POWER SUPPLY 2
	ADDRESSABLE MANUAL PULL STATION
	ADDRESSABLE PHOTOELECTRIC SMOKE DETECTOR
	ADDRESSABLE DUCT DETECTOR
	REMOTE ALARM/TEST SWITCH
	ADDRESSABLE HEAT DETECTOR
	TAMPER SWITCH
	FLOW SWITCH
	HORN/STROBE DEVICE
	STROBE LIGHT
	RELAY
	MONITOR MODULE

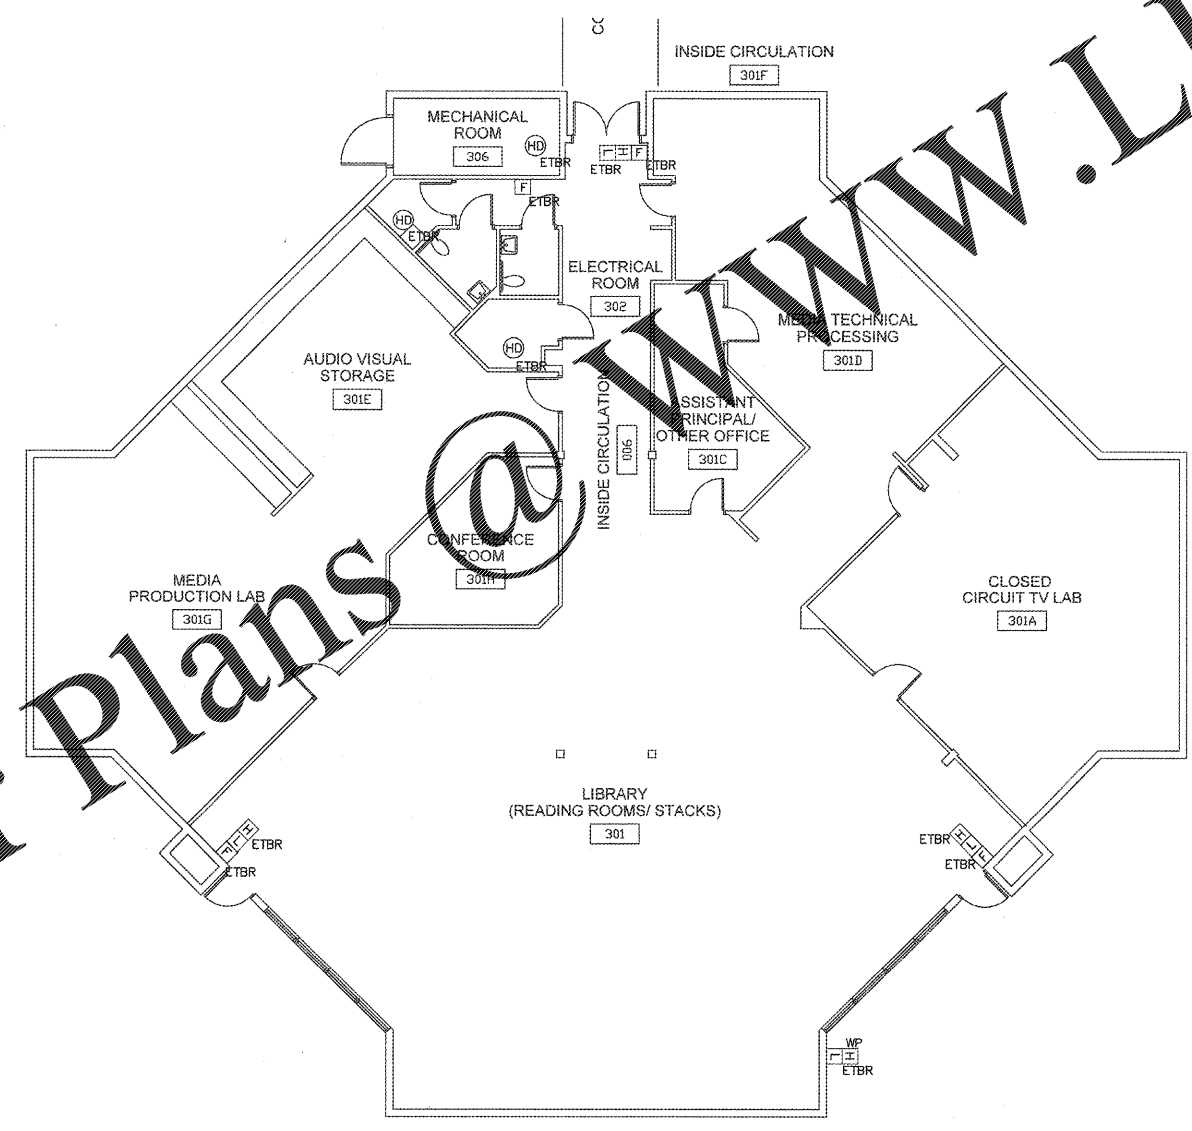

RECEIVED
 DEC 19 2017
 BUILDING DEPARTMENT
 BCPS

Bid Documents Only
 Not For Construction

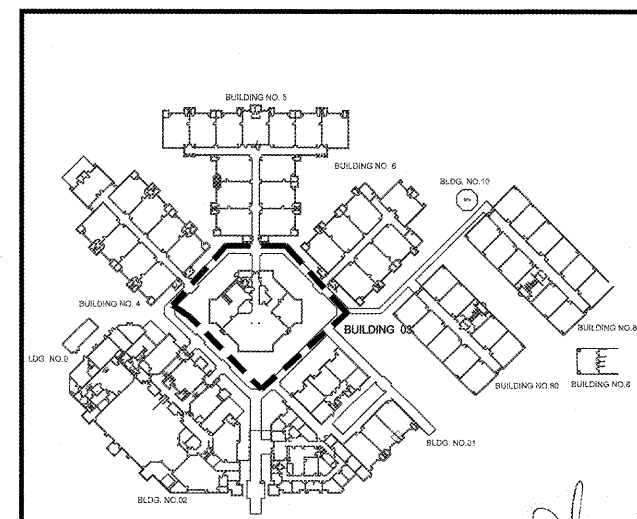

THIS IS A VIOLATION OF THE LAW FOR ANY PERSON, UNLESS ACTING UNDER THE DIRECTION OF A LICENSED ARCHITECT, TO ALTER THESE PLANS AND SPECIFICATIONS. THIS DOCUMENT CONTAINS PROPERTY INFORMATION AND SHALL NOT BE USED OR REPRODUCED, OR ITS CONTENTS DISCLOSED, IN WHOLE OR IN PART, WITHOUT THE WRITTEN CONSENT OF CRAIN ATLANTIS ENGINEERING, INC. COPYRIGHT 2014 CRAIN ATLANTIS ENGINEERING, INC.