
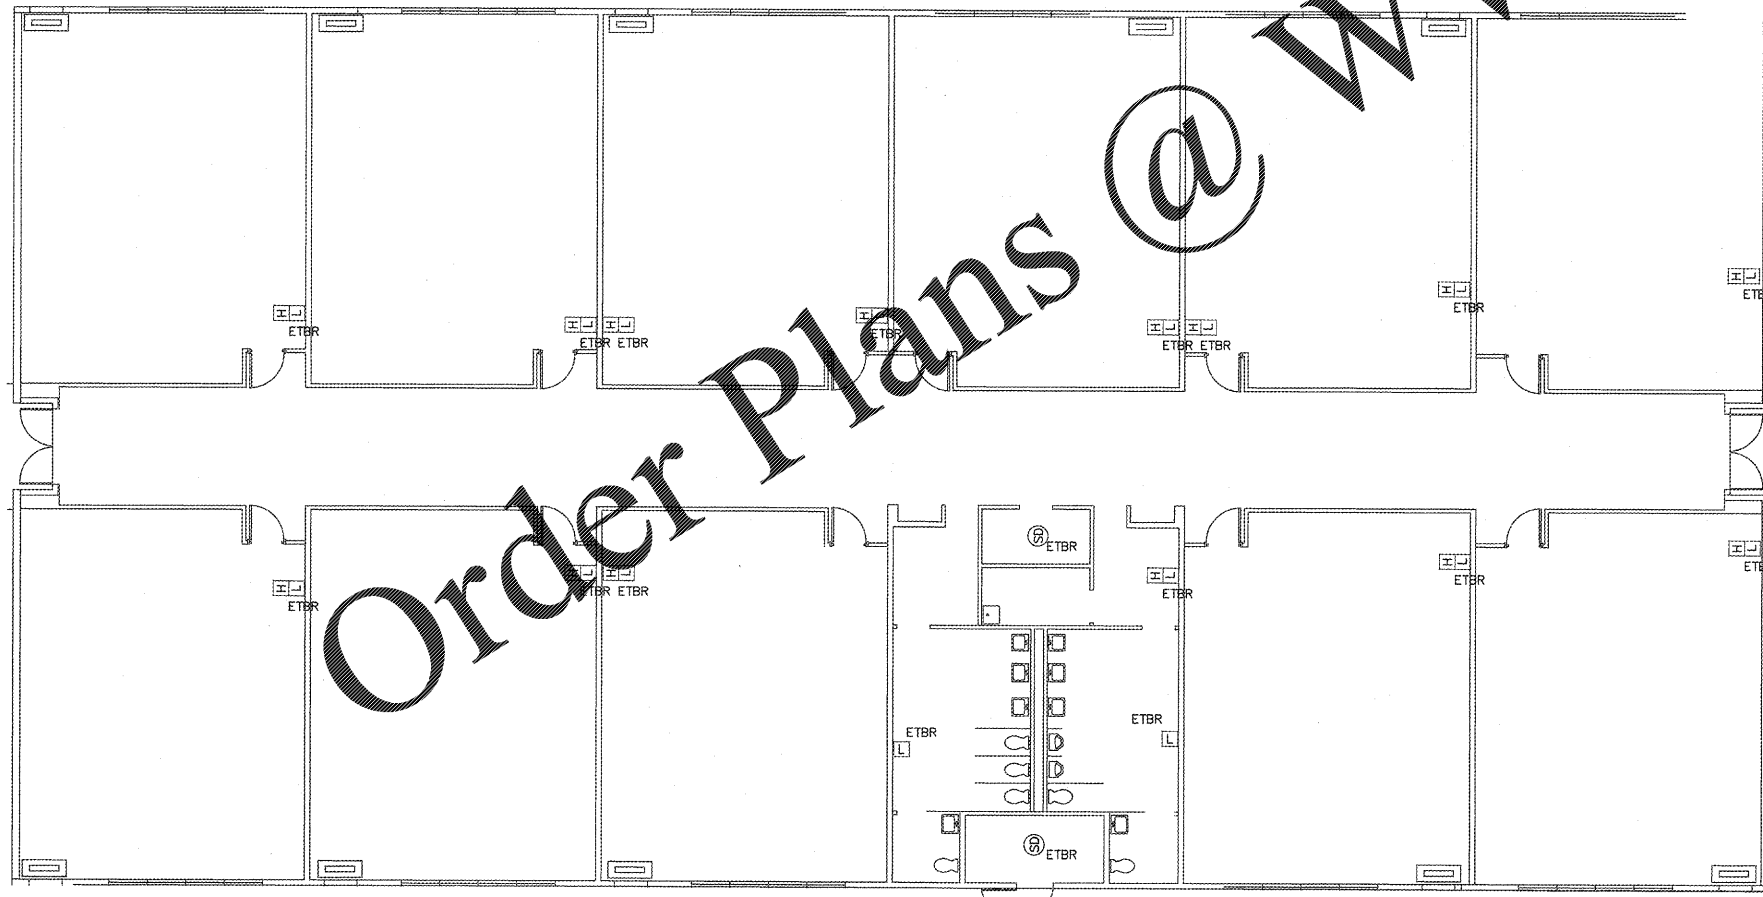


FIRE ALARM ABBREVIATIONS

E	EXISTING TO REMAIN
ETR	EXISTING TO BE RELOCATED
ETBR	EXISTING TO BE REMOVED
N	NEW
R	RELOCATED
RC	ELEVATOR RECALL
PIV	POST INDICATOR VALVE
DDCV	DOUBLE DETECTOR CHECK VALVE


FIRE ALARM SYMBOLS

FACP	FIRE ALARM CONTROL PANEL
FAAP	FIRE ALARM ANNUNCIATOR PANEL
PS1	FIRE ALARM POWER SUPPLY 1
PS2	FIRE ALARM POWER SUPPLY 2
F	ADDRESSABLE MANUAL PULL STATION
SD	ADDRESSABLE PHOTOELECTRIC SMOKE DETECTOR
D	ADDRESSABLE DUCT DETECTOR
R	REMOTE ALARM/TEST SWITCH
HD	ADDRESSABLE HEAT DETECTOR
TS	TAMPER SWITCH
FS	FLOW SWITCH
LH	HORN/STROBE DEVICE
L	STROBE LIGHT
R	RELAY
M	MONITOR MODULE

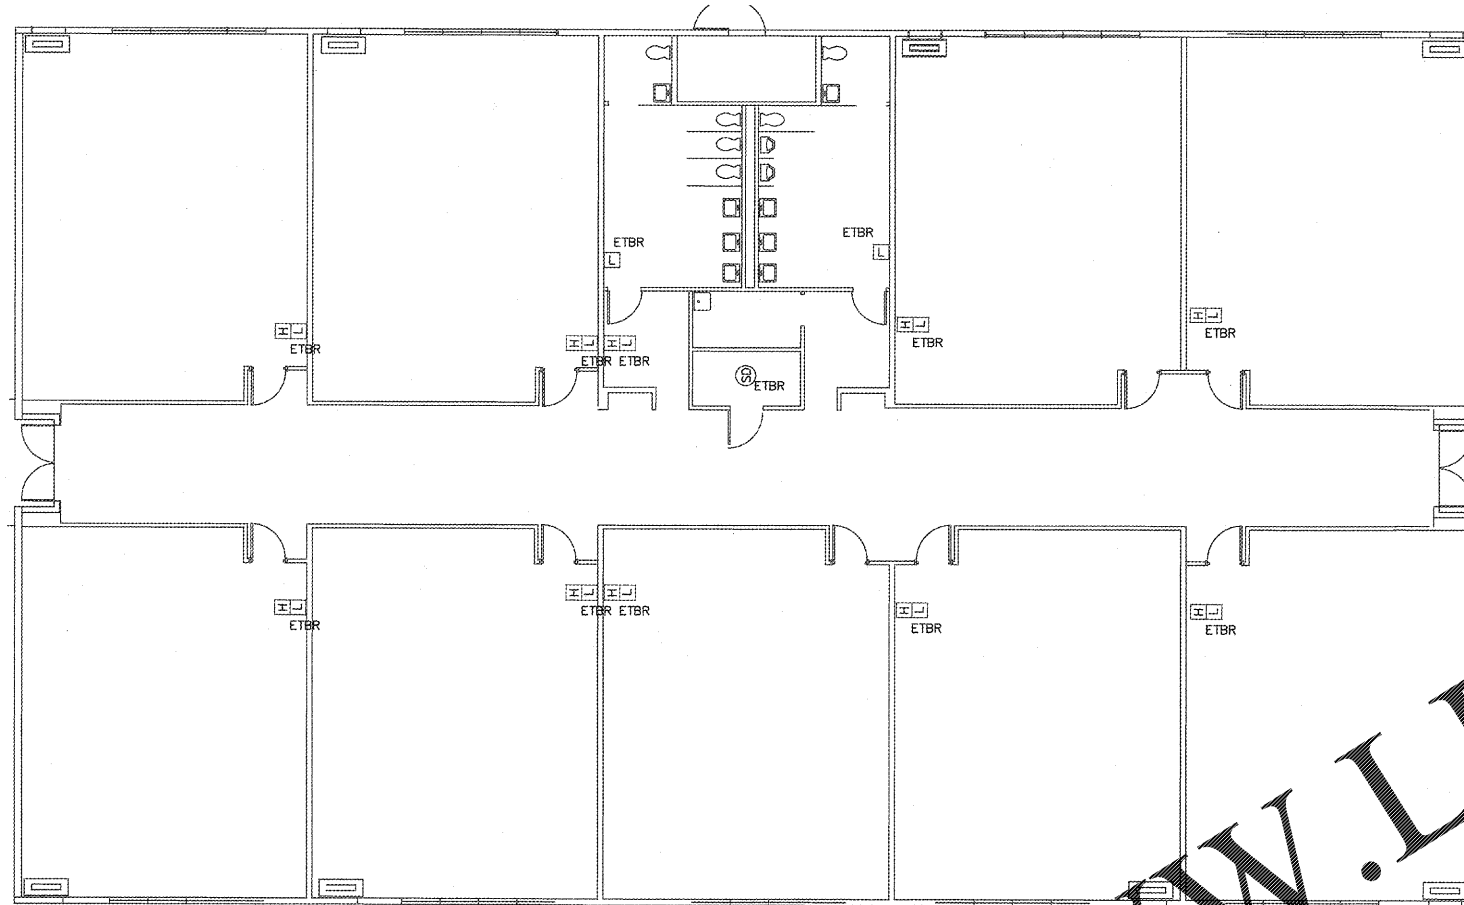

HAMMOND & ASSOCIATES, INC.
 CONSULTING ENGINEERS
 734B NW 5TH STREET
 PLANTATION, FLORIDA 33317
 TEL: (954) 327-7111 FAX (954) 327-7154
 ERIC J. HAMMOND P.E.
 MECHANICAL / ELECTRICAL ENGINEER
 P.E. #39048
 EB 5315


CRAIN ATLANTIS
 ENGINEERING, INC.
 CONSULTING ENGINEERS & ARCHITECTS
 13500 WINDY RIDGE
 DEERFIELD BEACH, FLORIDA 33441
 (407) 875-5011
 M 20001858 EB - 27498

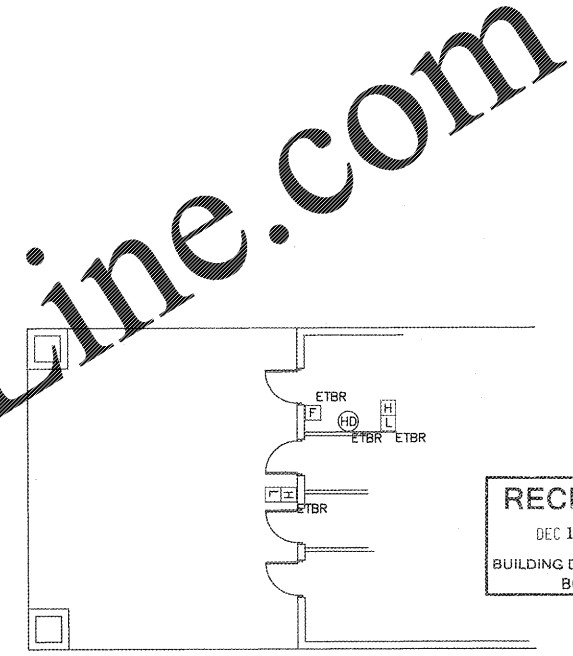

RECEIVED
 DEC 19 2017
 BUILDING DEPARTMENT
 BCPS

Order Plans @ WWW.LDILine.com

Bid Documents Only
 Not For Construction

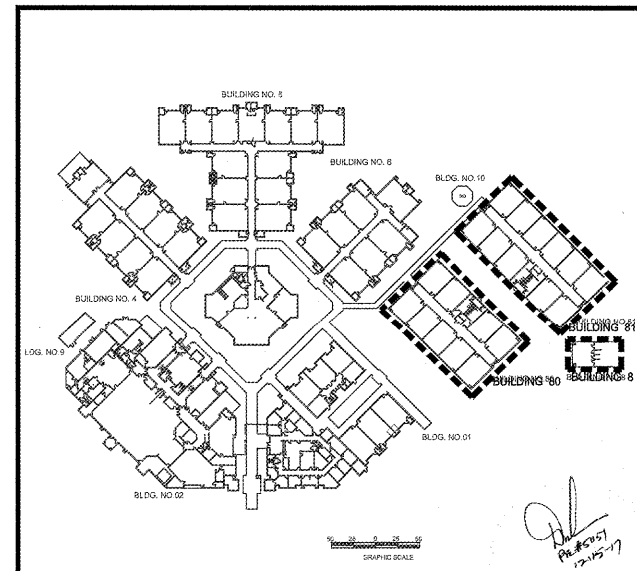

SEA CASTLE
 ELEMENTARY SCHOOL
 9600 MIRAMAR BOULEVARD
 MIRAMAR, FLORIDA 33025

THE SCHOOL BOARD OF BROWARD COUNTY

PARTIAL DEMOLITION
 FIRE ALARM FLOOR PLAN
 BUILDING 8, 80, 81

JOB PHASE: 100% SUBMITTAL
 SBBC PROJECT: P.001632
 DATE: 12.13.16
 SCALE: AS SHOWN
 DRAWN BY: HA
 CHECKED BY: E.H.
 CAE PROJECT NO. 201555

FL. LICENSE PE# 39048

ERIC HAMMOND
 PROFESSIONAL ENGINEER
 SEAL

DRAWING No.

DE-307

2 PARTIAL DEMOLITION FIRE ALARM FLOOR PLAN BUILDING 8, 80, 81
 SCALE: 1/8" = 1'-0"

1 KEY PLAN
 SCALE: 1" = 100'-0"

THIS IS A VIOLATION OF THE LAW FOR ANY PERSON, UNLESS ACTING UNDER THE DIRECTION OF A LICENSED ARCHITECT, TO ALTER THESE PLANS AND SPECIFICATIONS. THIS DOCUMENT CONTAINS PROPERTY INFORMATION AND SHALL NOT BE USED OR REPRODUCED, IN WHOLE OR IN PART, WITHOUT THE WRITTEN CONSENT OF CRAIN ATLANTIS ENGINEERING, INC. COPYRIGHT 2017 CRAIN ATLANTIS ENGINEERING, INC.