


LEGEND:
 ● POINT OF NEW CONNECTION

DRAWING KEY NOTES:
 ① LOCATION OF NEW AIR HANDLING UNIT. PROVIDE NEW CONDENSATE PIPING AS INDICATED AND CONNECT TO EXISTING LINE.
 ② LOCATION OF NEW FAN COIL UNIT (REFER TO MECHANICAL PLANS FOR EXACT LOCATION OF FAN COIL UNITS). PROVIDE NEW CONDENSATE PIPING AS INDICATED AND CONNECT TO EXISTING LINE.
 ③ EXISTING 2" CONDENSATE LINE BELOW GRADE.
 ④ EXISTING SOAKAGE PIT.

RECEIVED
 DEC 19 2017
 BUILDING DEPARTMENT
 BCPS

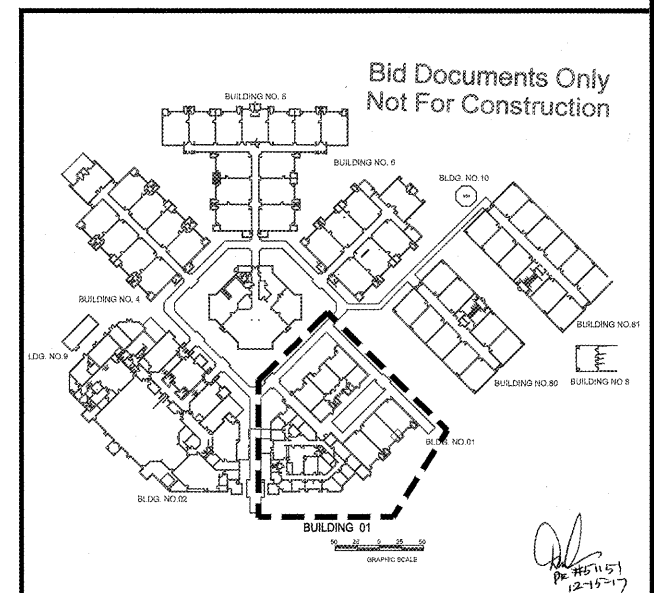

2. PARTIAL PLUMBING FLOOR PLAN BUILDING 01
 SCALE: 1/8" = 1'-0"

1. KEY PLAN
 SCALE: 1" = 100'-0"

REVISIONS

SEA CASTLE
 ELEMENTARY SCHOOL
 9600 MIRAMAR BOULEVARD
 MIRAMAR, FLORIDA 33025



THE SCHOOL BOARD OF BROWARD COUNTY

PARTIAL PLUMBING
 FLOOR PLAN BUILDING 01

JOB PHASE: 100% SUBMITTAL
 888C PROJECT: P-001632
 DATE: 12.13.16
 SCALE: AS SHOWN
 DRAWN BY: HA
 CHECKED BY: E.H.
 CAE PROJECT NO. 201555

FL. LICENSE PE# 39048

ERIC HAMMOND
 PROFESSIONAL ENGINEER
 SEAL

DRAWING No.

P-101

THIS IS A VIOLATION OF THE LAW FOR ANY PERSON, UNLESS ACTING UNDER THE DIRECTION OF A LICENSED ARCHITECT, TO ALTER THESE PLANS AND SPECIFICATIONS. THIS DOCUMENT CONTAINS PROPERTY INFORMATION AND SHALL NOT BE USED OR REPRODUCED, IN WHOLE OR IN PART, WITHOUT THE PRIOR WRITTEN CONSENT OF CRAIN ATLANTIS ENGINEERING, INC.