

HAMMOND & ASSOCIATES, INC.
 CONSULTING ENGINEERS
 7348 NW 5TH STREET
 PLANTATION, FLORIDA 33317
 TEL: (954) 327-7111 FAX: (954) 327-7154
 ERIC J. HAMMOND P.E.
 MECHANICAL / ELECTRICAL ENGINEER
 P.E. #39048
 EB 5375

CRAIN ATLANTIS
 ENGINEERING, INC.
 CONSULTING ENGINEERS & ARCHITECTS
 210 S. WASHINGTON AVE. #141
 DEERFIELD BEACH, FL 33441
 A 28001688 EB - 2748

RECEIVED
 DEC 19 2017
 BUILDING DEPARTMENT
 BCPS

REVISIONS

SEA CASTLE
 ELEMENTARY SCHOOL
 9600 MIKAMAR BOULEVARD
 MIRAMAR, FLORIDA 33025



THE SCHOOL BOARD OF BROWARD COUNTY

PARTIAL PLUMBING
 FLOOR PLAN BUILDING 02


100% SUBMITTAL
 JOB PHASE: P-001632
 SBPC PROJECT: AS SHOW
 DATE: 12.13.16
 SCALE: HA
 DRAWN BY: HA
 CHECKED BY: E.H.
 CAE PROJECT NO. 201555
 FL. LICENSE PE# 39048

ERIC HAMMOND
 PROFESSIONAL ENGINEER
 SEAL

DRAWING No.

P-102

IT IS A VIOLATION OF THE LAW FOR ANY PERSON UNLESS ACTING UNDER THE DIRECTION OF A LICENSED ARCHITECT, TO ALTER THESE PLANS AND SPECIFICATIONS. THIS DOCUMENT CONTAINS PROPERTY INFORMATION AND SHALL NOT BE USED OR REPRODUCED, IN WHOLE OR IN PART, WITHOUT THE PRIOR WRITTEN CONSENT OF CRAIN ATLANTIS ENGINEERING, INC. COPYRIGHT 2017 CRAIN ATLANTIS ENGINEERING, INC.

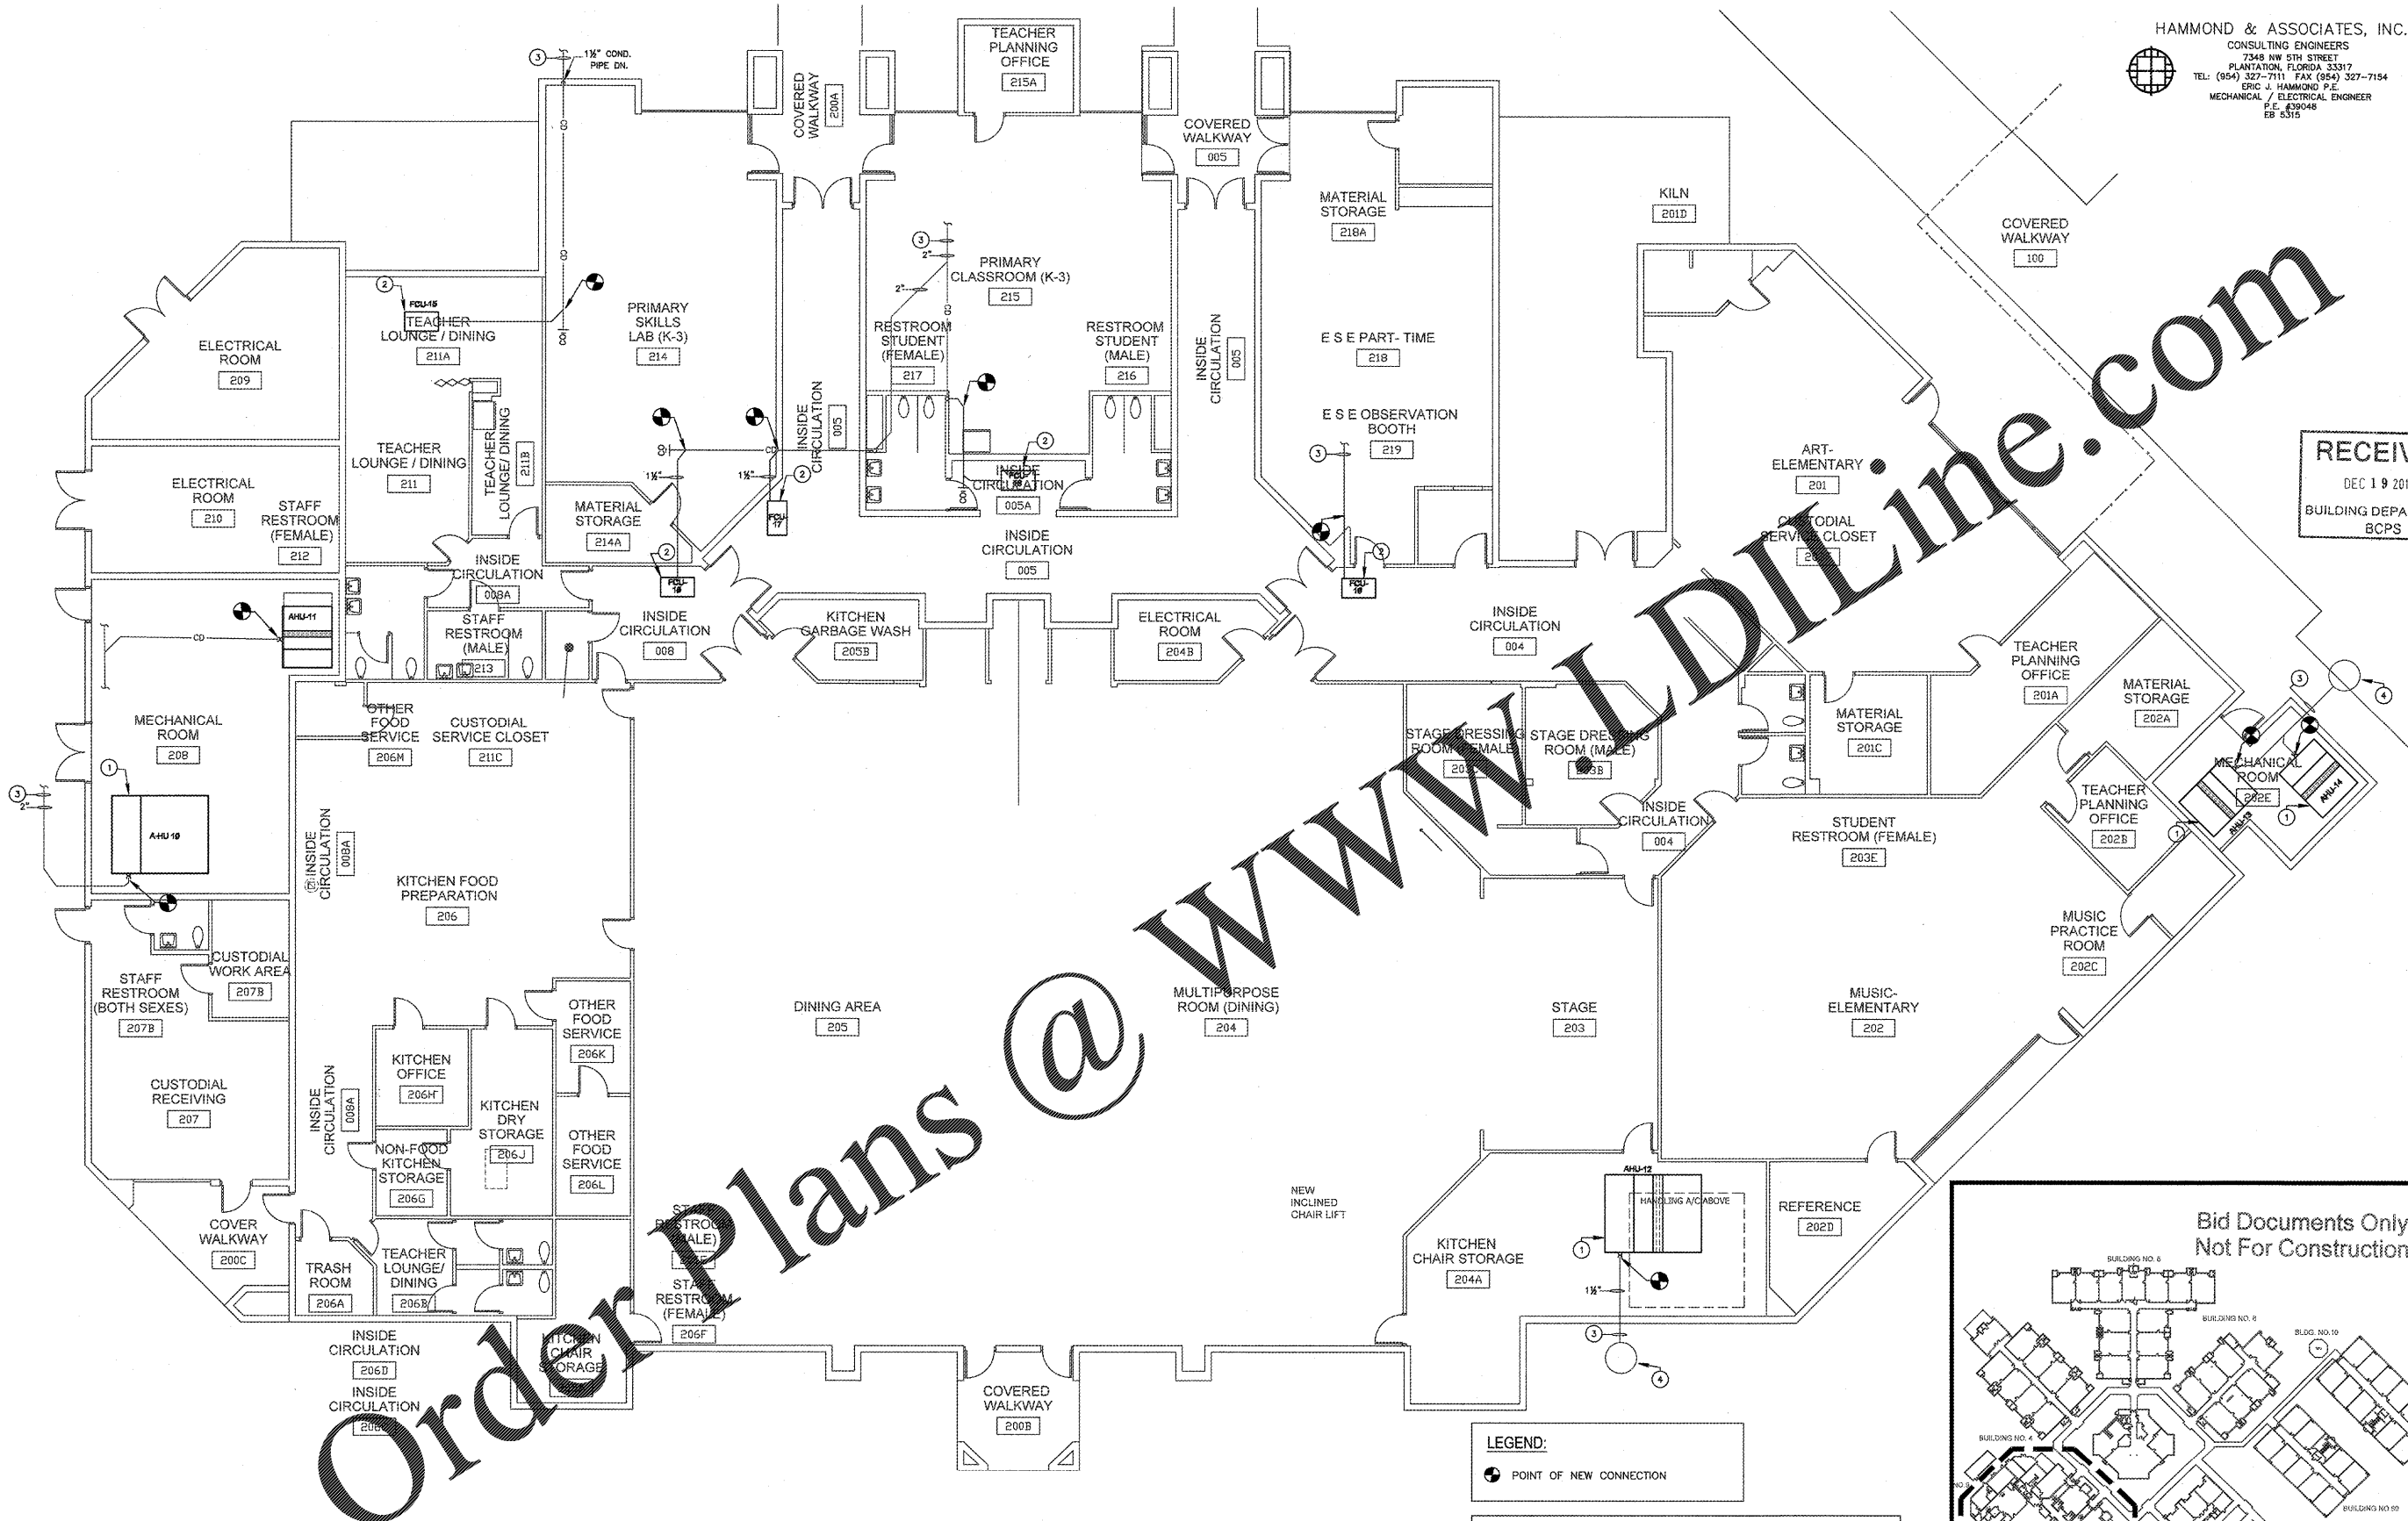


Order Plans @ WWW.LDILine.com

WWW.LDILine.com

LEGEND:
 ● POINT OF NEW CONNECTION

DRAWING KEY NOTES:
 ① LOCATION OF NEW AIR HANDLING UNIT. PROVIDE NEW CONDENSATE PIPING AS INDICATED AND CONNECT TO EXISTING LINE.
 ② LOCATION OF NEW FAN COIL UNIT (REFER TO MECHANICAL PLANS FOR EXACT LOCATION OF FAN COIL UNITS). PROVIDE NEW CONDENSATE PIPING AS INDICATED AND CONNECT TO EXISTING LINE.
 ③ EXISTING 2" CONDENSATE LINE BELOW GRADE.
 ④ EXISTING SOAKAGE PIT.

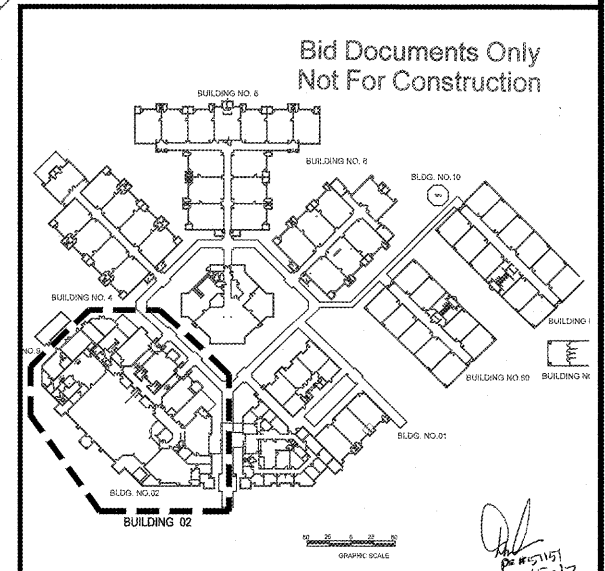

2 PARTIAL PLUMBING FLOOR PLAN BUILDING 02
 SCALE: 1/16" = 1'-0"

1 KEY PLAN
 SCALE: 1" = 100'-0"