

HAMMOND & ASSOCIATES, INC.
 CONSULTING ENGINEERS
 7348 NW 5TH STREET
 PLANTATION, FLORIDA 33317
 TEL: (954) 327-7111 FAX (954) 327-7154
 ERIC J. HAMMOND P.E.
 MECHANICAL / ELECTRICAL ENGINEER
 P.E. #29946
 EB 5315





CRAIN ATLANTIS
 ENGINEERING, INC.
 CONSULTING ENGINEERS & ARCHITECTS
 210 SW INDIANA AVENUE
 DEERFIELD BEACH, FLORIDA 33441
 AA 20001898
 EB - 2748
 COPYRIGHT 2014 CRAIN ATLANTIS ENGINEERING, INC.

RECEIVED
 12 19 2017
 BUILDING DEPARTMENT
 BCPS

LEGEND:
 ● POINT OF NEW CONNECTION

DRAWING KEY NOTES:
 ① LOCATION OF NEW FAN COIL UNIT (REFER TO MECHANICAL PLANS FOR EXACT LOCATION OF FAN COIL UNITS). PROVIDE NEW CONDENSATE PIPING AS INDICATED AND CONNECT TO EXISTING LINE.
 ② EXISTING 2" CONDENSATE LINE BELOW GRADE.

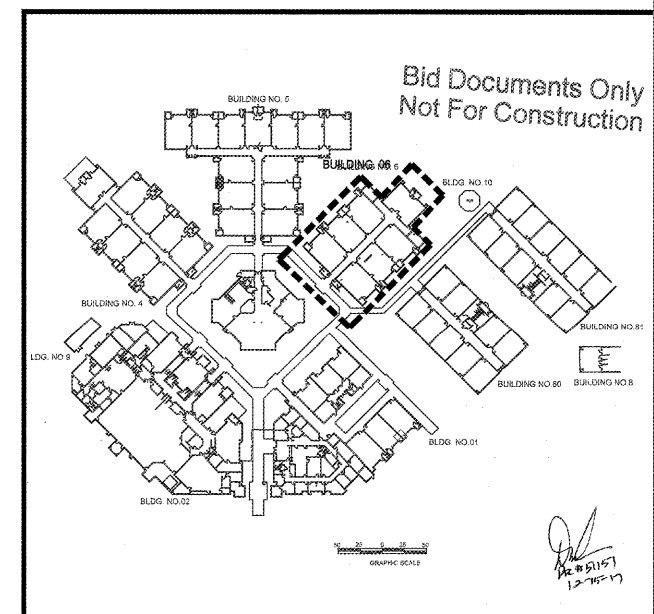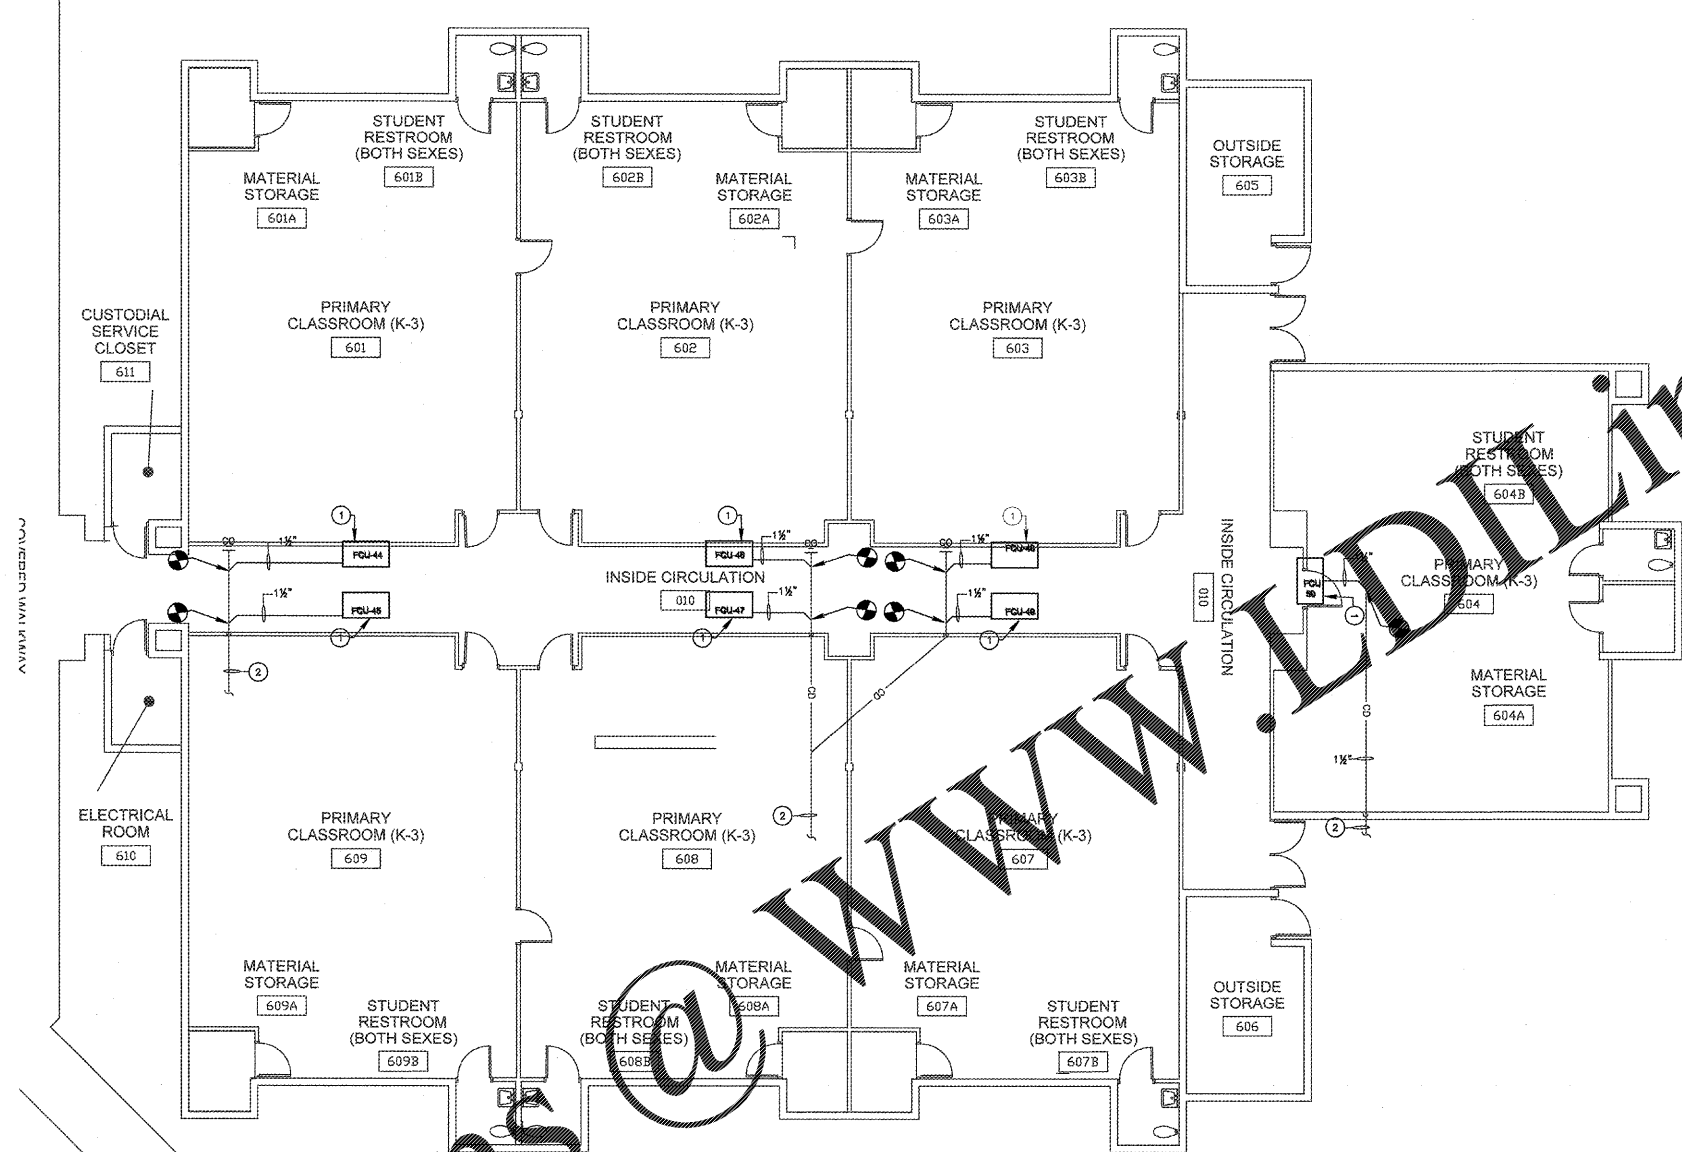

Order Plans @ WWW.LDOnline.com

2 PARTIAL PLUMBING FLOOR PLAN BUILDING 06
 SCALE: 1/8" = 1'-0"

1 KEY PLAN
 SCALE: 1" = 100'-0"

SEA CASTLE
 ELEMENTARY SCHOOL
 9600 MIRAMAR BOULEVARD
 MIRAMAR, FLORIDA 33025



THE SCHOOL BOARD OF BROWARD COUNTY

PARTIAL PLUMBING
 FLOOR PLAN BUILDING 06

JOB PHASE: 100% SUBMITTAL
 SBPC PROJECT: P 001632
 DATE: 12.13.16
 SCALE: AS SHOWN
 DRAWN BY: HA
 CHECKED BY: E.H.
 CAE PROJECT No. 2015.05

FL LICENSE PE# 39048

ERIC HAMMOND
 PROFESSIONAL ENGINEER
 SEAL

DRAWING No.

P-106

THIS IS A VIOLATION OF THE LAW FOR ANY PERSON, UNLESS ACTING UNDER THE DIRECTION OF A LICENSED ARCHITECT, TO ALTER THESE PLANS AND SPECIFICATIONS. THIS DOCUMENT CONTAINS PROPERTY INFORMATION AND SHALL NOT BE USED OR REPRODUCED, IN WHOLE OR IN PART, WITHOUT THE PRIOR WRITTEN CONSENT OF CRAIN ATLANTIS ENGINEERING, INC.