

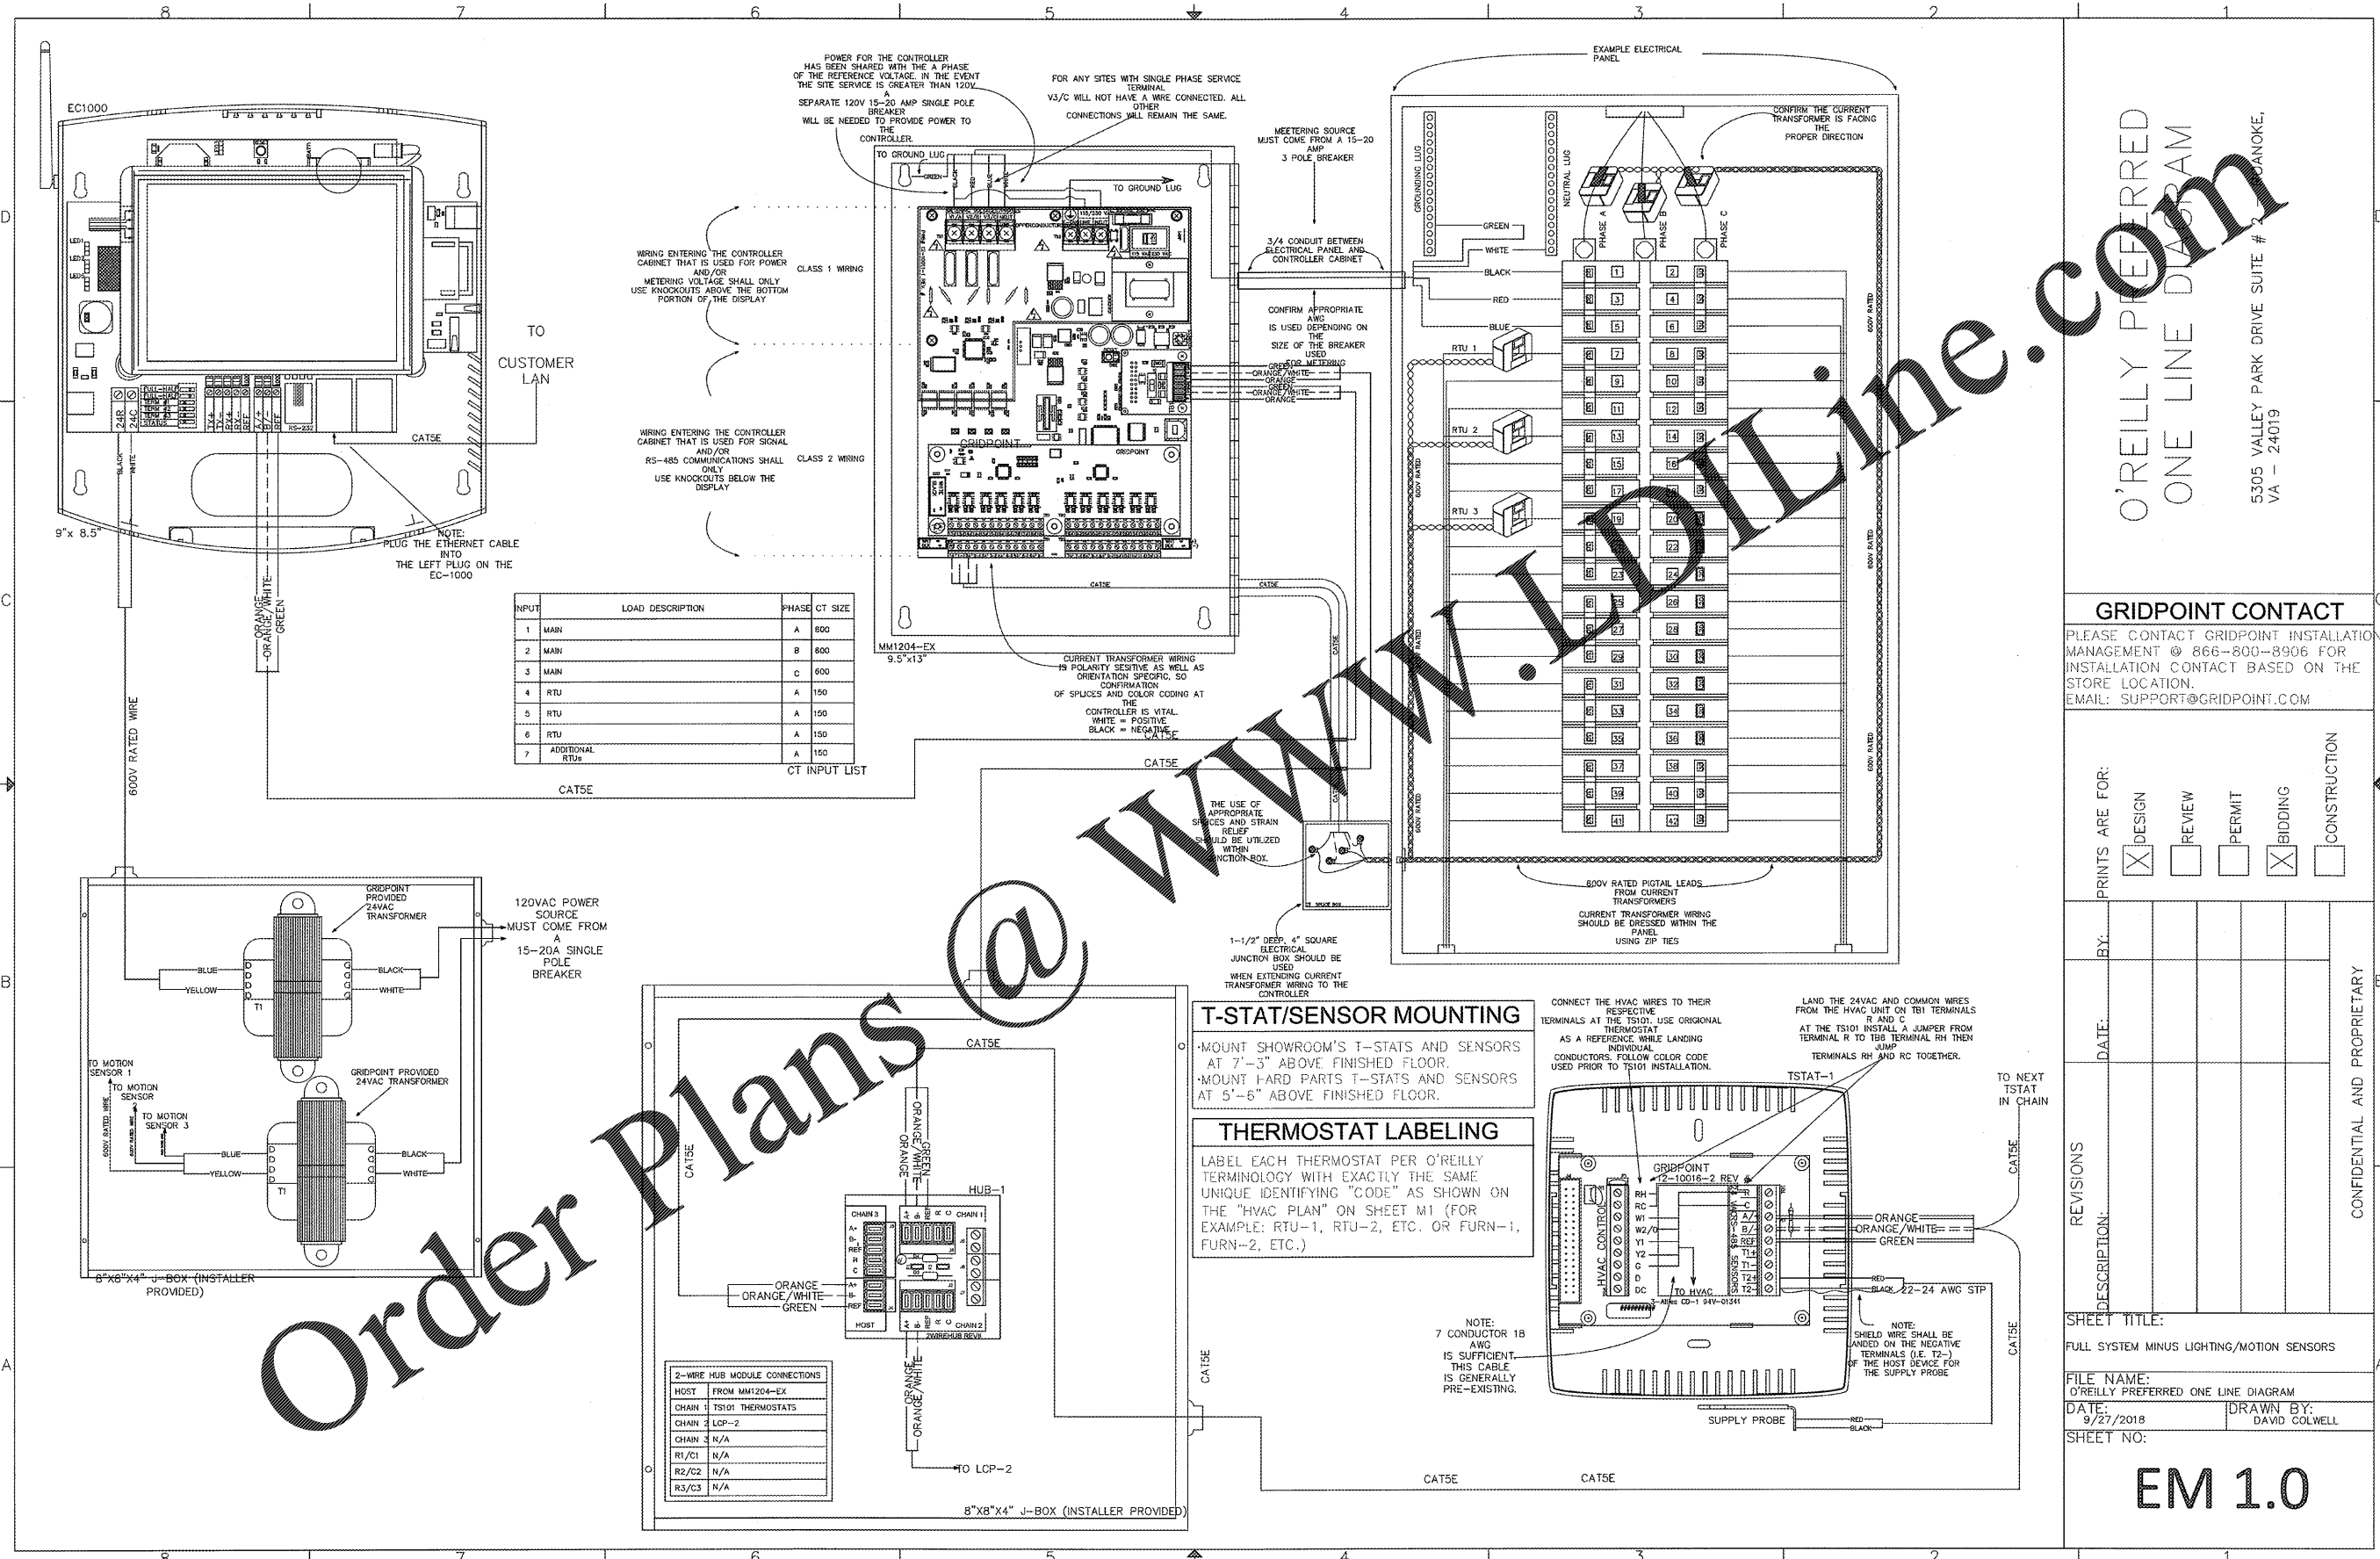


RECEIVED
MAY 02 2018
CASE SPRINGFIELD SUITE 417
SPRINGFIELD, MO

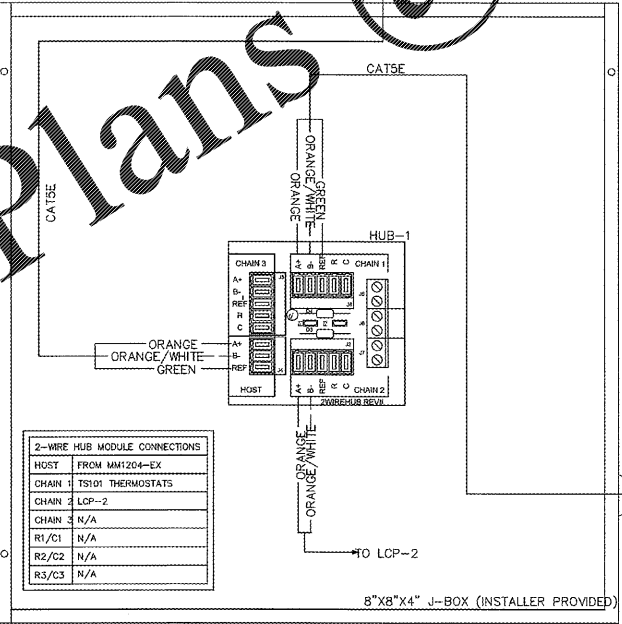

INPUT	LOAD DESCRIPTION	PHASE	CT SIZE
1	MAIN	A	800
2	MAIN	B	800
3	MAIN	C	600
4	RTU	A	150
5	RTU	A	150
6	RTU	A	150
7	ADDITIONAL RTUs	A	150

CT INPUT LIST

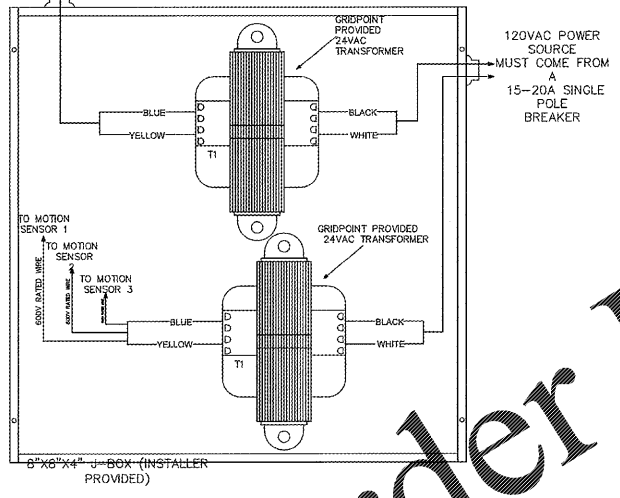


T-STAT/SENSOR MOUNTING

- MOUNT SHOWROOM'S T-STATS AND SENSORS AT 7'-3" ABOVE FINISHED FLOOR.
- MOUNT HARD PARTS T-STATS AND SENSORS AT 5'-6" ABOVE FINISHED FLOOR.

THERMOSTAT LABELING

LABEL EACH THERMOSTAT PER O'REILLY TERMINOLOGY WITH EXACTLY THE SAME UNIQUE IDENTIFYING "CODE" AS SHOWN ON THE "HVAC PLAN" ON SHEET M1 (FOR EXAMPLE: RTU-1, RTU-2, ETC. OR FURN-1, FURN-2, ETC.)

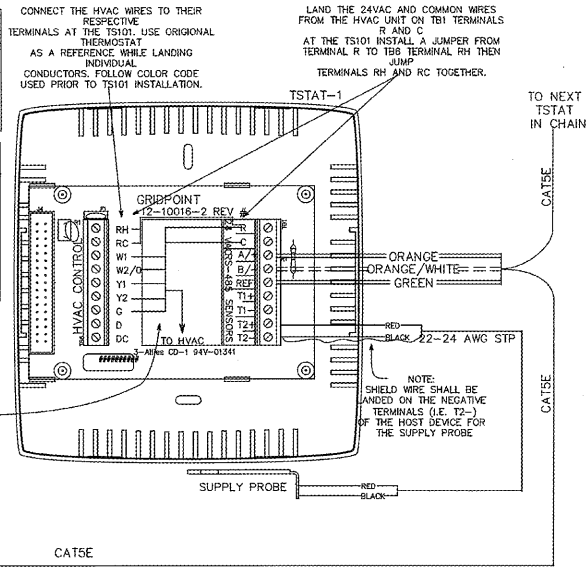

O'REILLY PREFERRED
ONE LINE DIAGRAM

5305 VALLEY PARK DRIVE SUITE # 200
DANOKE, VA - 24019

GRIDPOINT CONTACT

PLEASE CONTACT GRIDPOINT INSTALLATION MANAGEMENT @ 866-800-8906 FOR INSTALLATION CONTACT BASED ON THE STORE LOCATION.
EMAIL: SUPPORT@GRIDPOINT.COM

PRINTS ARE FOR:

DESIGN

REVIEW

PERMIT

BIDDING

CONSTRUCTION

REVISIONS	DESCRIPTION	DATE	BY

SHEET TITLE:
FULL SYSTEM MINUS LIGHTING/MOTION SENSORS

FILE NAME:
O'REILLY PREFERRED ONE LINE DIAGRAM

DATE:
9/27/2018

DRAWN BY:
DAVID COLWELL

SHEET NO:

EM 1.0

Order Plans @

WWW.DIAGRAMS.COM

DESIGN BY OTHERS FOR REFERENCE ONLY

CRAIG A. SCHNEIDER, AIA
ARCHITECT

417.862.8558
417.862.3265
e-mail: architect@esterlyschneider.com

PROJECT:
NEW O'REILLY AUTO PARTS STORE
US HWY 43
WINFIELD, AL

O'Reilly AUTO PARTS

CORPORATE OFFICES
283 SOUTH PATTERSON
WINFIELD, MISSOURI 65002
(417) 862-2674 TELEPHONE

COMM # 4308
DATE: 05-03-19
REVISION DATE: