

P
1

A PLUMBING DOMESTIC WATER RISER DIAGRAMS
 P5.2 SCALE: NONE


NATURAL GAS PIPING DIAGRAM GENERAL NOTES:

1. GAS PIPING HAS BEEN DESIGNED AND SHALL BE INSTALLED IN ACCORDANCE WITH CHAPTER 4 OF THE INTERNATIONAL FUEL GAS CODE - 2015.
2. GAS PIPE SIZING IS BASED UPON TABLE 402.4(5) IN THE INTERNATIONAL FUEL GAS CODE - 2015.
3. GAS PIPING SHALL BE SCHEDULE 40 BLACK STEEL PIPE WITH MALLEABLE IRON FITTINGS. WHERE GAS PIPING CONNECTS TO EQUIPMENT IT SHALL BE PROVIDED WITH A DRIP LEG THE FULL SIZE OF THE SUPPLY PIPE, A 100% SHUT OFF GAS COCK AND A UNION. ALL OUTSIDE GAS PIPING SHALL BE GALVANIZED STEEL PIPE.
4. GAS SUPPLY PRESSURE = 2 PSI.
5. PORTIONS OF GAS PIPING SYSTEM INSTALLED IN CONCEALED LOCATIONS SHALL NOT HAVE UNIONS, TUBE FITTINGS OR RUNNING THREADS.

NATURAL GAS PIPING DIAGRAM KEY NOTES:

KITCHEN EQUIPMENT GAS REQUIREMENT IS ESTIMATED AND SHALL BE CONFIRMED BY CONTRACTOR PRIOR TO FINAL GAS PIPING INSTALLATION.

POOL HEATER GAS REQUIREMENT IS ESTIMATED AND SHALL BE CONFIRMED BY CONTRACTOR PRIOR TO FINAL GAS PIPING INSTALLATION.

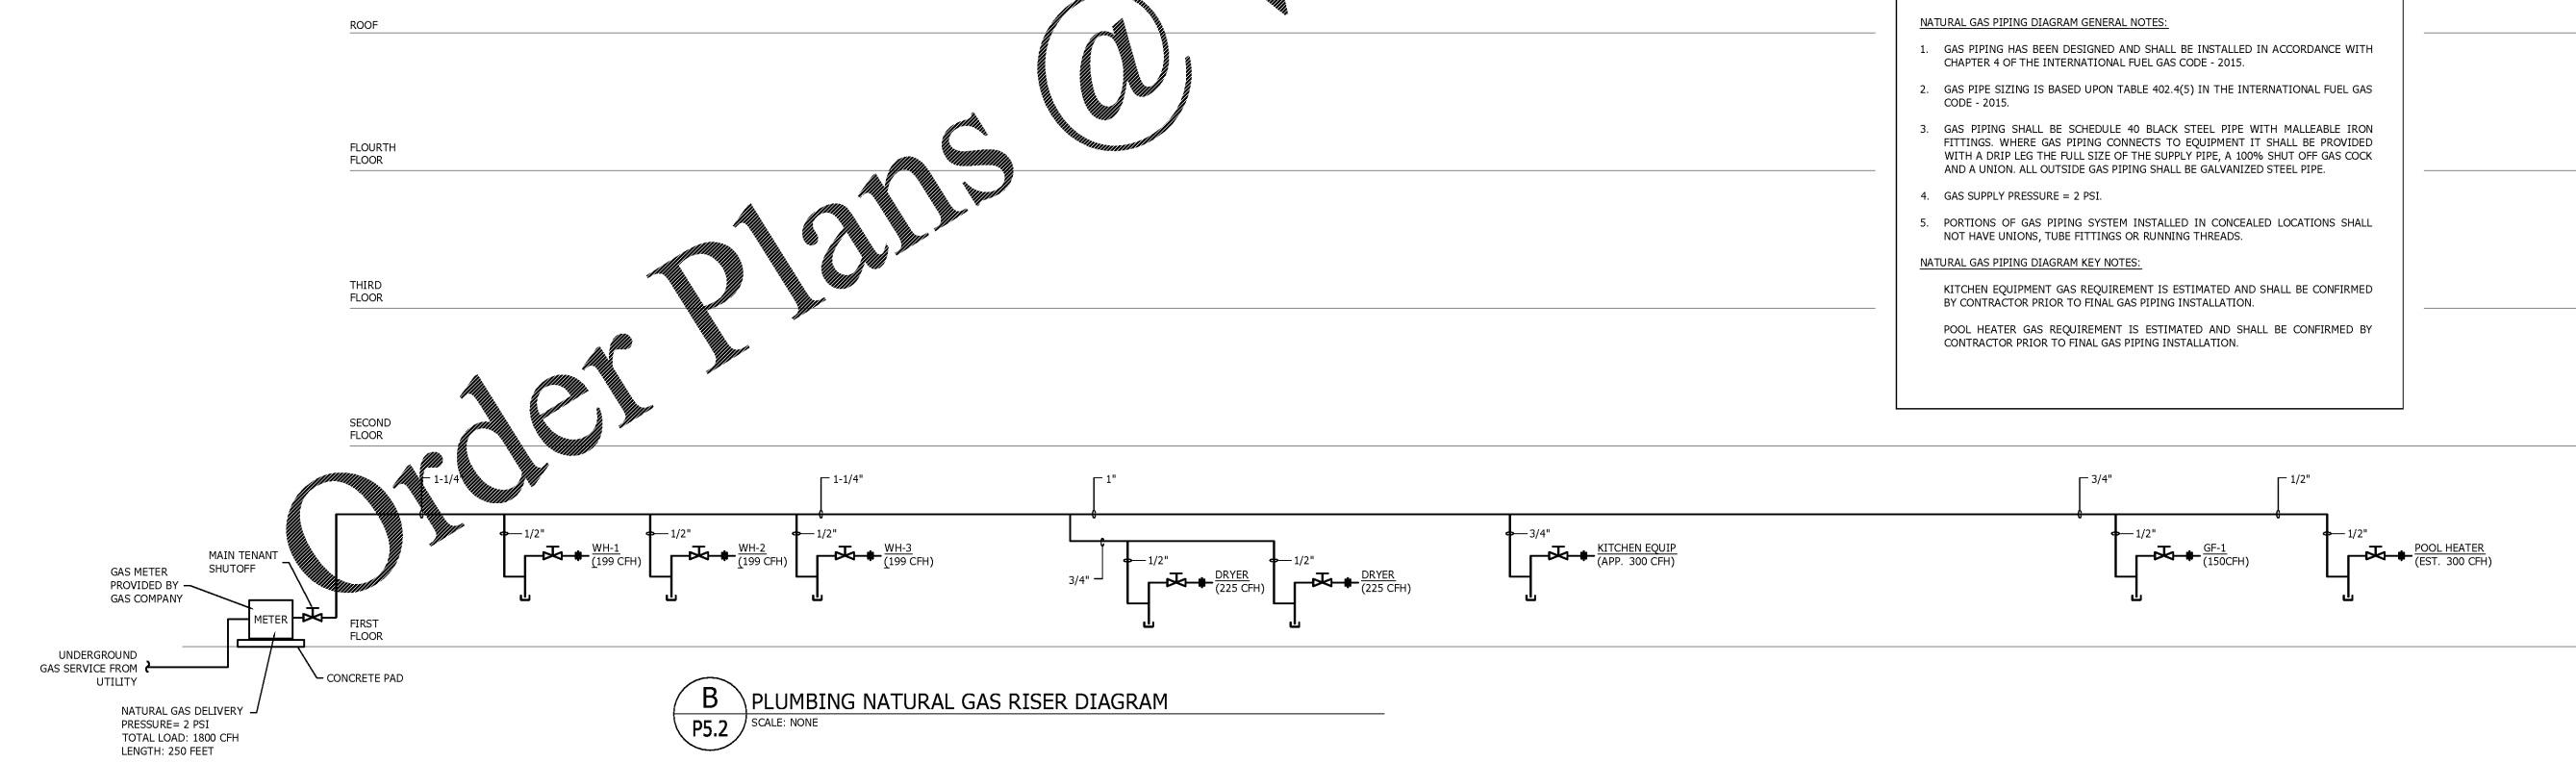

B PLUMBING NATURAL GAS RISER DIAGRAM
 P5.2 SCALE: NONE

No.	Description	Date

DISCLAIMER: entegra™ is providing this information for informational purposes only and not as a new product or as a record. entegra™ does not warrant the accuracy, completeness, or reliability of the information provided. entegra™ is not responsible for any errors or omissions in this document. entegra™ is not responsible for any damages, including consequential damages, arising from the use of this information. entegra™ is not responsible for any damages, including consequential damages, arising from the use of this information. entegra™ is not responsible for any damages, including consequential damages, arising from the use of this information.

MEISTER COX ARCHITECTS
 INFO@MEISTER-COX.COM
 PHONE: 610-375-1331 FAX: 610-375-4555
 1522 PENN AVENUE WYOMISSING, PA 19610
 WWW.MEISTER-COX.COM

SEAL:

PLUMBING RISER DIAGRAMS

HOLIDAY INN EXPRESS & SUITES
 INTERSECTION OF HAYNES PLACE & LAMM RD.
 WILSON, NC 27883

STATUS: FOR BID
 PROJ. DATE: 06/06/2019
 PROJ. NO: 19-116
 PRINTED: 06/06/2019
 DRAWN BY: jlm/brm/jpk
 CHECKED BY: brm
 SHEET NO: P5.2
 SCALE: AS NOTED