

No.	Description	Date


DISCLAIMER: entegra is providing this information for informational purposes only and not as a new product or as a record. entegra does not warrant the accuracy, completeness, or reliability of the information provided. entegra is not responsible for any errors or omissions in this information. entegra is not responsible for any damages, including consequential damages, arising from the use of this information. entegra is not responsible for any legal actions taken against it as a result of the use of this information. entegra is not responsible for any legal actions taken against it as a result of the use of this information.

**MEISTER COX ARCHITECTS**  
 INFO@MEISTER-COX.COM  
 PHONE: 610-375-1331 FAX: 610-375-4555  
 1522 PENN AVENUE WYOMISSING, PA 19610  
 WWW.MEISTER-COX.COM

SEAL:

**ELECTRICAL FOURTH FLOOR PLAN - POWER**  
 HOLIDAY INN EXPRESS & SUITES  
 INTERSECTION OF HAYNES PLACE & LAMM RD.  
 WILSON, NC 27883

STATUS:	FOR BID
PROJ. DATE:	06/06/2019
PROJ. NO.:	19-116
PRINTED:	06/06/2019
DRAWN BY:	jlm/brm/jpk
CHECKED BY:	brm
SHEET NO.:	E2.7
SCALE:	AS NOTED

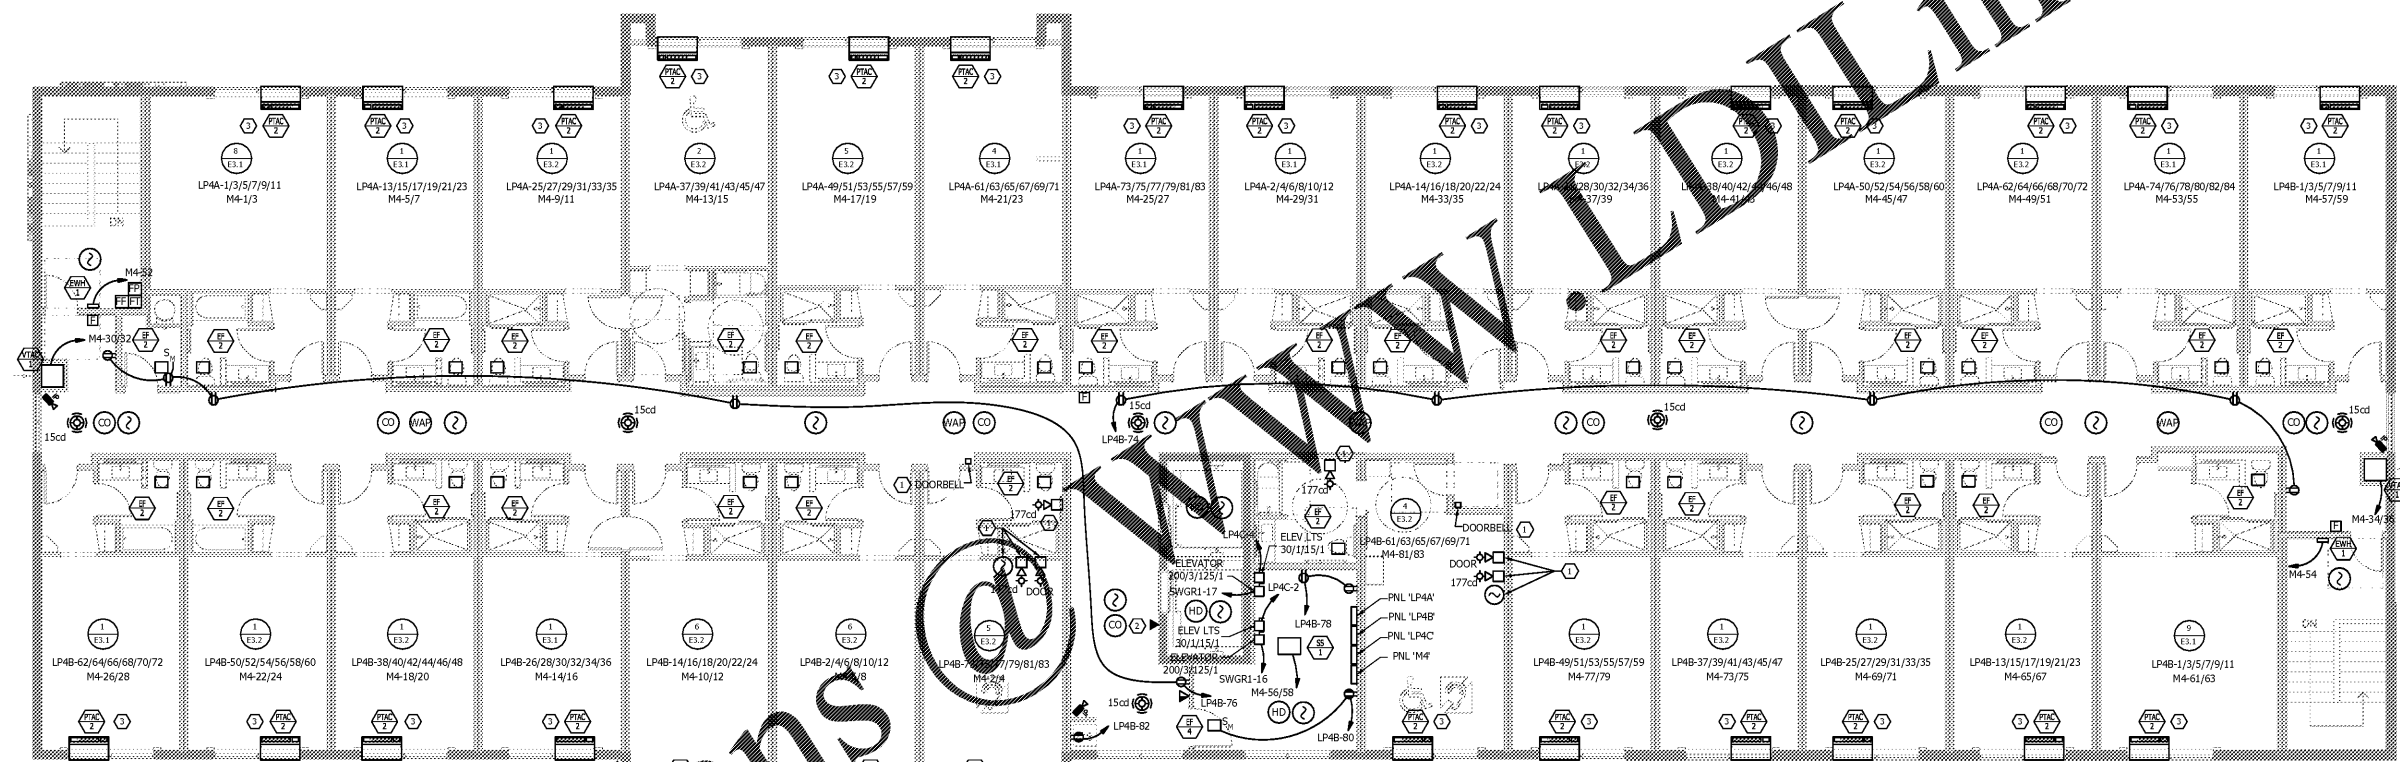

**A**  
**E2.7** ELECTRICAL FOURTH FLOOR PLAN - POWER  
 SCALE: 1/8" = 1'-0"

- NEW WORK KEYED NOTES:**
- 1. FOR HEARING IMPAIRED ROOMS, PROVIDE THE FOLLOWING DEVICES:
    - DOOR BELL AT SUITE ENTRANCE
    - STROBE IN SUITE TO IDENTIFY DOOR BELL ACTIVATION WITH CLIP SWITCH (SEPARATE FROM FIRE ALARM SYSTEM)
    - 17V COX HORN/STROBE CONNECTED TO BUILDING FIRE ALARM SYSTEM IN BEDROOM
    - 17V COX STROBE CONNECTED TO BUILDING FIRE ALARM SYSTEM IN BATHROOM
    - ADDRESSIBLE SMOKE DETECTOR WITH SOUNDER BASE AND STROBE WHICH ACTIVATES UPON SMOKE ALARM
  - 2. FIRE DEPARTMENT 2-WAY COMMUNICATION/HOUSE PHONE.
  - 3. PROVIDE 30 AMP, 208 VOLT PLUG FOR PTAC-3. SEE ENLARGED ROOM PLANS FOR WIRING.

- GENERAL NOTES:**
1. REFER TO MECHANICAL DRAWINGS FOR SMOKE DAMPER LOCATIONS. ALL SMOKE DAMPERS SHALL BE WIRED TO 120 VOLT AVAILABLE DEDICATED CIRCUIT. ALL SMOKE DAMPERS SHALL BE CONTROLLED VIA FIRE ALARM SYSTEM ACTIVATION. PROVIDE ALL LINE VOLTAGE WIRING AND FIRE ALARM WIRING AS REQUIRED TO MEET IBC SECTION 716 REQUIREMENTS.
  2. PROVIDE SOUND SYSTEM PER FRANCHISE REQUIREMENTS. COORDINATE ALL WORK WITH FRANCHISE AND OWNER PRIOR TO INSTALLATION.
  3. REFER TO ENLARGED PLANS FOR POWER CIRCUITING, LIGHTING CIRCUITING, EXHAUST FAN REQUIREMENTS, AND PTAC REQUIREMENTS.

Order Plans @ WWW.LDLine.com