


Order Plans @ www.LDILine.com

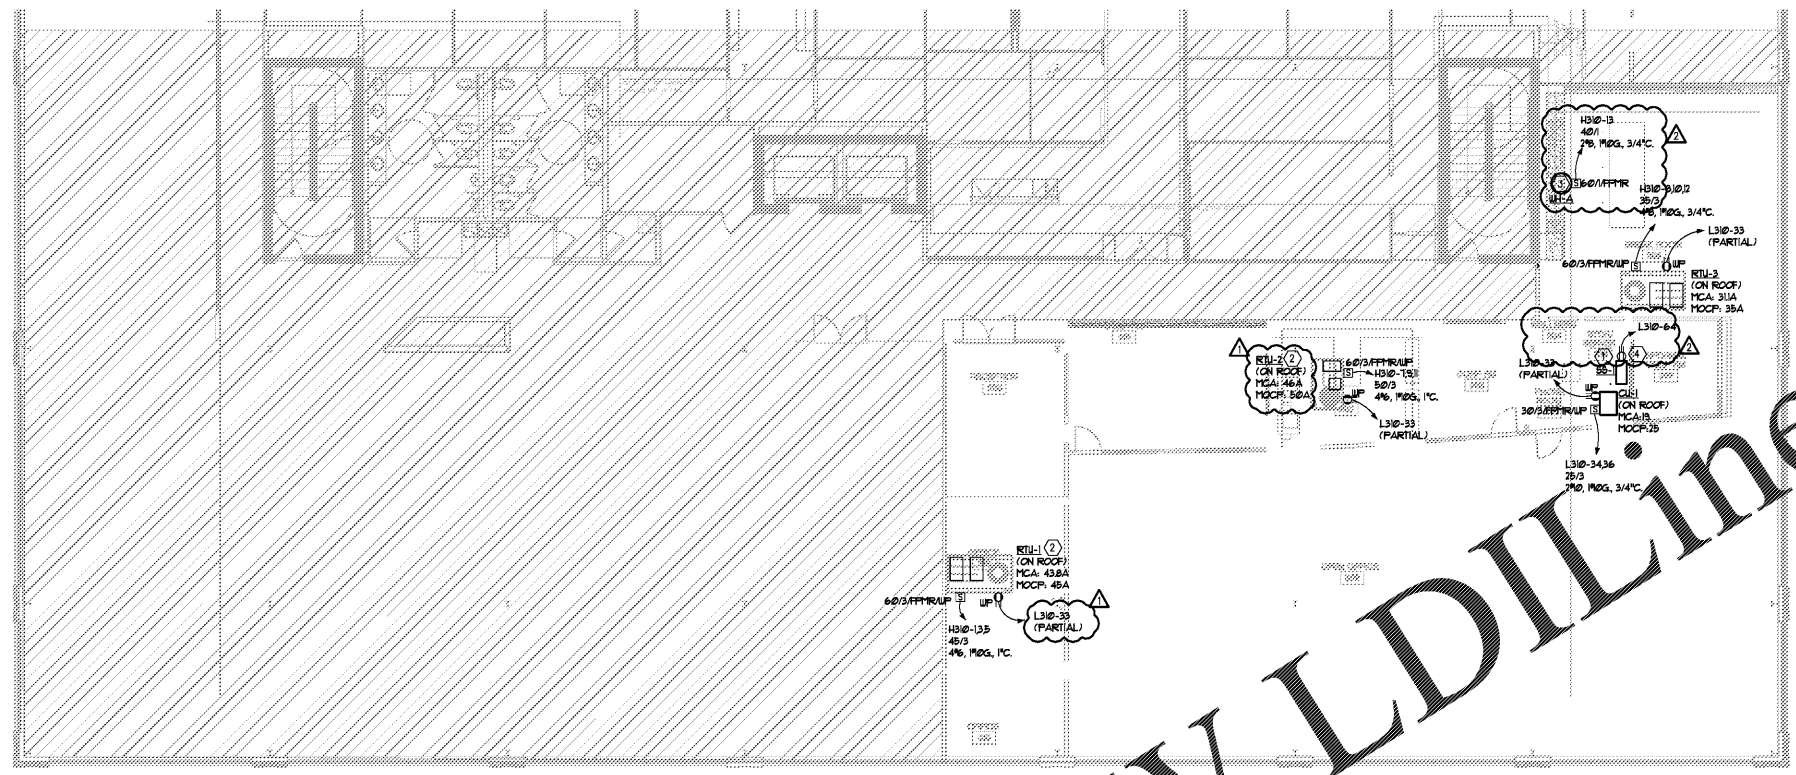

1 THIRD FLOOR PLAN - MECHANICAL CONNECTIONS
E3.3 1/8"=1'-0"

LEGEND NOTES:
(APPLY THIS SHEET ONLY)

- ① INDOOR "SS-1" UNIT POWERED BY OUTDOOR "OU-1" UNIT ON THE ROOF. COORDINATE WITH MECHANICAL CONTRACTOR.
- ② PROVIDE DUCT DETECTOR IN SUPPLY AND RETURN.
- ③ COORDINATE LOCATION OF WATER HEATER WITH PLUMBING CONTRACTOR.
- ④ PROVIDE RECEPTACLE AT UNIT FOR CONDENSATE PUMP. COORDINATE LOCATION WITH MECHANICAL CONTRACTOR.

GENERAL NOTES:
(APPLY THIS SHEET ONLY)

- 1. COORDINATE ALL EQUIPMENT LOCATIONS AND CONNECTION REQUIREMENTS WITH THE HVAC CONTRACTOR (DIV23) AND/OR PLUMBING CONTRACTOR (DIV22) PRIOR TO INSTALLATION.
- 2. HATCHED AREA NOT IN THIS SCOPE OF WORK.
- 3. "E" DENOTES EXISTING DEVICE TO REMAIN. "R" DENOTES EXISTING DEVICE TO BE RELOCATED.
- 4. CIRCUIT HOMERUN DESIGNATIONS ARE NOTED FOR DESIGN INTENT ONLY BASED ON FIELD OBSERVATIONS OF EXISTING PANEL SCHEDULES, WHERE AVAILABLE. CONTRACTOR TO CONFIRM ALL SPARE CIRCUIT BREAKERS AND THOSE MADE AVAILABLE DUE TO DEMOLITION.
- 5. REFER TO SHEET E1.3 FOR LOCATION OF ELECTRICAL DISTRIBUTION PANELS.
- 6. ALL FIRE ALARM DEVICES ARE TO BE WHITE.



NOVUS

always new
1950 ABBOTT STREET, STE 605
CHARLOTTE, NC 28203
704-373-3101
FAX 704-373-3103
WWW.NOVUSARCHITECTS.COM



carrie frye
interior design
2126 CHARLOTTE DR.
CHARLOTTE, NC 28203
704-996-7705
WWW.CFIDSTUDIO.COM

BW & A Barrett, Woodyard and Associates, Inc.
License # C-2228

420 Minnet LN.
Charlotte, North Carolina 28217
(p) 704-357-9333 (f) 704-357-9385
© This drawing is copyrighted. It may not be reproduced nor used in any other form or on any other project.
BWA JOB # 2019-0895



BR+A
300 West Summit
Office Bldg

300 West Summit Ave.
Suite #310
Charlotte, NC 28203

PROJECT NUMBER: 19-018

CONSTRUCTION ISSUE	6.20.2019
PERMIT COMMENTS	05.24.2019
CLIENT CLARIFICATIONS	07.03.2019

THIRD FLOOR PLAN - MECHANICAL CONNECTIONS
SCALE: AS NOTED

E3.3