




Order Plans @ [www.LDILine.com](http://www.LDILine.com)

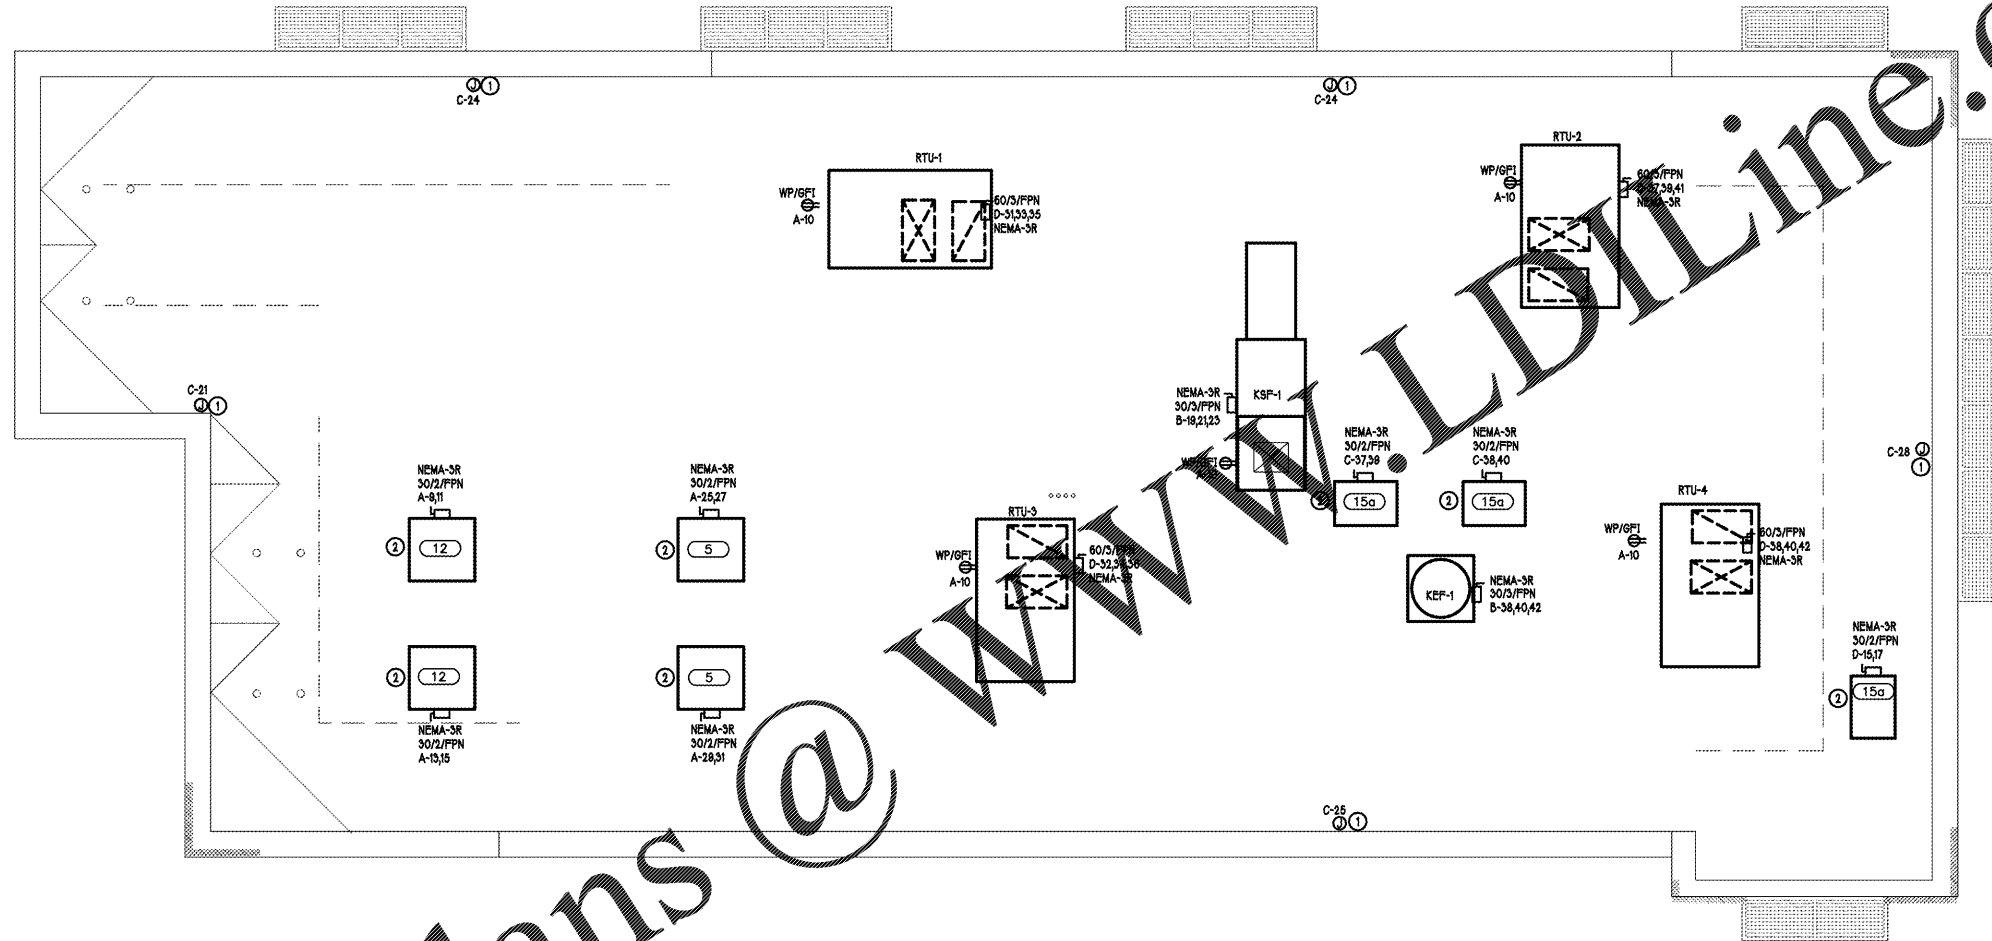

1 ROOF POWER PLAN  
 E2A 1/4" = 1' - 0"

- TAGGED NOTES:**
- ① VERIFY NEON SIGN LOCATIONS WITH OWNER OR ARCHITECT PRIOR TO ROUGH-IN.
  - ② SEE SHEET E2 FOR KITCHEN EQUIPMENT SCHEDULE.

Mk	Date	Description
		Revisions

**ROOF POWER PLAN**

Date 06/13/19  
 Drawn By DAG  
 Check By DRP  
 Job No. 19-037  
 Sheet

**E2A**