


Jarrigh & Associates Development Engineers  
 208 Greene Road North, Flatbore, Alabama 36632  
 P.O. Box 1929, Flatbore, Alabama 36633  
 251.921.3443 (cell) 251.921.3605 (fax)  
 jarrigh.com

**JADE**  
 CONSULTING, LLC  
 251.921.3443 (cell) 251.921.3605 (fax)  
 jadeinc.com

architects inc.  
 Montgomery, Alabama

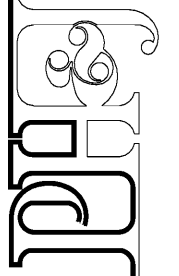

CIP-2017-001  
 UPGRADES TO THE MOBILE COUNTY METRO JAIL  
 For The MOBILE COUNTY COMMISSION  
 MOBILE, ALABAMA



DRAWN	SER	CHECK	PCY
DATE	April 2, 2019 RTA		
REVISED			
REVISED			


SHEET TITLE	DEMOLITION PLAN
BASE BID	
JOB NO.	PH&J 1801-GV
SEQUENCE	NO. 3 OF 175

**C2.0**

© PH&J ARCHITECTS, INC.  
 ALL RIGHTS RESERVED

**LEGEND**

	TEMPORARY BENCHMARK
	RIGHT-OF-WAY
	CENTERLINE
	EXIST. OVERHEAD UTILITY AND SAFETY POLE
	EXIST. WATER AND UTILITY POLE
	EXIST. WATER LINE
	EXIST. SANITARY SEWER LINE
	EXIST. FENCE LINE
	EXIST. PIPE
	EXIST. 1 FOOT CONTOUR
	EXIST. 5 FOOT CONTOUR
	EXIST. GRADE SPOT ELEVATION
	EXIST. POWER POLE
	EXIST. LIGHT POLE
	EXIST. ELECTRICAL BOX
	EXIST. ELECTRICAL METER
	EXIST. ELECTRICAL OUTLET
	EXIST. SURVEILLANCE CAMERA
	EXIST. WATER METER
	EXIST. WATER VALVE
	EXIST. WATER WELL
	EXIST. IRRIGATION CONTROL VALVE
	EXIST. BACKFLOW PREVENTOR
	EXIST. FIRE HYDRANT
	EXIST. SANITARY SEWER MANHOLE
	EXIST. SANITARY SEWER CLEANOUT
	EXIST. GREASE TRAP
	EXIST. COMMUNICATION VAULT
	EXIST. COMMUNICATION MARKER
	EXIST. ENTRY KEYPAD / BADGE READER
	EXIST. UNKNOWN VAULT
	EXIST. SIGN
	EXIST. DELINEATION MARKER
	EXIST. MONITORING WELL
	EXIST. LANDSCAPED AREA
	EXIST. GUARDRAIL
	EXIST. SHRUB LINE
	EXIST. LIVE OAK TREE
	EXIST. OAK TREE
	EXIST. PECAN TREE
	EXIST. POPOORN TREE
	EXIST. SYCAMORE TREE
	EXIST. BARTLETT PEAR TREE
	EXIST. CREPE MYRTLE
	EXIST. GAS VALVE
	EXIST. GAS REGULATOR
	EXIST. TELEPHONE BOX
	EXIST. STORM SEWER MANHOLE
	EXIST. ASPHALT PAVING
	EXIST. CONCRETE
	EXIST. GRAVEL
	TO BE REMOVED
	TO BE REMOVED
	TO BE REMOVED
	TREE PROTECTION

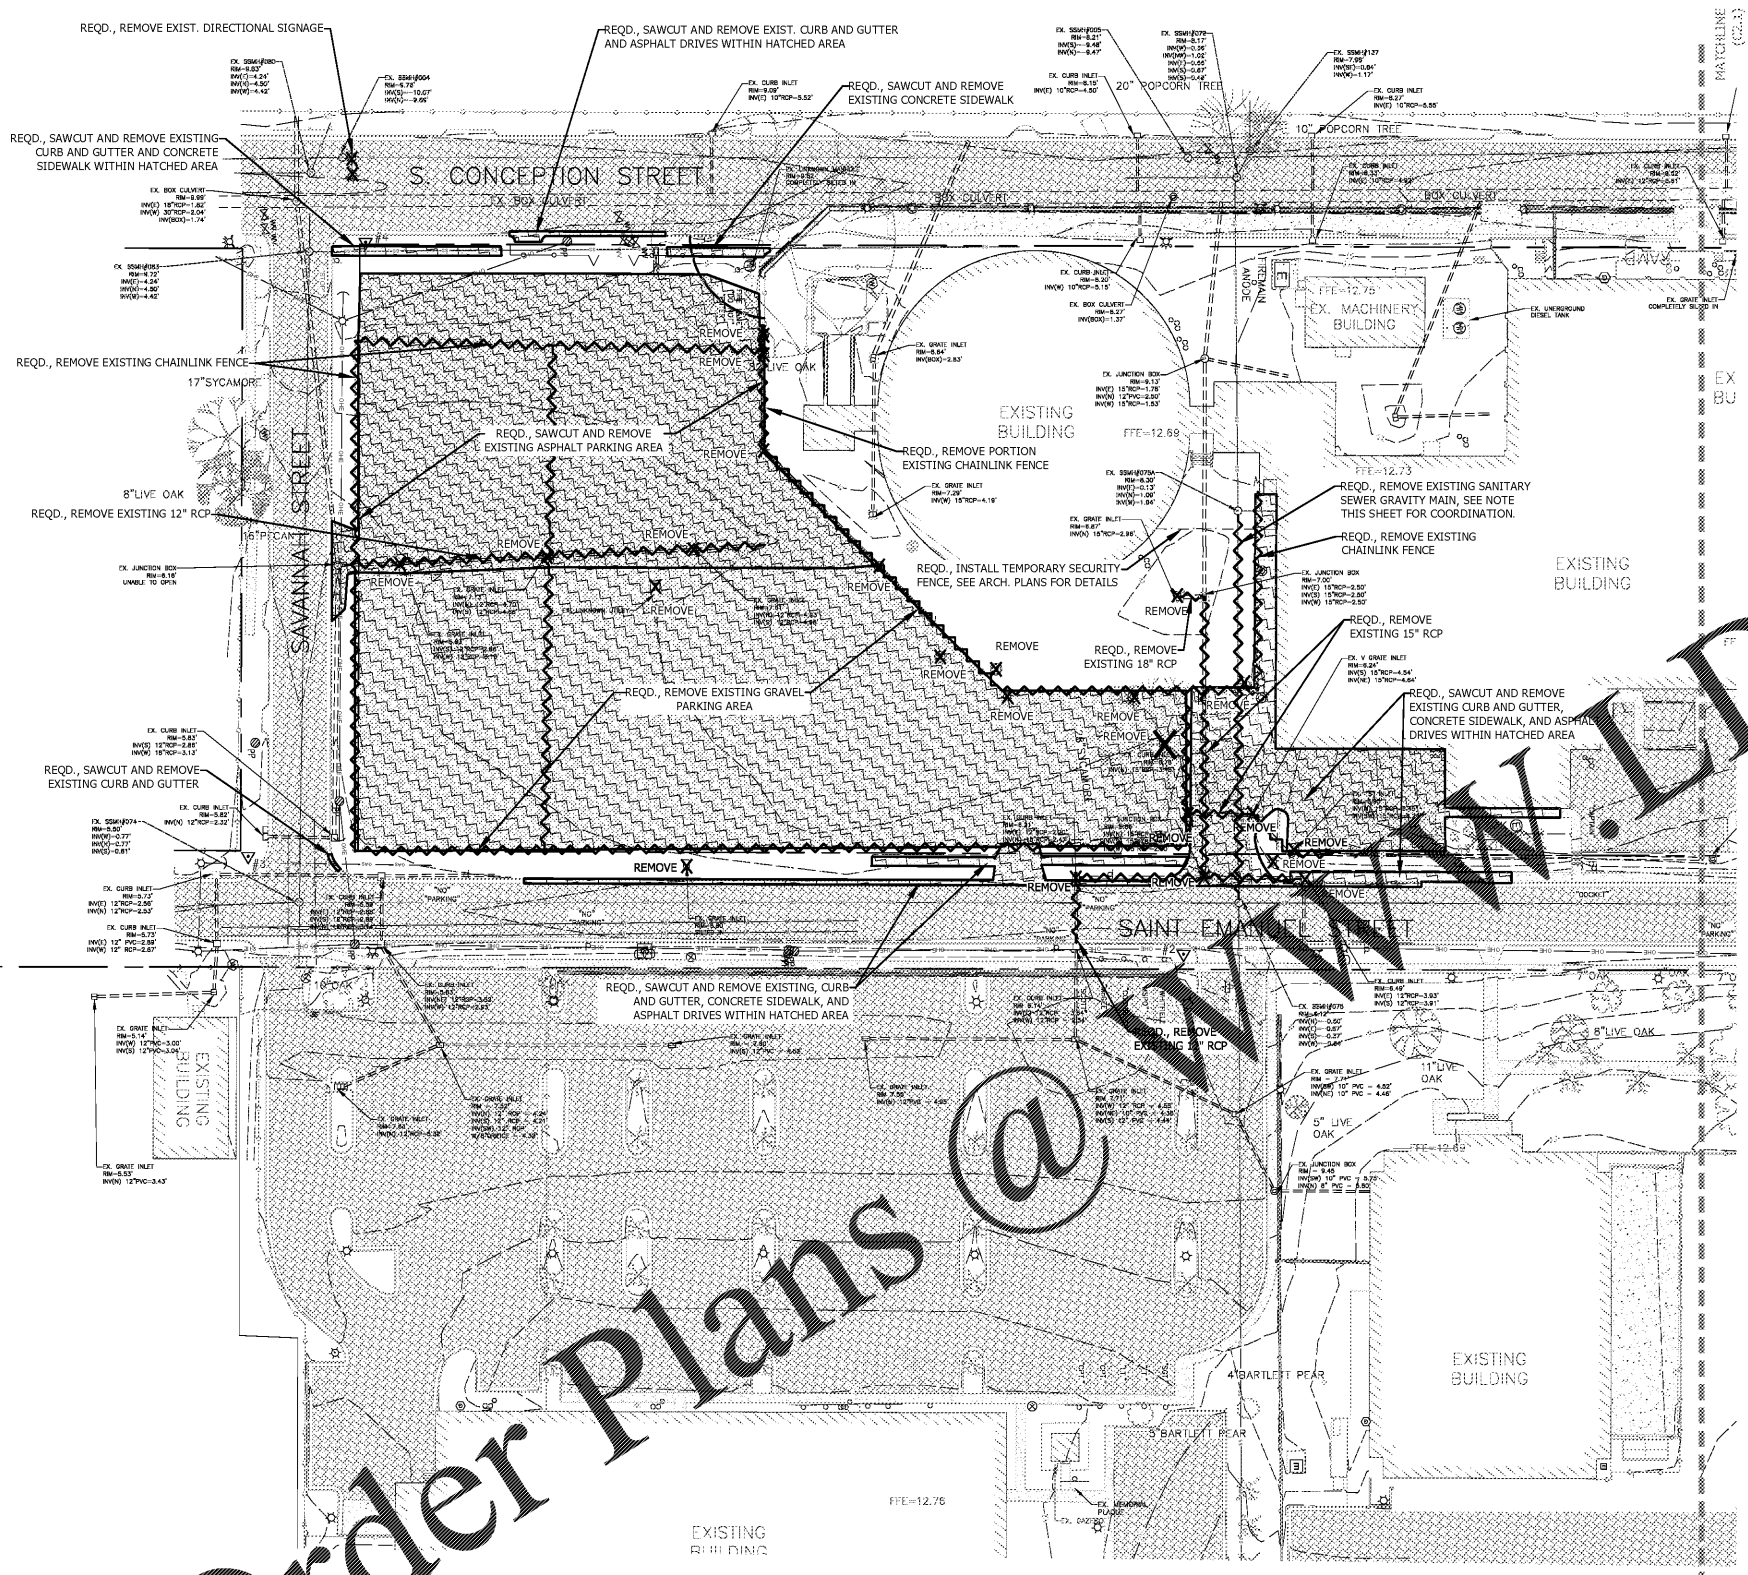

**SANITARY SEWER DEMOLITION NOTES**

- EXISTING SANITARY SEWER LINE SHALL REMAIN IN PLACE AND FUNCTIONAL WHILE THE NEW SANITARY MANHOLES AND LINES ARE INSTALLED.
- CONTRACTOR SHALL PROVIDE BYPASS PUMPING OF THE EXISTING SYSTEM WHEN MAKING CONNECTIONS TO EXISTING MANHOLES.

**NOTES**

- ALL NEW WORK SHOWN IN THESE PLANS SHALL COMPLY WITH APPLICABLE STATE, FEDERAL AND LOCAL BUILDING AND UTILITY INSTALLATION CODES.
- ALL DEMOLITION TO BE DISPOSED OF IN ACCORDANCE WITH ALL LOCAL, STATE, AND FEDERAL LAWS AND REGULATIONS.
- ALL MATERIALS AND CONSTRUCTION METHODS SHALL BE IN ACCORDANCE WITH THE ALABAMA DEPARTMENT OF TRANSPORTATION STANDARD SPECIFICATIONS EXCEPT IN CASES WHERE, WITHIN CITY OF MOBILE JURISDICTION, THE CITY OF MOBILE STANDARD SPECIFICATIONS ARE MORE STRINGENT.
- NO WORK SHALL COMMENCE, INCLUDING DEMOLITION, UNTIL ALL APPLICABLE EROSION CONTROL MEASURES HAVE BEEN INSTALLED, INSPECTED BY THE PROJECT ENGINEER, AND APPROVED.
- EROSION CONTROL DEVICES ARE TO BE INSTALLED PRIOR TO ANY CLEARING OR EARTHWORK OPERATIONS AND SHALL BE MAINTAINED THROUGHOUT CONSTRUCTION AND UNTIL PERMANENT GROUND COVER IS ESTABLISHED IN ALL DISTURBED AREAS.

Survey Provided by:  
**Wattier Surveying, Inc.**  
 Professional Land Surveyors  
 4321 Downwater Loop N., Suite 201 251-342-2640  
 Mobile, Alabama 36609 fax 251-342-2648