





DRAWN	LM	CHECK	HG
DATE	April 2, 2019 RTA		
REVISED			
REVISED			
SHEET TITLE			
CRAWL SPACE PLAN			
JOB NO.			
PH&J 1801-GV			
SEQUENCE NO.			
38 of 175			

A1.4


PH&J ARCHITECTS, INC.
ALL RIGHTS RESERVED

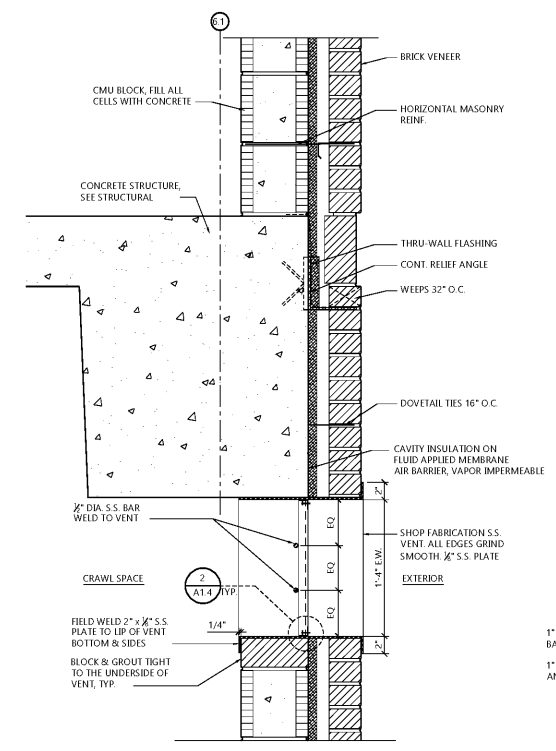

1 TYPICAL CRAWL SPACE VENT DETAIL
SCALE: 1 1/2" = 1'-0"

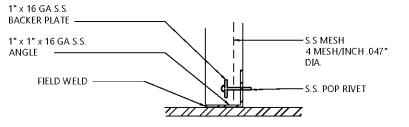


2 VENT MESH DETAIL
SCALE: 6" = 1'-0"

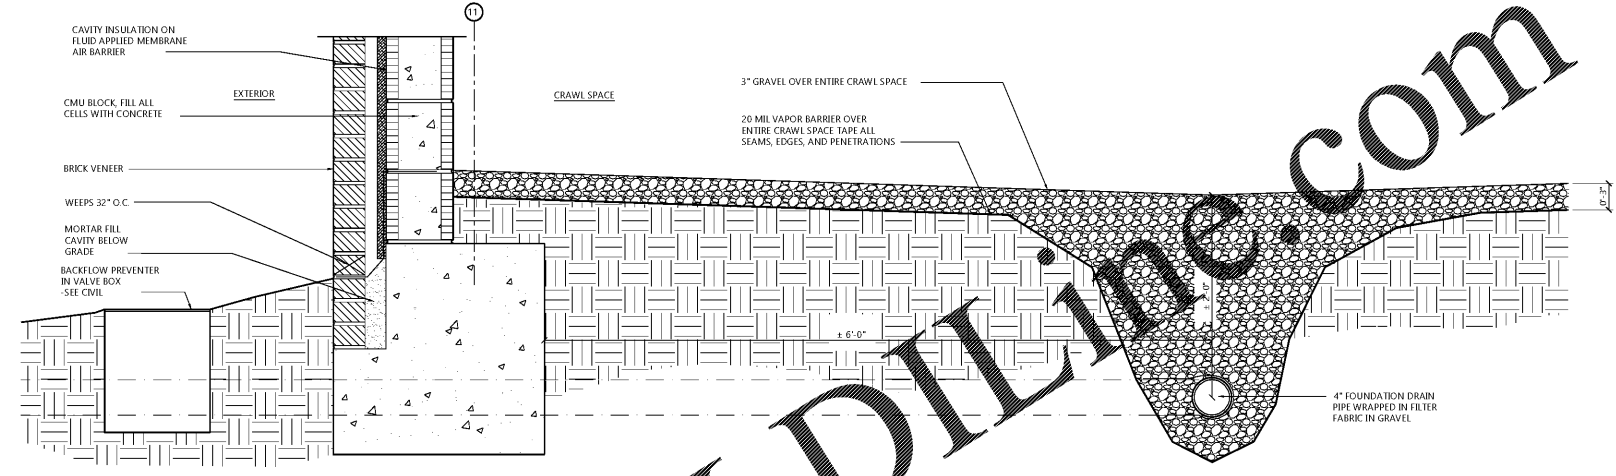


3 CRAWL SPACE DRAINAGE DETAIL
SCALE: 1 1/2" = 1'-0"

LEGEND
UNDERDRAINAGE
FOUNDATION WALL

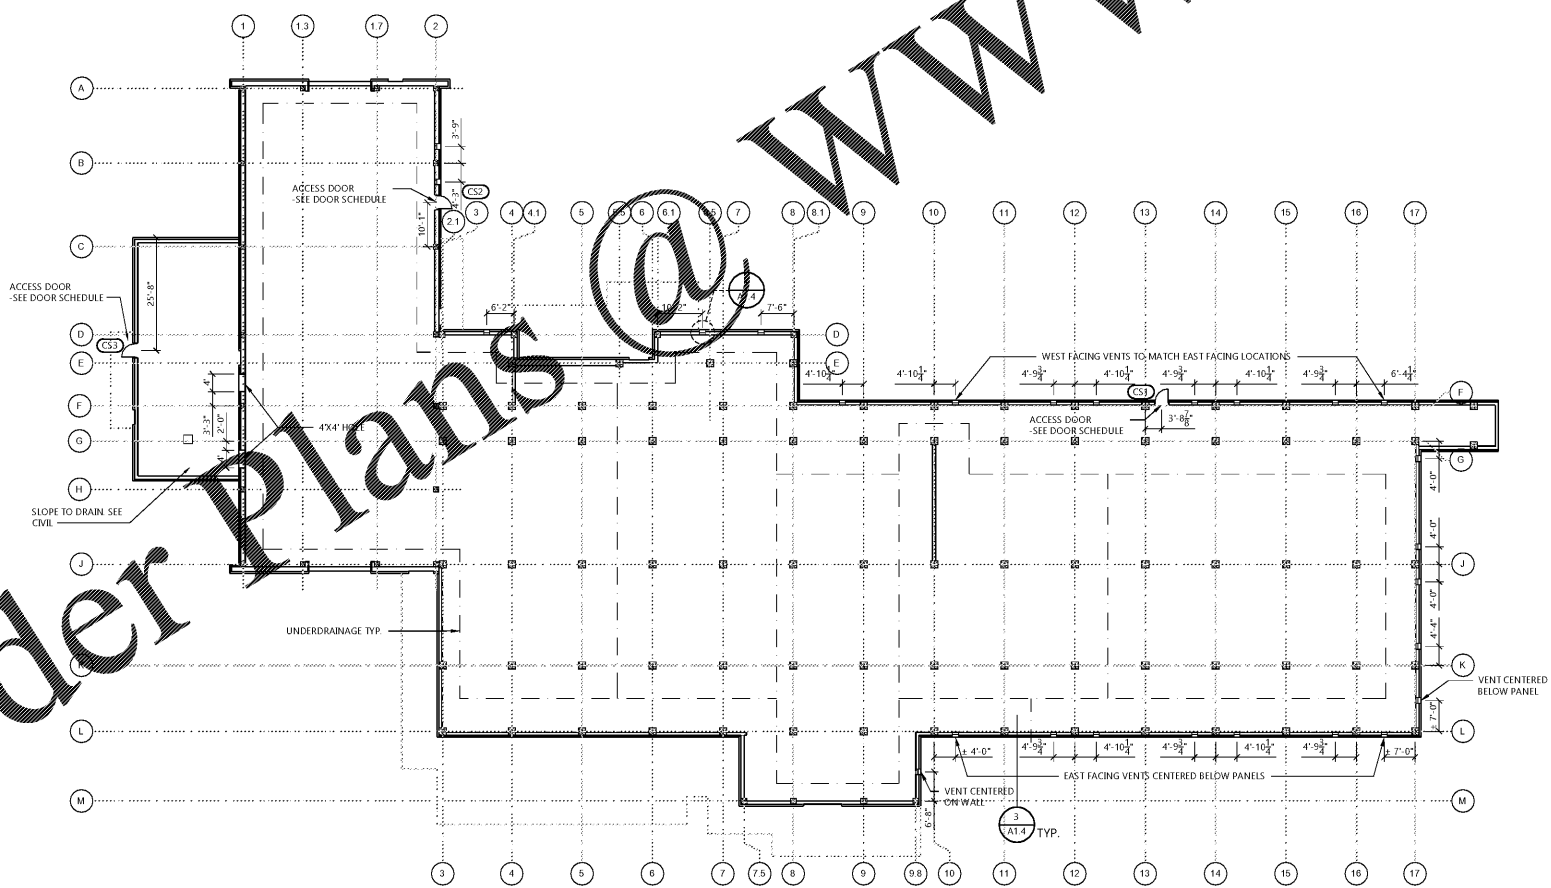

CRAWL SPACE PLAN
SCALE: 1/16" = 1'-0"
GRAPHIC SCALE

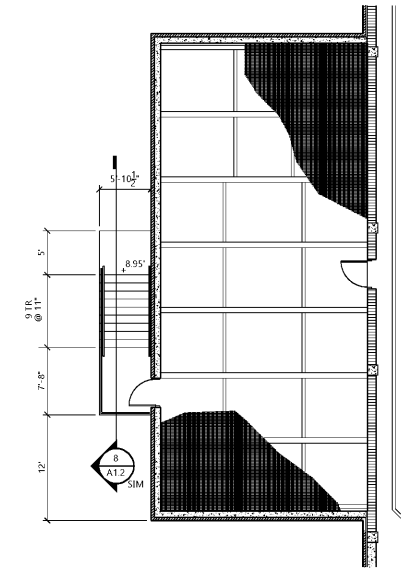

PARTIAL SITE PLAN - GENERATOR YARD
SCALE: 1/8" = 1'-0"
FIN FLOOR ELEV = 14.0'
GRAPHIC SCALE

Order Plans @ WWW.LDILINE.COM

WWW.LDILINE.COM