



Order Plans @ www.LDILine.com

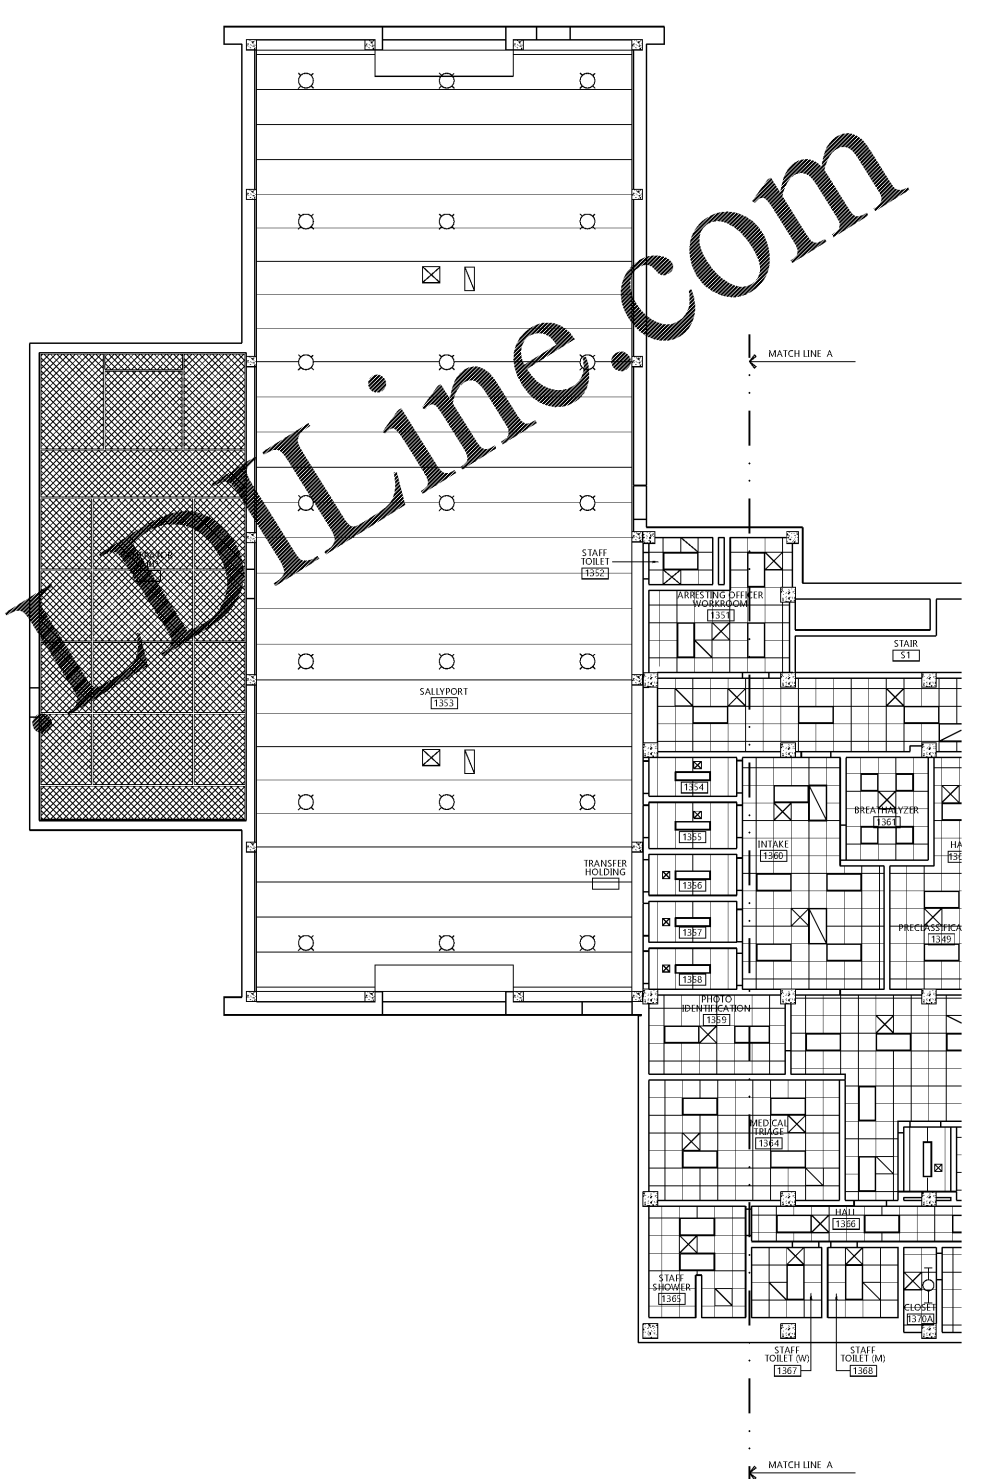

CEILING PLAN LEGEND	
	LIGHT FIXTURES
	HVAC GRILLES
	SECURITY MESH EXHAUST GRILLES SMOKE EVACUATION DUCT OPENING, KITCHEN RETURN AIR AND ETC.
	SECURITY CEILING ACCESS PANEL
	2'x2' GRID CEILING TILE & GRID - SEE FINISH SCHEDULE FOR TYPE
	SECURITY CEILING (PLANK TYPE) SEE FINISH SCHEDULE
	GYP. BOARD CEILING
	METAL GRATE

NOTE:
 1. FINAL POSITIONING OF ACCESS PANELS TO PROVIDE SERVICE ACCESS TO ALL BALANCING DAMPERS, FIRE DAMPERS, EQUIPMENT, VALVE CLEANOUTS, ETC.
 2. PROVIDE ADDITIONAL ACCESS PANELS AS REQUIRED TO SERVICE ALL ABOVE ITEMS.
 3. SEE DETENTION PLANS FOR CAMERA LOCATIONS AND DURESS STROBES

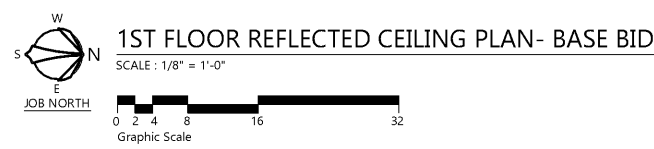

architects inc.
 Montgomery, Alabama

CIP-2017-001
 UPGRADES TO THE MOBILE COUNTY METRO JAIL
 For The MOBILE COUNTY COMMISSION
 MOBILE, ALABAMA

DRAWN: RTS	CHECK: HIG
DATE: April 2, 2019 RTA	
REVISED:	
SHEET TITLE:	REFLECTED CEILING PLAN- SALLY PORT
JOB NO.:	PH&J 1801-GV
SEQUENCE NO.:	44 of 175

A3.0