 

 


Order Plans @

WWW.LDILine.com

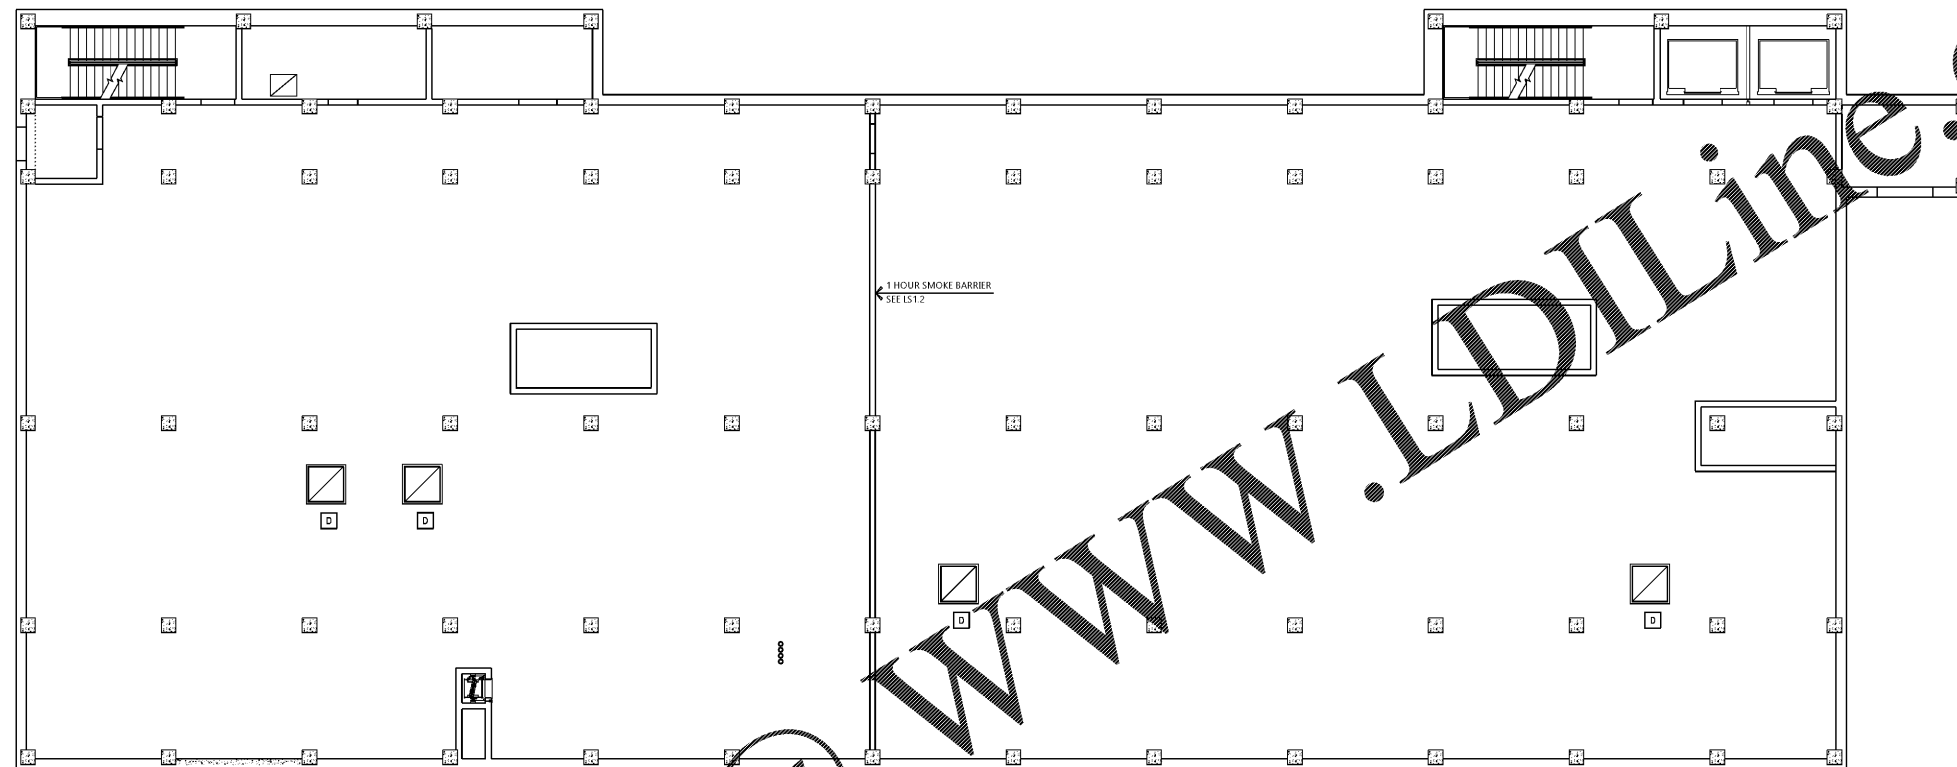


2ND FLOOR REFLECTED CEILING PLAN - ALTERNATE #2



CEILING PLAN LEGEND	
	LIGHT FIXTURES
	HVAC GRILLES
	SECURITY MESH EXHAUST GRILLES SMOKE EVACUATION DUCT OPENING, KITCHEN RETURN AIR AND ETC.
	SECURITY CEILING ACCESS PANEL
	2'x 2' GRID CEILING TRF & GRID - SEE FINISH SCHEDULE FOR TYPE
	SECURITY CEILING (PLANK TYPE) SEE FINISH SCHEDULE
	GYP. BOARD CEILING
	METAL GRATE

NOTE:
1. FINAL POSITIONING OF ACCESS PANELS TO PROVIDE SERVICE ACCESS TO ALL BALANCING DAMPERS, FIRE DAMPERS, EQUIPMENT, VALVE CLEANOUTS, ETC.
2. PROVIDE ADDITIONAL ACCESS PANELS AS REQUIRED TO SERVICE ALL ABOVE ITEMS.
3. SEE DETENTION PLANS FOR CAMERA LOCATIONS AND DURESS STROBES.

CIP-2017-001
UPGRADES TO THE MOBILE COUNTY METRO JAIL
For The MOBILE COUNTY COMMISSION
MOBILE, ALABAMA

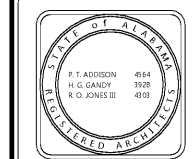

DRAWN	EVRS	CHECK	HG
DATE	April 2, 2019 RTA		
REVISED			
REVISED			


SHEET TITLE
REFLECTED CEILING
PLAN - SECOND FLOOR
ALTERNATE 2

DIB NO.
PH&J 1801-GV

SEQUENCE
NO. 46 of 175

A3.2

PH&J ARCHITECTS, INC.
ALL RIGHTS RESERVED

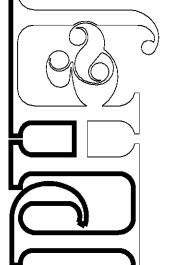

architects inc.
Montgomery, Alabama