



Order Plans @

WWW.LDILine.com

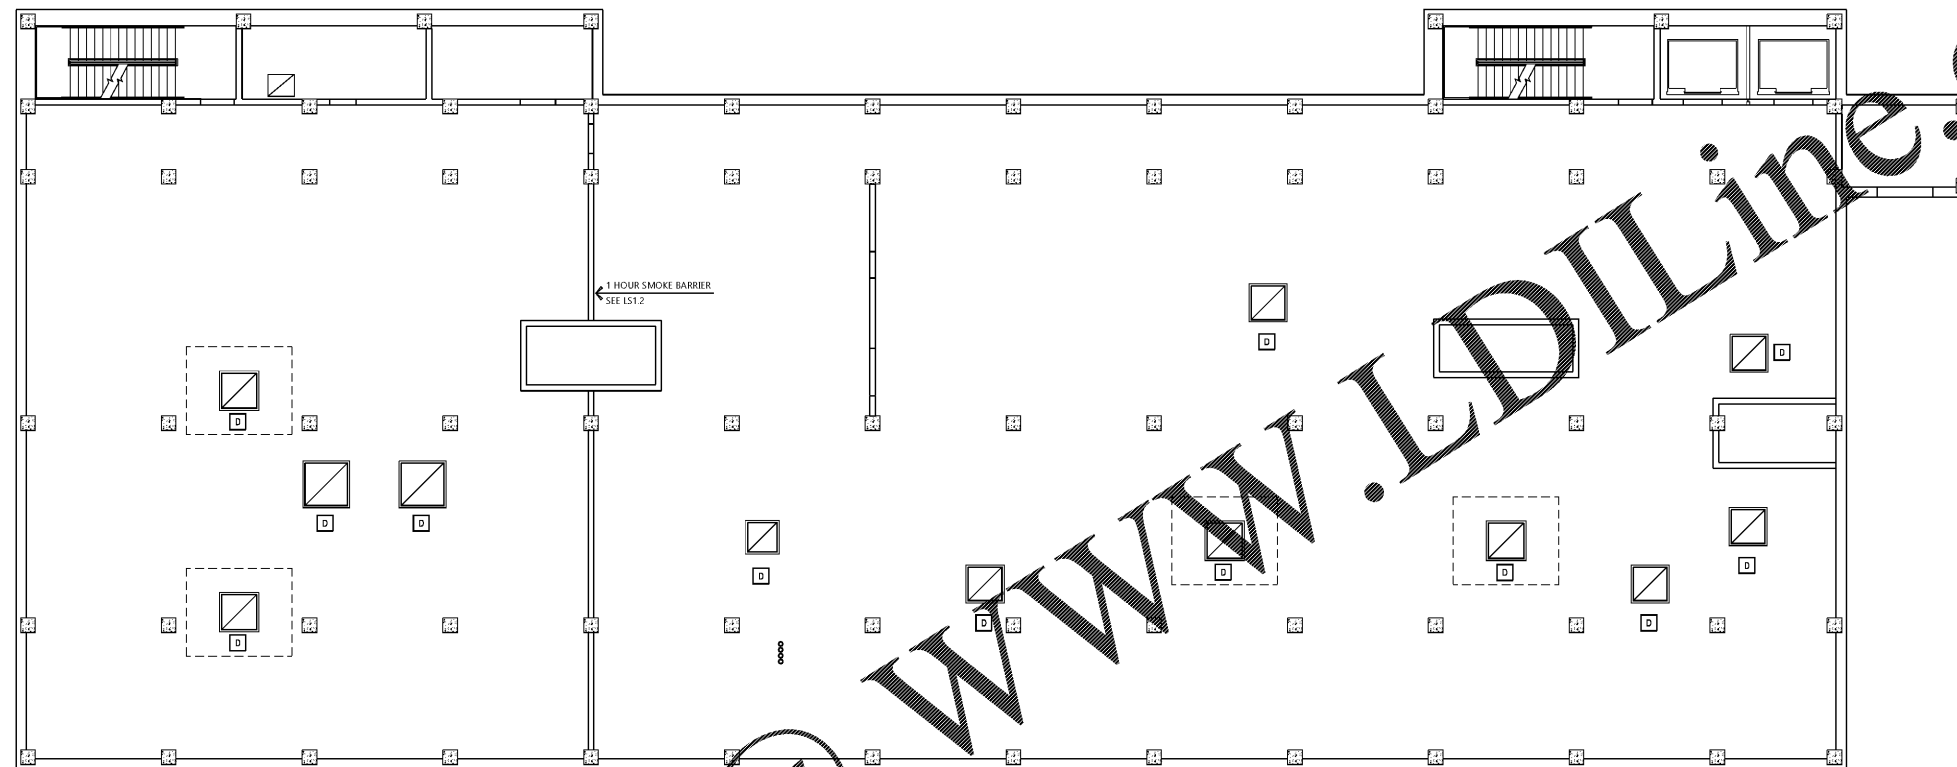

3RD FLOOR REFLECTED CEILING PLAN - ALTERNATE #3

 
SCALE: 1/8"=1'-0"



CEILING PLAN LEGEND	
	LIGHT FIXTURES
	HVAC GRILLES
	SECURITY MESH EXHAUST GRILLES SMOKE EVACUATION DUCT OPENING, KITCHEN RETURN AIR AND ETC.
	SECURITY CEILING ACCESS PANEL
	2x2' ABD CEILING TILE & GRID - SEE FINISH SCHEDULE FOR TYPE
	SECURITY CEILING (PLANK TYPE) SEE FINISH SCHEDULE
	GYP. BOARD CEILING
	METAL GRATE

NOTE:
 1. FINAL POSITIONING OF ACCESS PANELS TO PROVIDE SERVICE ACCESS TO ALL BALANCING DAMPERS, FIRE DAMPERS, EQUIPMENT, VALVE CLEANOUTS, ETC.
 2. PROVIDE ADDITIONAL ACCESS PANELS AS REQUIRED TO SERVICE ALL ABOVE ITEMS.
 3. SEE DETENTION PLANS FOR CAMERA LOCATIONS AND DURESS STROBES

CIP-2017-001
 UPGRADES TO THE MOBILE COUNTY METRO JAIL
 For The MOBILE COUNTY COMMISSION
 MOBILE, ALABAMA

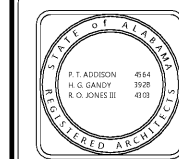

DRAWN BY	CHECK	MS
DATE	April 2, 2019 RTA	
REVISED		
REVISED		


SHEET TITLE
 3RD FLOOR REFLECTED
 CEILING PLAN -
 ALTERNATE 3

JOB NO.
 PH&J 1801-GV

SEQUENCE
 NO. 47 of 175

A3.3

PH&J ARCHITECTS, INC.
 ALL RIGHTS RESERVED

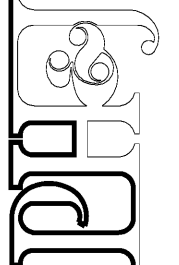

architects inc.
 Montgomery,
 Alabama