


CIP-2017-001  
UPGRADES TO THE MOBILE COUNTY METRO JAIL  
For The MOBILE COUNTY COMMISSION  
MOBILE, ALABAMA

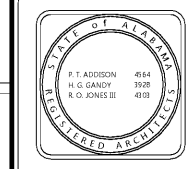

DRAWN	ST	CHECK	HS
DATE	April 2, 2019	RTA	
REVISED	REV		
REVISED	REV		



SHEET TITLE  
ROOF PLAN  
AND DETAILS - BASE BID  
& ALTERNATE 1

JOB NO.  
PH&J 1801-GV

SEQUENCE NO.  
47 of 175

A4.1

PH&J ARCHITECTS, INC.  
ALL RIGHTS RESERVED

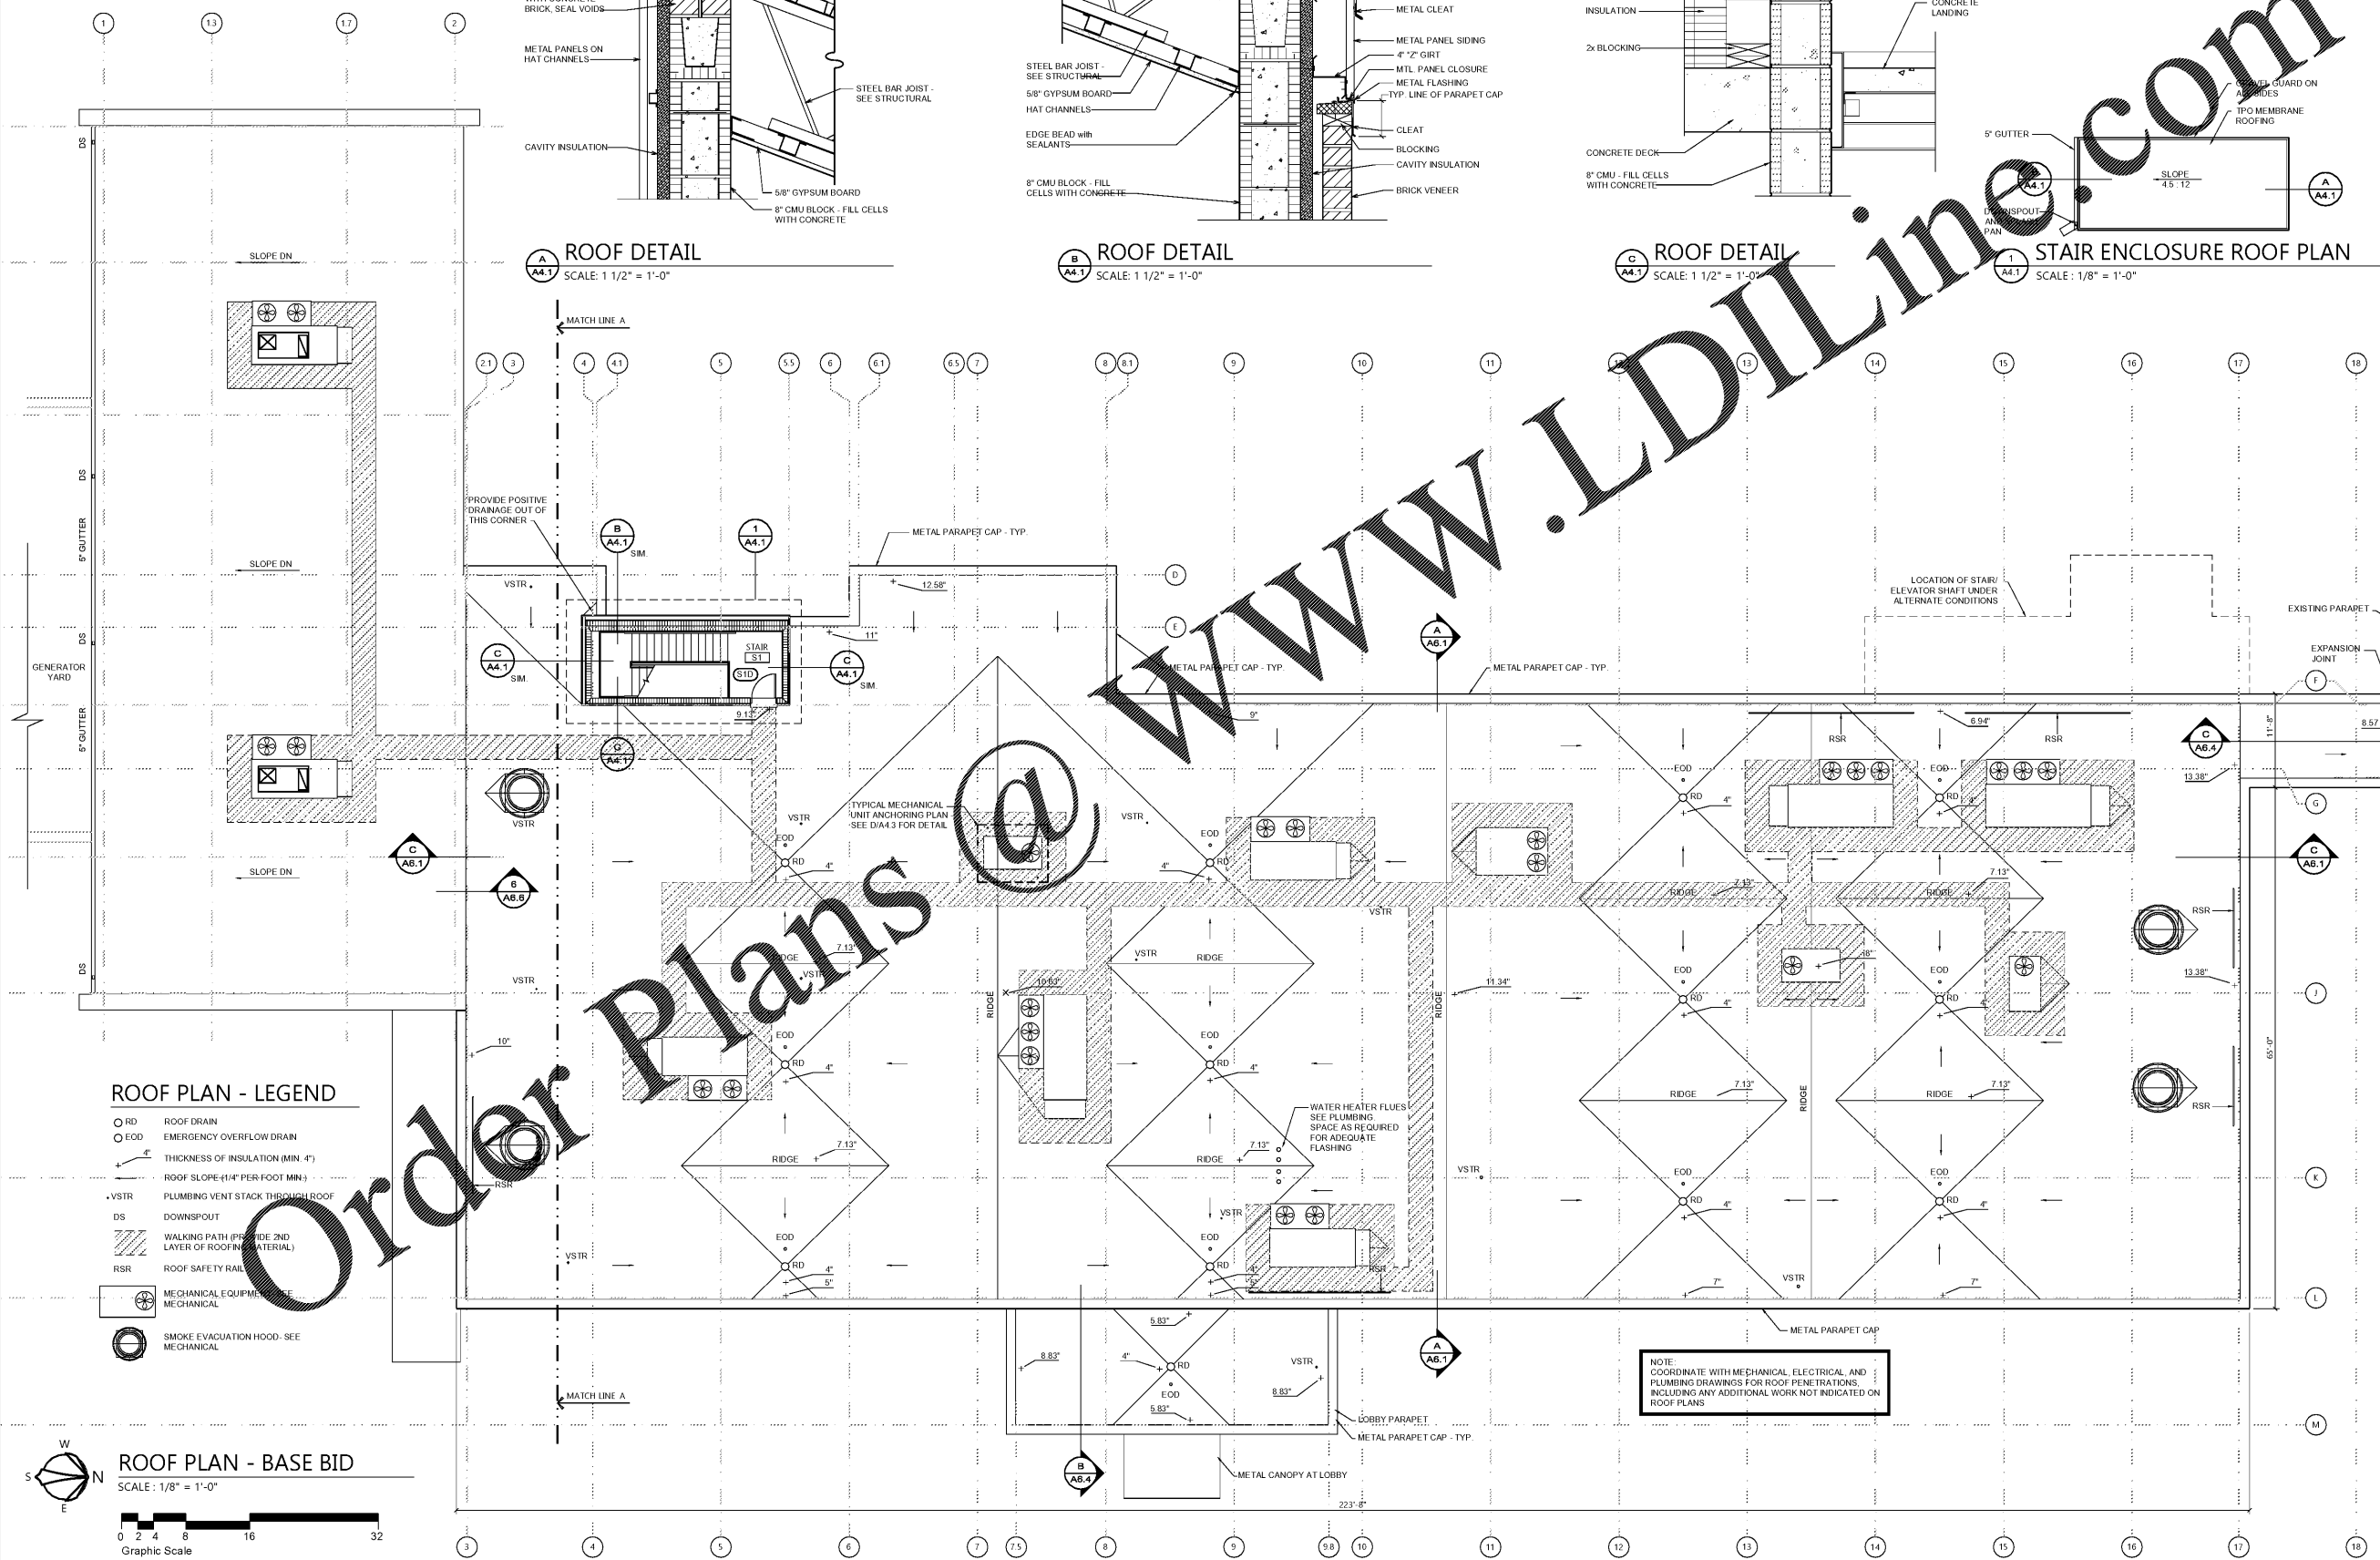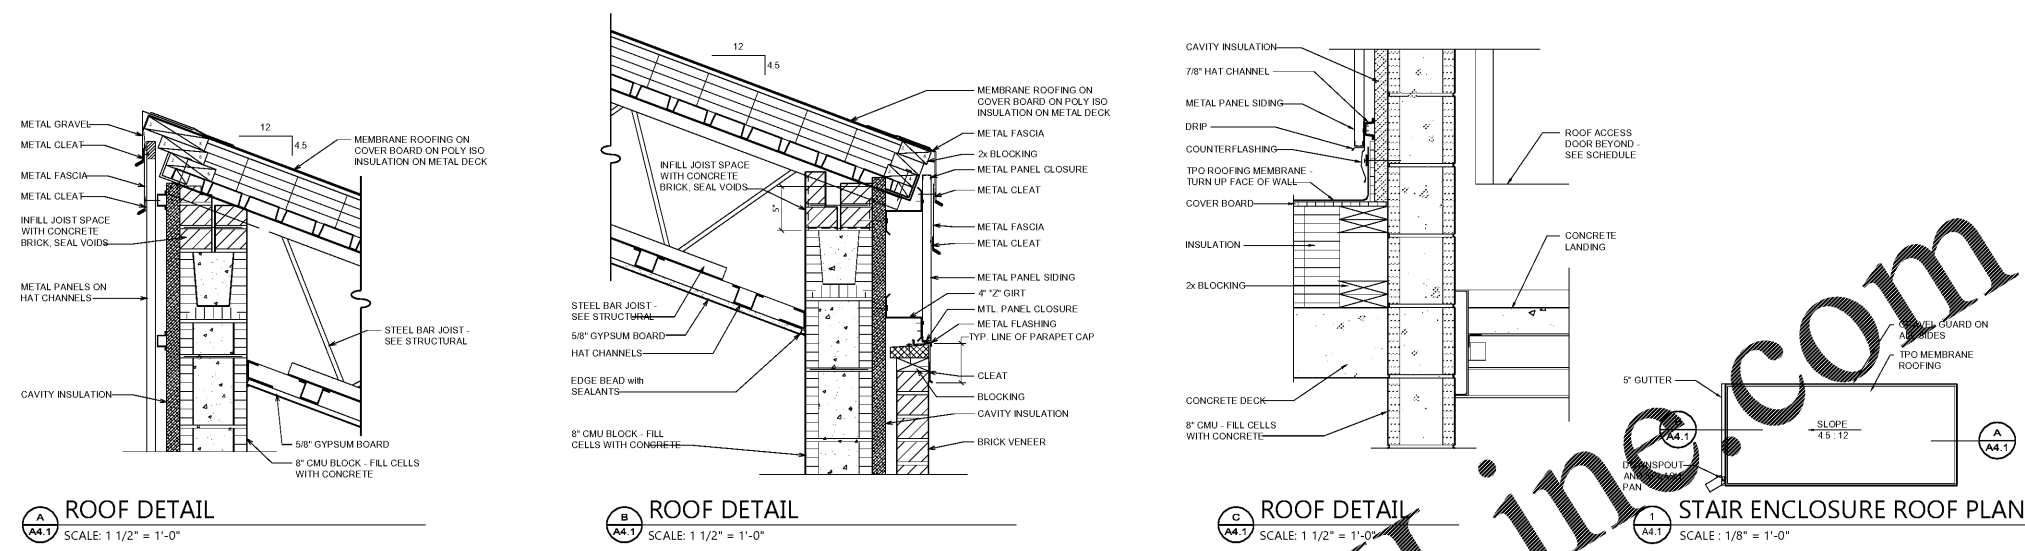


**ROOF PLAN - LEGEND**

- RD ROOF DRAIN
- EOD EMERGENCY OVERFLOW DRAIN
- THICKNESS OF INSULATION (MIN. 4")
- ROOF SLOPE (1/4" PER FOOT MIN.)
- VSTR PLUMBING VENT STACK THROUGH ROOF
- DS DOWNSPOUT
- WALKING PATH (PROVIDE 2ND LAYER OF ROOFING MATERIAL)
- RSR ROOF SAFETY RAIL
- MECHANICAL EQUIPMENT MECHANICAL
- SMOKE EVACUATION HOOD - SEE MECHANICAL

**ROOF PLAN - BASE BID**

 SCALE: 1/8" = 1'-0"



NOTE:  
COORDINATE WITH MECHANICAL, ELECTRICAL, AND PLUMBING DRAWINGS FOR ROOF PENETRATIONS, INCLUDING ANY ADDITIONAL WORK NOT INDICATED ON ROOF PLANS

WWW.LDILine.com

Order Plans @ PH&J