


CIP-2017-001
UPGRADES TO THE MOBILE COUNTY METRO JAIL
FOR THE MOBILE COUNTY COMMISSION
MOBILE, ALABAMA

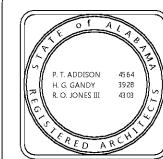

| | | | |
|---------|-------------------|-------|-----|
| DRAWN | ST | CHECK | HS |
| DATE | April 2, 2019 RTA | | |
| REVISED | REV | REV | REV |
| REVISED | REV | REV | REV |


SHEET TITLE
ROOF PLAN
AND DETAILS
ALTERNATE 2 & 3

JOB NO.
PH&J 1801-GV

SEQUENCE
NO. 48 of 175

A4.2

© PH&J ARCHITECTS, INC.
ALL RIGHTS RESERVED

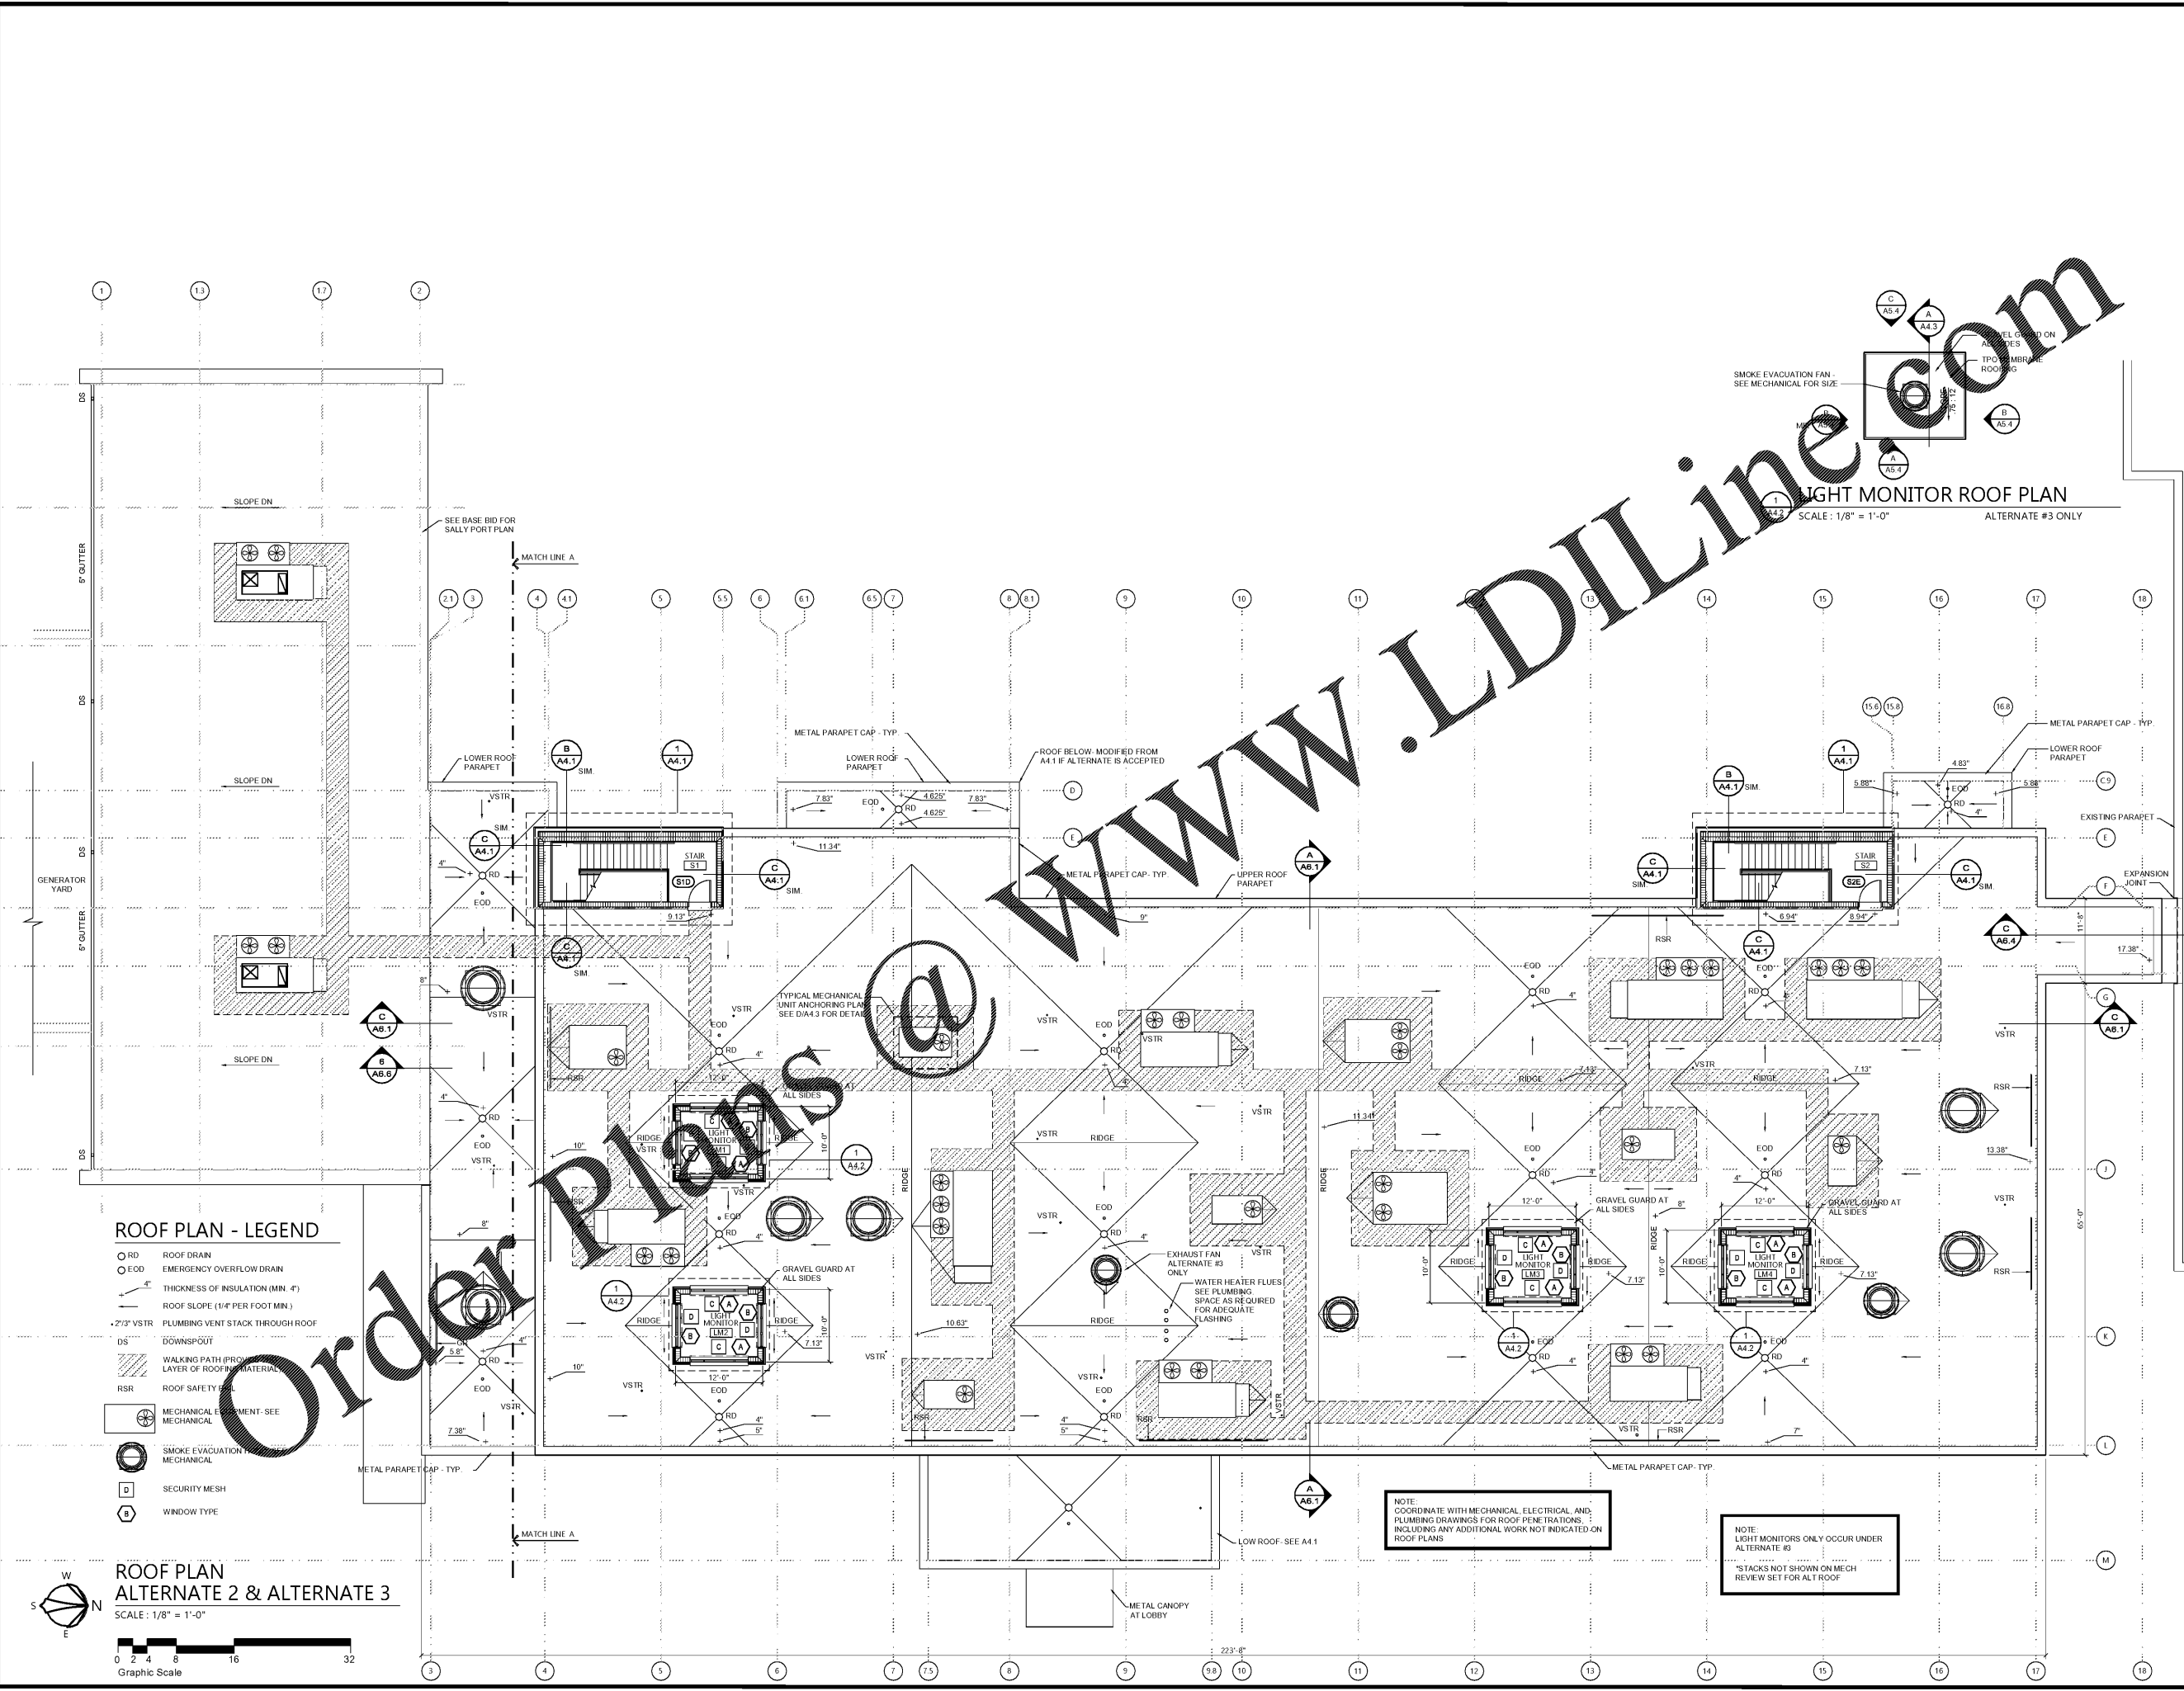

ROOF PLAN - LEGEND

- RD ROOF DRAIN
- EOD EMERGENCY OVERFLOW DRAIN
- 4" THICKNESS OF INSULATION (MIN. 4")
- ROOF SLOPE (1/4" PER FOOT MIN.)
- 2 1/2" VSTR PLUMBING VENT STACK THROUGH ROOF
- DS DOWNSPOUT
- WALKING PATH FROM LOWER LAYER OF ROOF MATERIAL
- RSR ROOF SAFETY
- MECHANICAL ELEMENT - SEE MECHANICAL
- SMOKE EVACUATION MECHANICAL
- D SECURITY MESH
- B WINDOW TYPE

**ROOF PLAN
ALTERNATE 2 & ALTERNATE 3**

SCALE: 1/8" = 1'-0"

Graphic Scale

NOTE:
COORDINATE WITH MECHANICAL, ELECTRICAL, AND PLUMBING DRAWINGS FOR ROOF PENETRATIONS, INCLUDING ANY ADDITIONAL WORK NOT INDICATED ON ROOF PLANS

NOTE:
LIGHT MONITORS ONLY OCCUR UNDER ALTERNATE #3
*STACKS NOT SHOWN ON MECH REVIEW SET FOR ALL ROOF

WWW.LDILine.com

Order Plans