


CIP-2017-001  
UPGRADES TO THE MOBILE COUNTY METRO JAIL  
For The MOBILE COUNTY COMMISSION  
MOBILE, ALABAMA




DRAWN	RTS	CHECK	HS
DATE	April 2, 2019 RTA		
REVISED			
REVISED			
SHEET TITLE			
WALL SECTIONS AND DETAILS			
JOB NO.	PH&J 1801-GV		
SEQUENCE NO.	60	OF	175

A6.5


PH&J ARCHITECTS, INC.  
ALL RIGHTS RESERVED

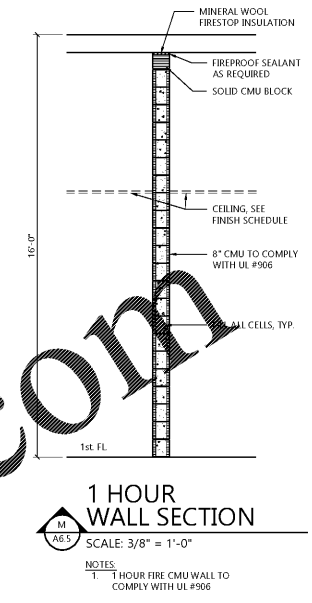


1 HOUR WALL SECTION  
SCALE: 3/8" = 1'-0"  
NOTES:  
1 HOUR FIRE CMU WALL TO COMPLY WITH UL #906

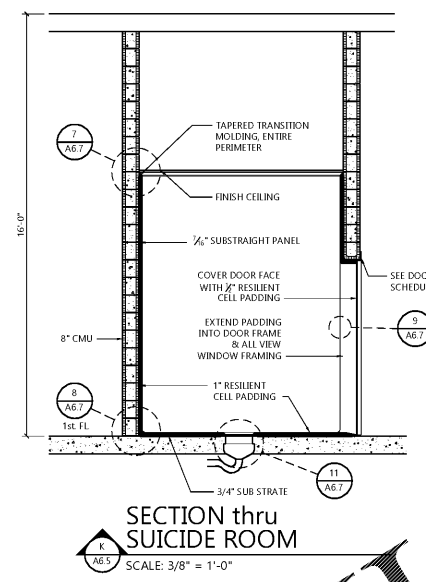


SECTION thru SUICIDE ROOM  
SCALE: 3/8" = 1'-0"

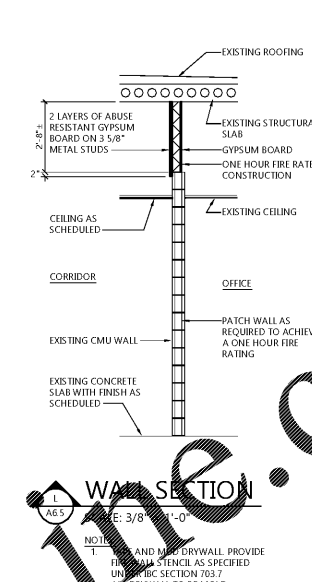


WALL SECTION  
SCALE: 3/8" = 1'-0"  
NOTES:  
1 AND MORE DRYWALL PROVIDE FIRE RATING STENCIL AS SPECIFIED IN PH&J SECTION 203.2. ALL DRYWALL TO BE MOLD RESISTANT

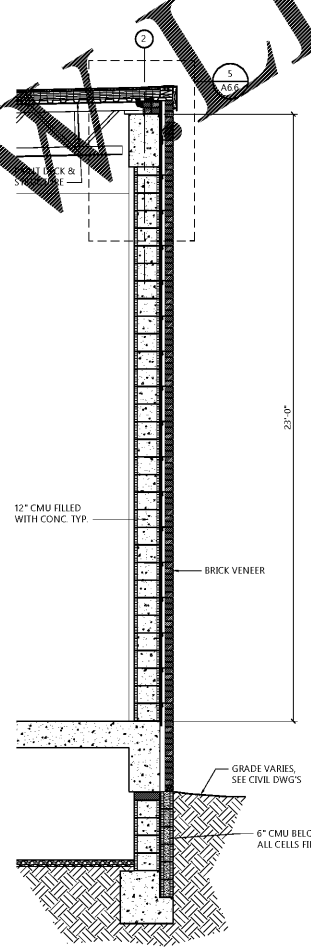


WALL SECTION at SALLYPORT  
SCALE: 3/8" = 1'-0"

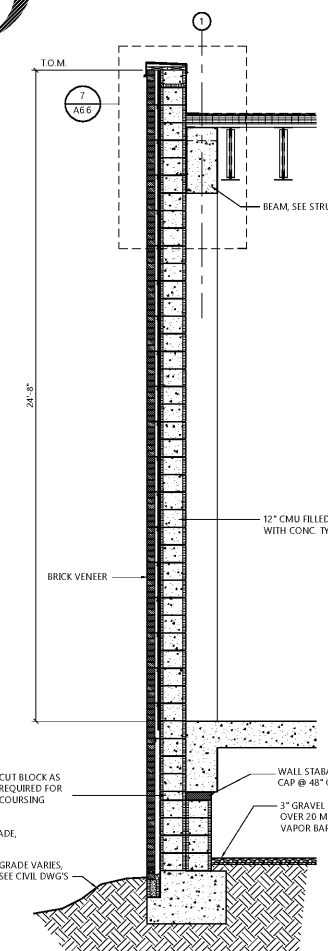


END WALL SECTION at SALLYPORT  
SCALE: 3/8" = 1'-0"

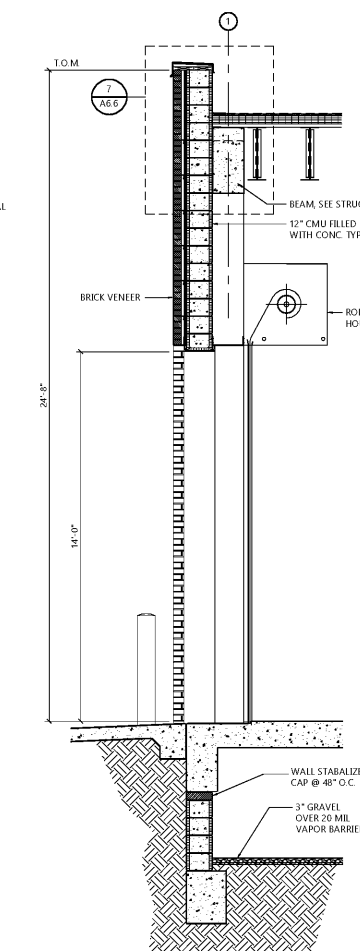


ROLL-UP DOOR SECTION at SALLYPORT  
SCALE: 3/8" = 1'-0"

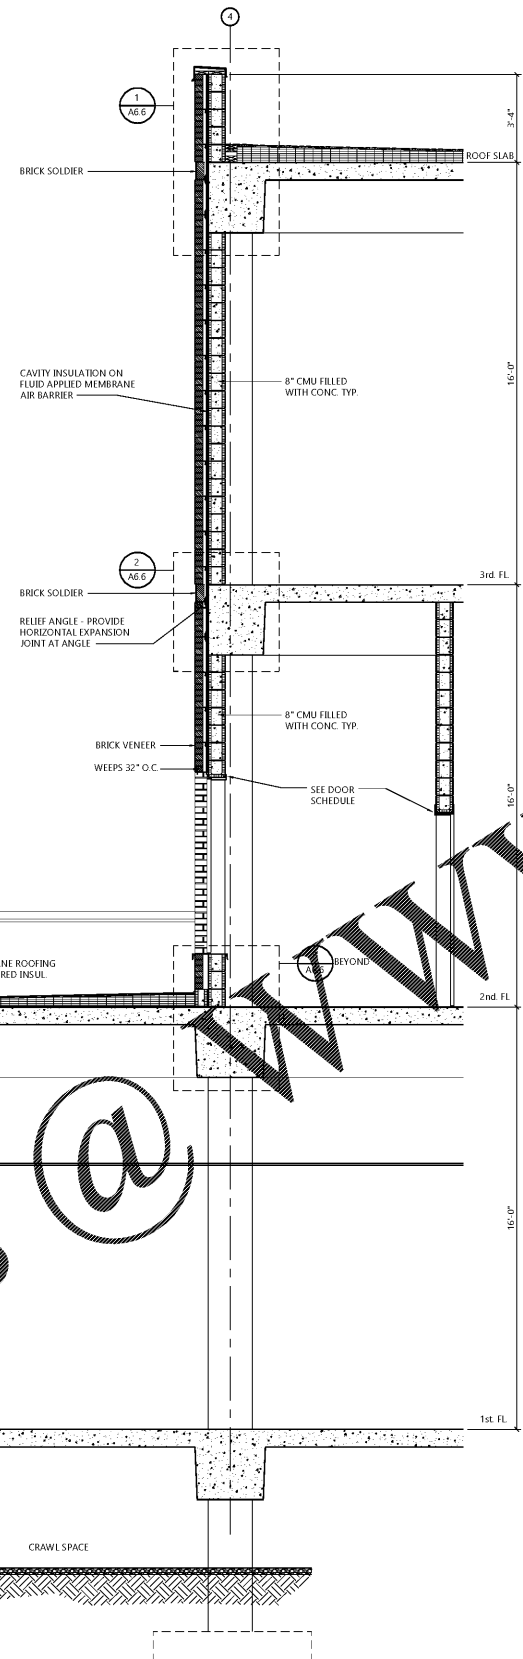

WALL SECTION at SALLYPORT  
SCALE: 3/8" = 1'-0"

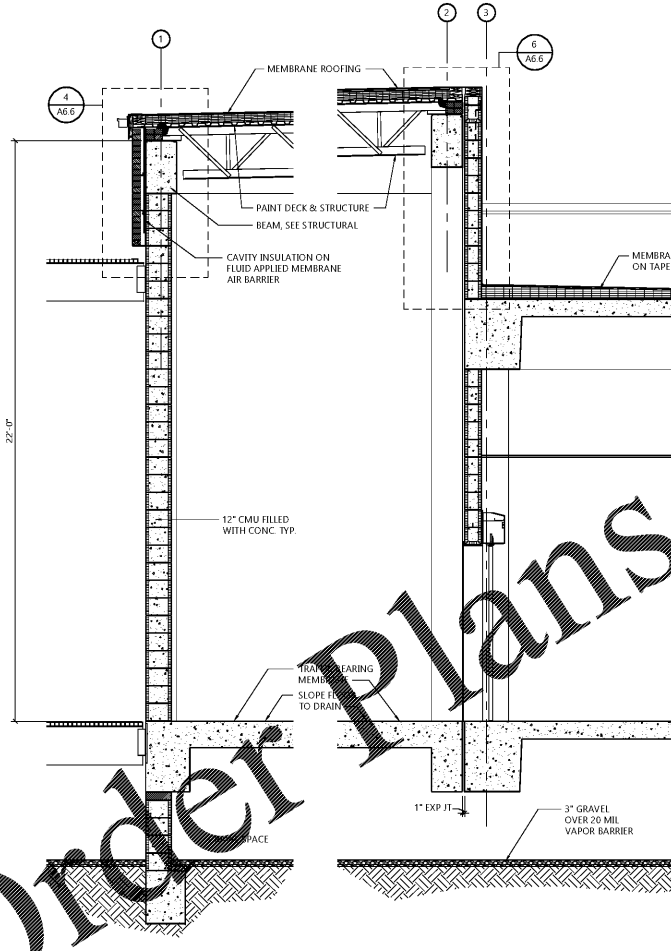

WALL SECTION at SALLYPORT  
SCALE: 3/8" = 1'-0"

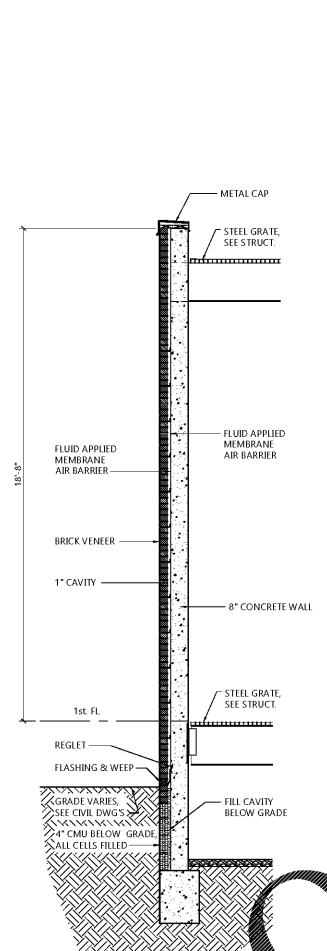

MECHANICAL YARD WALL  
SCALE: 3/8" = 1'-0"

NOTE: ALL WALL SECTIONS ARE SHOWN WITH BASE BID AND ALTERNATES 1 & 2