

SECURITY LEGEND

NOTE:
ALL 8" CMU WALL ALL CELLS FILLED WITH
CONCRETE REINFORCED WITH #4 BARS
16" O.C.

- BC-1 DURESS BUTTON
CONTROL PANEL WHERE ALARM SOUNDS
- DURESS STROBE


SYMBOL LEGEND

- MASTER STATION LOCATION 1
- INTERCOM STATION
- SECONDARY STATION LOCATION 2
- DIRECT COMMUNICATION PORTAL
- EQUIPMENT IDENTIFIER

DETENTION EQUIPMENT SCHEDULE


- A PISTOL LOCKER
- B TOWEL HOOK
- C 8" 0" BENCH
- D 6" 0" BENCH
- E 4" 0" BENCH
- F SECURITY MIRROR (LONG)
- G MODESTY WC PANEL
- H 24" GRAB BAR
- I 30" GRAB BAR
- J 42" GRAB BAR
- K INMATE PROPERTY PASS
- L INMATE SPEAKING PORT
- M INMATE TRANSACTION COUNTER DEAL TRAY
- N PUBLIC TRANSACTION COUNTER (NON-RICOCHET)
- O ADJUSTABLE ELECTRIC STAND/SIT TABLE
- P THERMOSTAT, HUMIDISTAT AND CARBON MONOXIDE BOX
- Q SECURITY CEILING ACCESS DOOR/PANEL
- R SECURITY GRILLES IN DUCTS
- S DIRECT COMMUNICATION PORTAL

NOTE:
SEE DIVISION 11 OF SPECIFICATIONS FOR ADDITIONAL EQUIPMENT
SCHEDULED, DETAILED AND SPECIFIED BUT NOT SHOWN HERE.

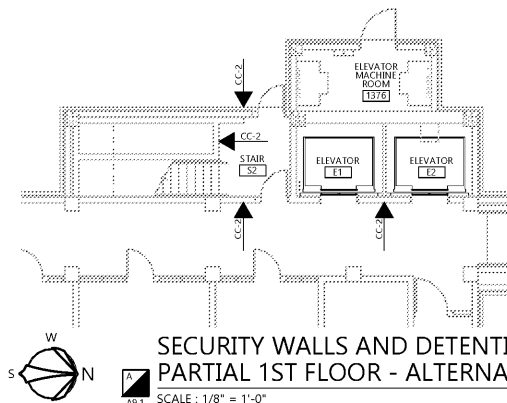

**SECURITY WALLS AND DETENTION EQUIPMENT
PARTIAL 1ST FLOOR - ALTERNATE 2**


SCALE: 1/8" = 1'-0"

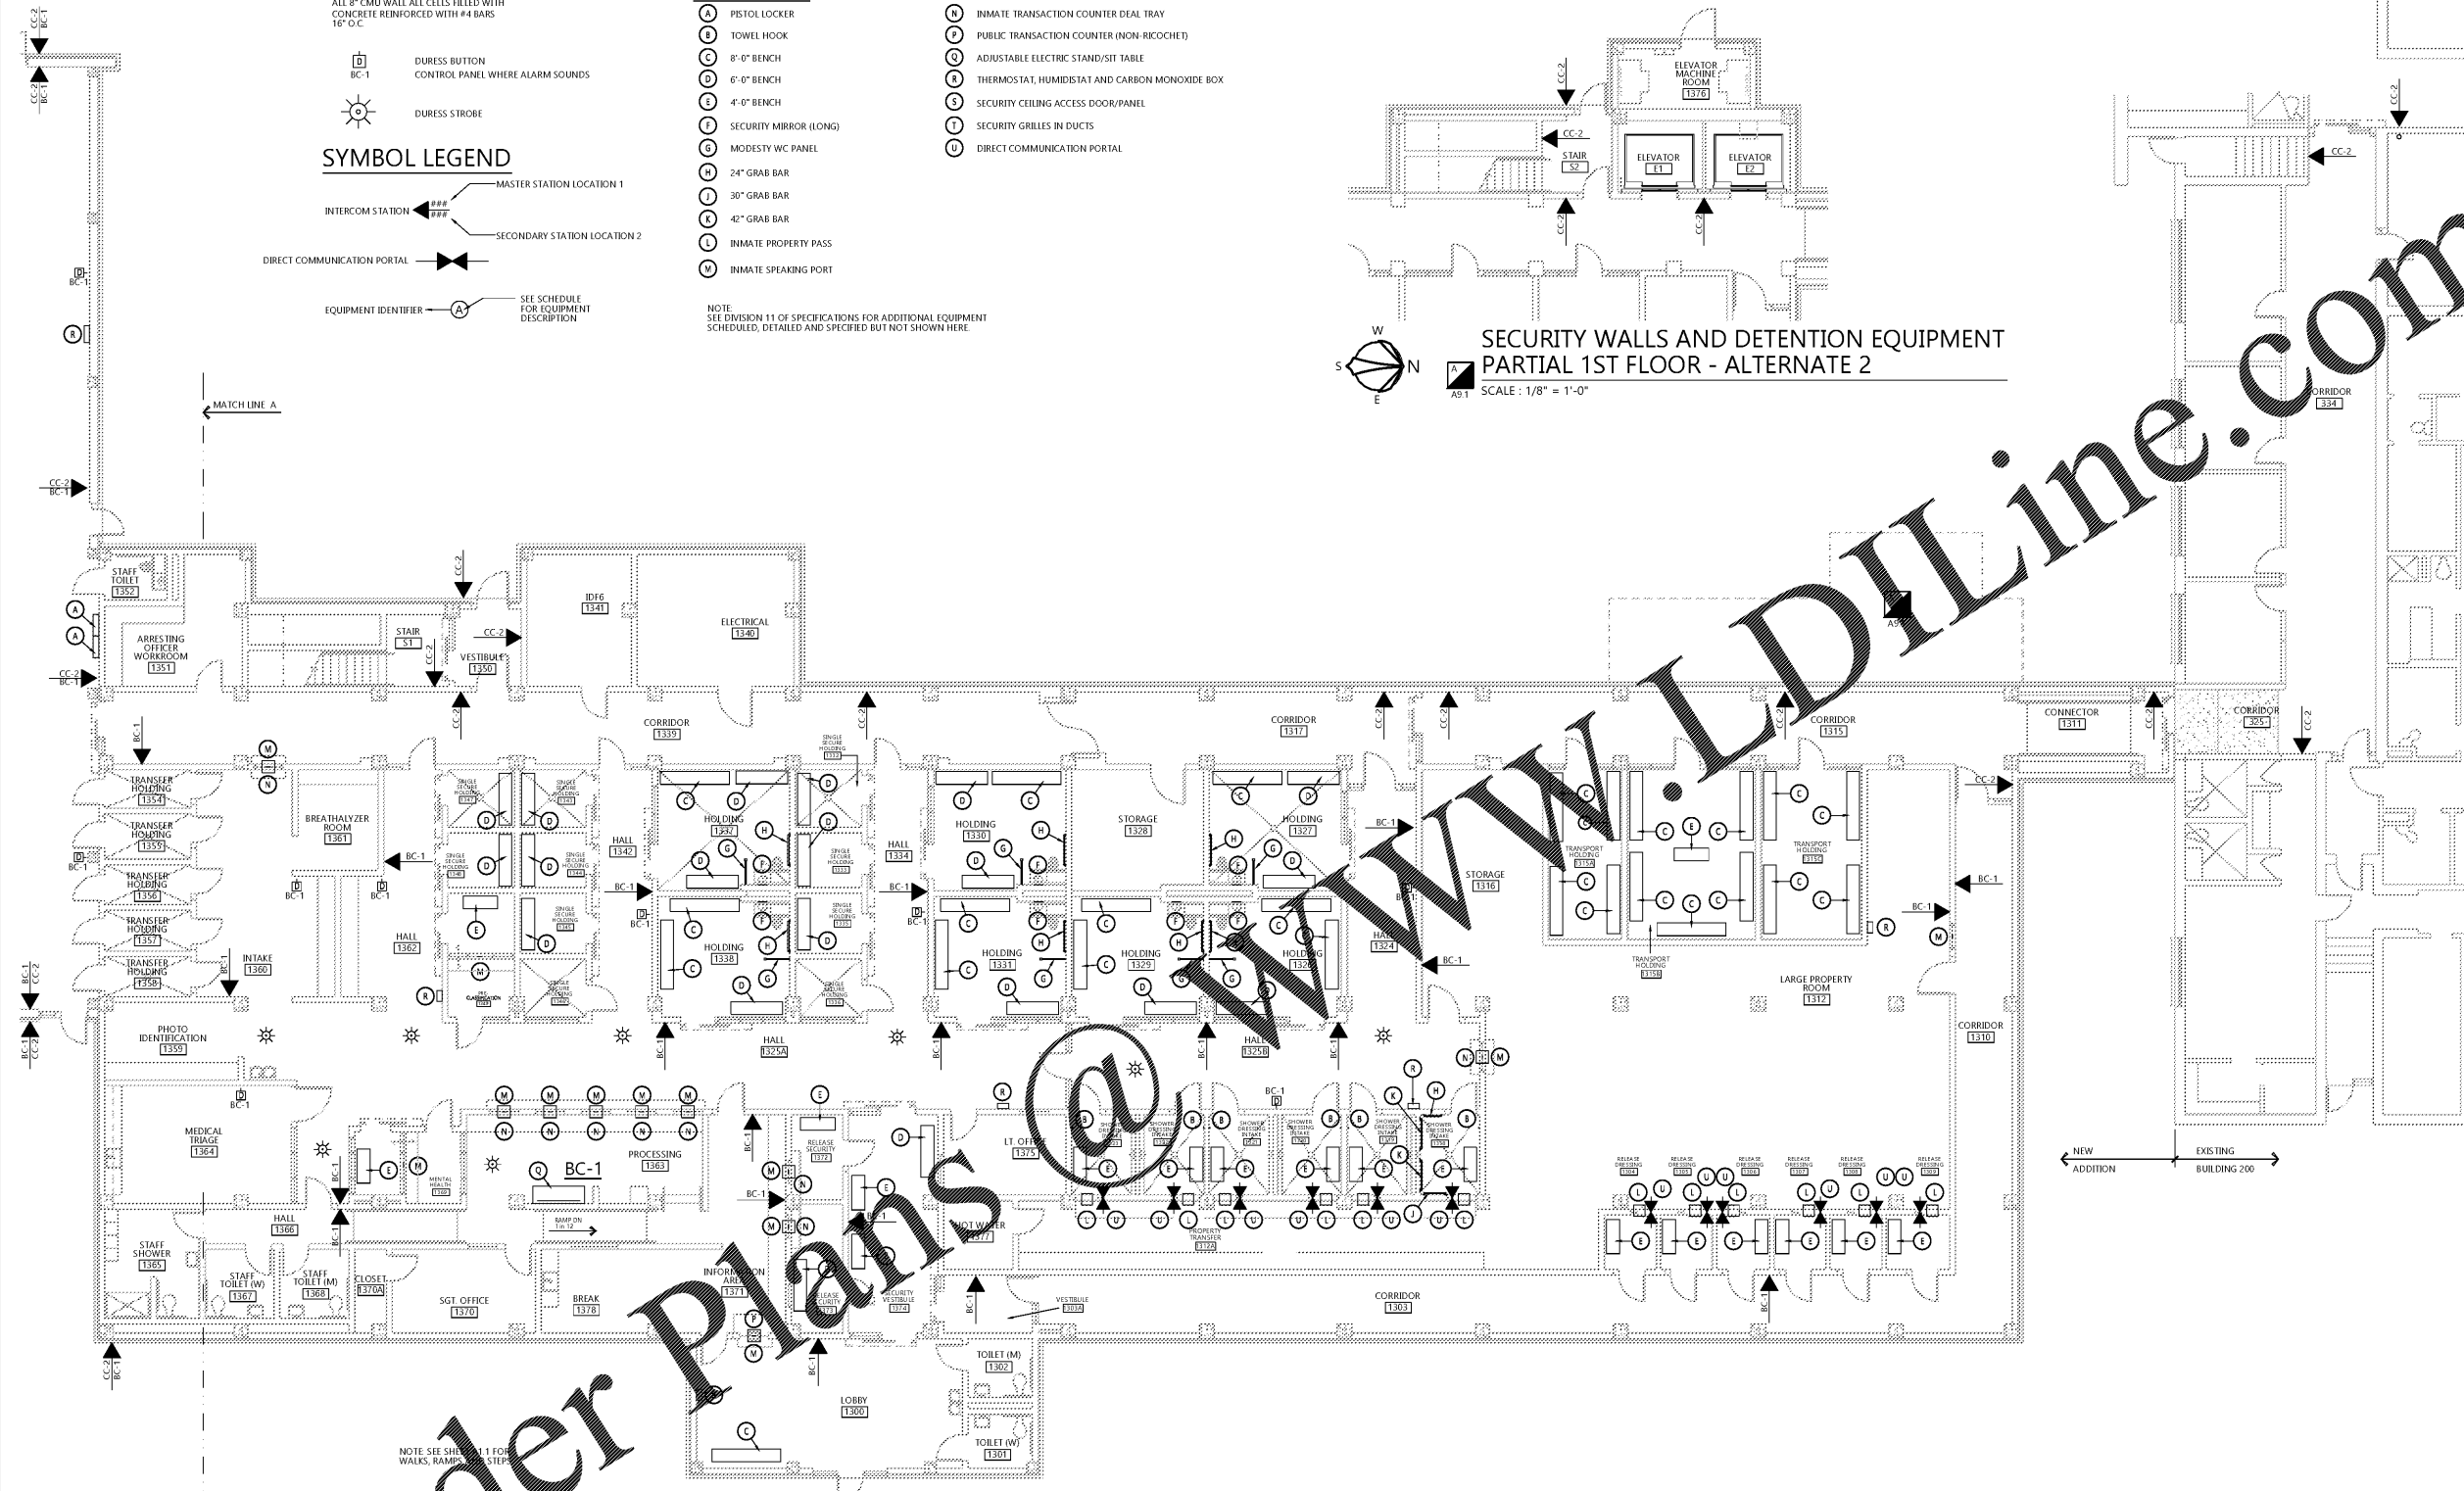

Order Plans @ WWW.DIline.com


**SECURITY WALLS AND DETENTION EQUIPMENT
1ST FLOOR - BASE BID**

 SCALE: 1/8" = 1'-0" FIN FLOOR ELEV = 14'-0"



PH&J architects inc.
 Montgomery, Alabama

CIP-2017-081
 UPGRADES TO THE MOBILE COUNTY METRO JAIL
 FOR THE MOBILE COUNTY COMMISSION
 MOBILE, ALABAMA

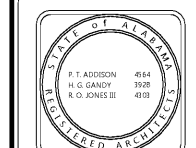

DRAWN	KURTS	CHECK	PA
DATE	10/27/2017	REVISION	
REVISED		REVISED	

SHEET TITLE	DETENTION EQUIPMENT 1ST FLOOR PLAN - BASE BID
JOB NO.	1715
SEQUENCE NO.	69 of 175

A9.1

© PH&J ARCHITECTS, INC.
ALL RIGHTS RESERVED