


Order Plans @

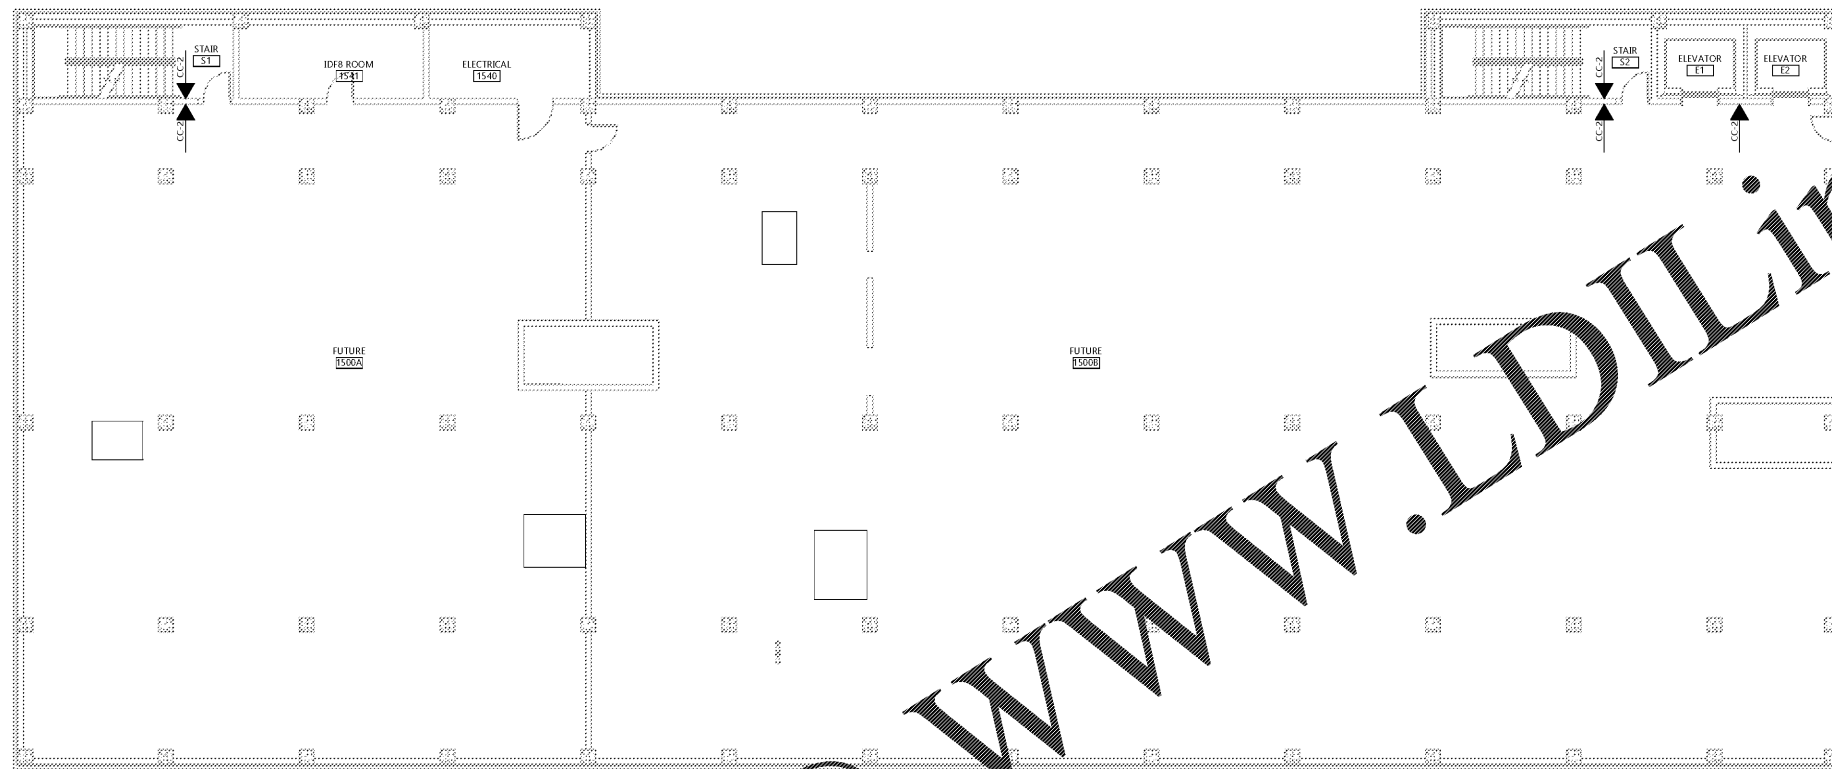

SECURITY WALLS AND DETENTION EQUIPMENT
 3RD FLOOR - ALTERNATE #3
 SCALE: 1/8" = 1'-0" FIN FLOOR ELEV = 10'-0"
 0 2 4 8 16 24 32
 Graphic Scale

SECURITY LEGEND

NOTE:
 ALL 8" CMU WALL ALL CELLS FILLED WITH
 CONCRETE REINFORCED WITH #4 BARS
 16" O.C.

BC-1 DURESS BUTTON
 CONTROL PANEL WHERE ALARM SOUNDS

DURESS STROBE

SYMBOL LEGEND

INTERCOM STATION
 DIRECT COMMUNICATION PORTAL
 EQUIPMENT IDENTIFIER


MASTER STATION LOCATION 1
 SECONDARY STATION LOCATION 2
 SEE SCHEDULE FOR EQUIPMENT DESCRIPTION

DETENTION EQUIPMENT SCHEDULE

- A PISTOL LOCKER
- B TOWEL HOOK
- C 8'-0" BENCH
- D 6'-0" BENCH
- E 4'-0" BENCH
- F SECURITY MIRROR (LONG)
- G MODESTY WC PANEL
- H 24" GRAB BAR
- I 30" GRAB BAR
- J 42" GRAB BAR
- K INMATE PROPERTY PASS
- L INMATE SPEAKING PORT
- M INMATE TRANSACTION COUNTER DEAL TRAY
- N PUBLIC TRANSACTION COUNTER (NON-RICOCHET)
- O ADJUSTABLE ELECTRIC STAND/SIT TABLE
- P THERMOSTAT, HUMIDISTAT AND CARBON MONOXIDE BOX
- Q SECURITY CEILING ACCESS DOOR/PANEL
- R SECURITY GRILLES IN DUCTS
- S DIRECT COMMUNICATION PORTAL

NOTE:
 SEE DIVISION 11 OF SPECIFICATIONS FOR ADDITIONAL EQUIPMENT
 SCHEDULED, DETAILED AND SPECIFIED BUT NOT SHOWN HERE.


CIP-2017-001
 UPGRADES TO THE MOBILE COUNTY METRO JAIL
 For The MOBILE COUNTY COMMISSION
 MOBILE, ALABAMA

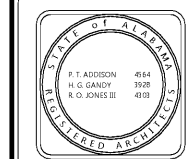

DRAWN	RTS/ER	CHECK	RA
DATE	April 2, 2019 RTA		
REVISED			
REVISED			

SHEET TITLE	
DETENTION EQUIPMENT 3rd Floor Plan - Alternate 2	
JOB NO.	PH&J 1801-GV
SEQUENCE NO.	71 of 175

A9.3
 PH&J ARCHITECTS, INC.
 ALL RIGHTS RESERVED

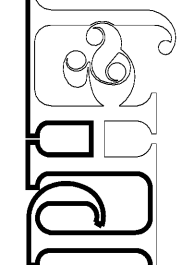

architects inc.
 Montgomery, Alabama

WWW.LDILine.com