

CIP-2017-001
UPGRADES TO THE MOBILE COUNTY METRO JAIL
FOR THE MOBILE COUNTY COMMISSION
MOBILE, ALABAMA



DRAWN	RTS	CHECK	PA
DATE	April 2, 2019 RTA		
REVISED			
REVISED			




SHEET TITLE
Camera Layout -
1st Floor Plan - Base Bid

JOB NO.
PH&J 1801-GV

SEQUENCE
No. 76 of 175

A9.8

PH&J ARCHITECTS, INC.
ALL RIGHTS RESERVED

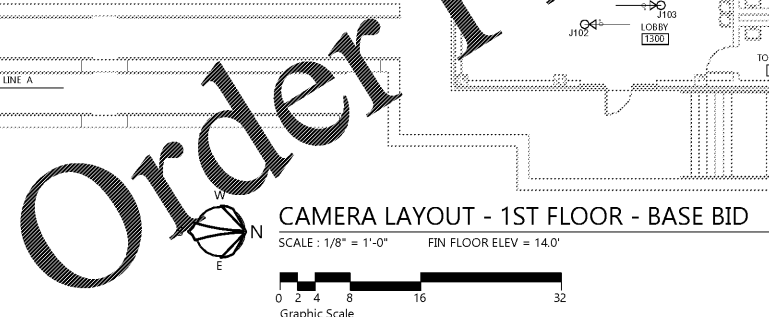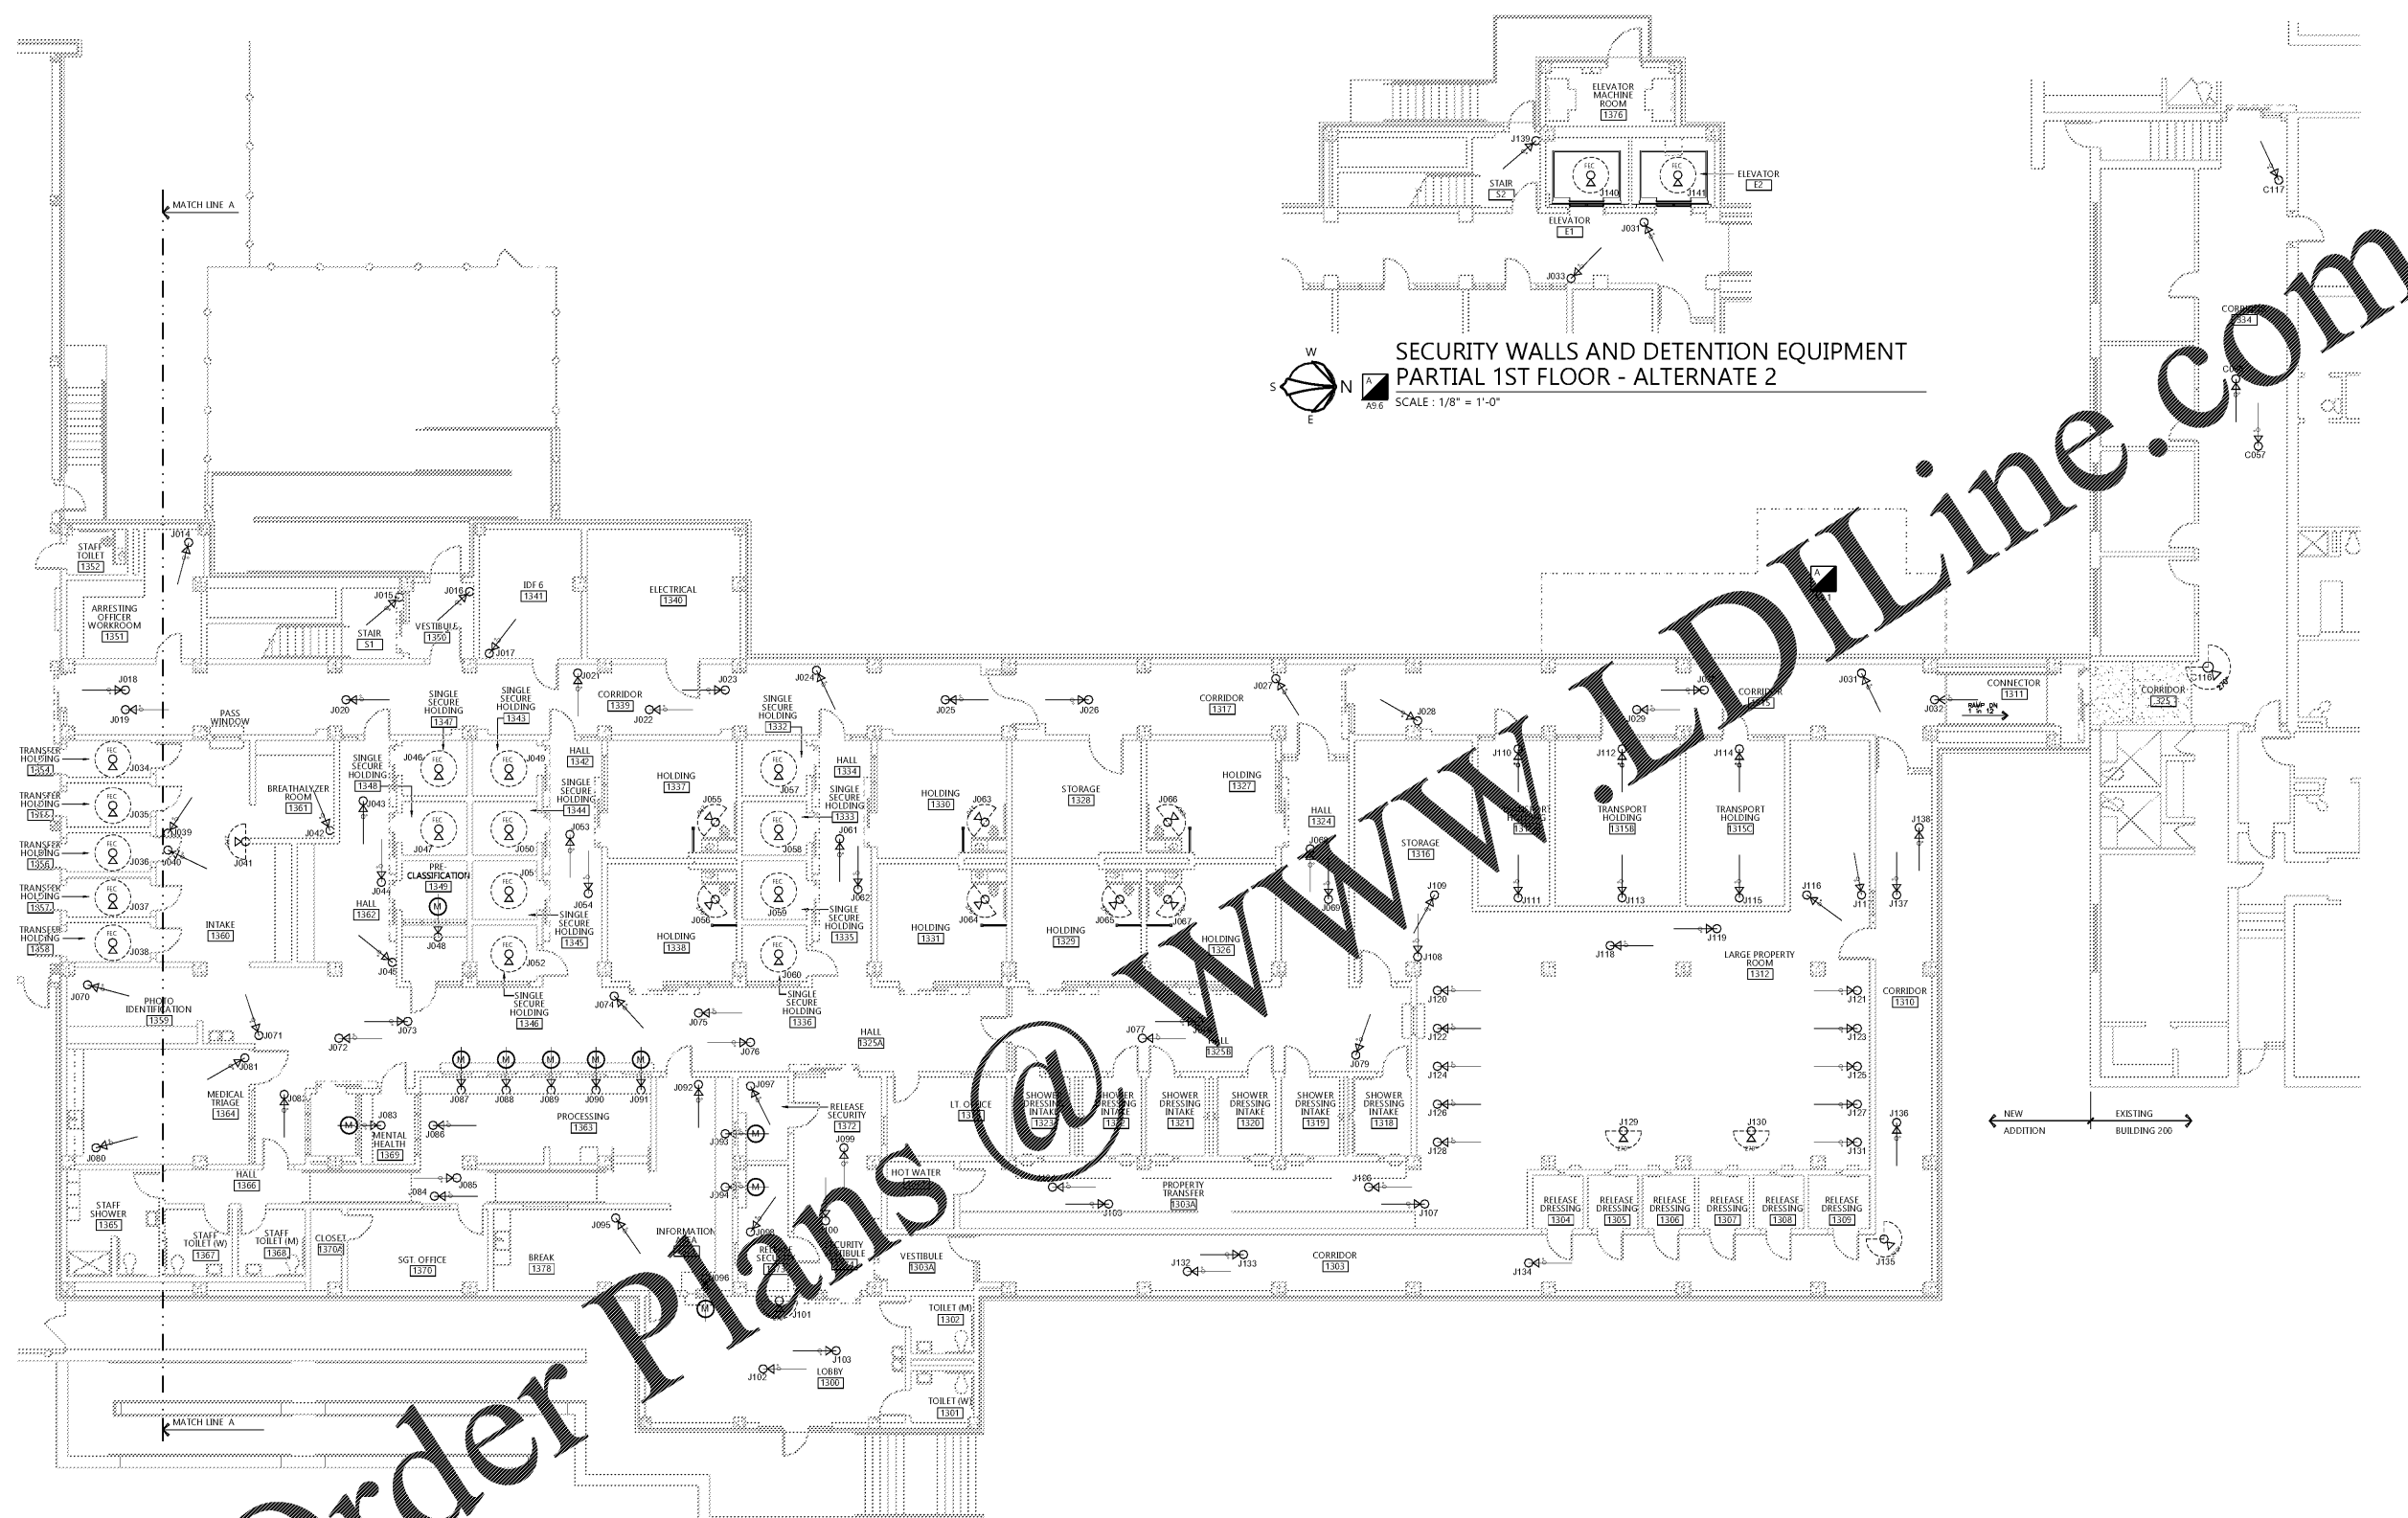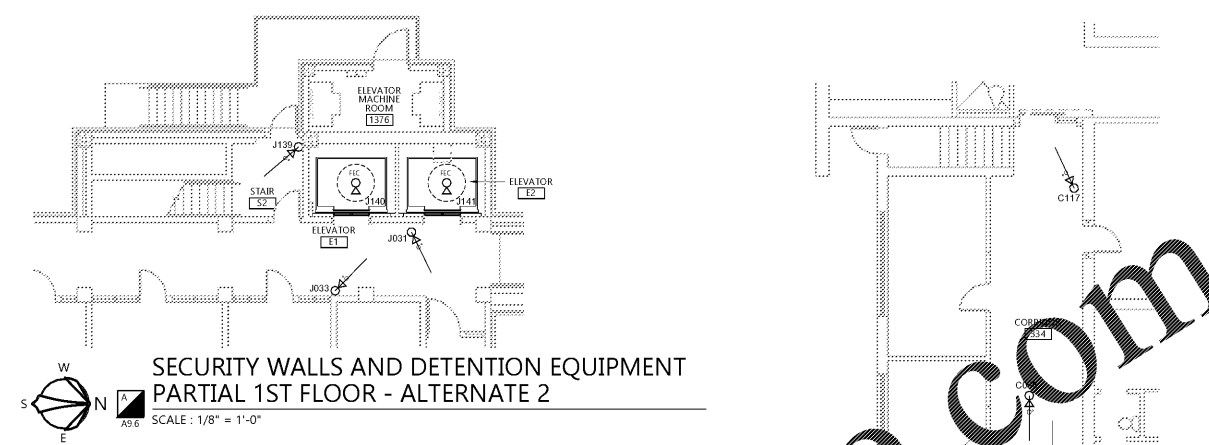

SYMBOL LEGEND

CCTV CAMERA		DIRECTIONAL CAMERA		REMOTE MICROPHONE FOR AUDIO RECORDING (LINKED W/ CAMERA) CEILING MOUNTED	
CCTV CAMERA		PAN, TILT, ZOOM FUNCTION			
CCTV CAMERA		270° CAMERA			
CCTV CAMERA		FISH EYE CAMERA			