
 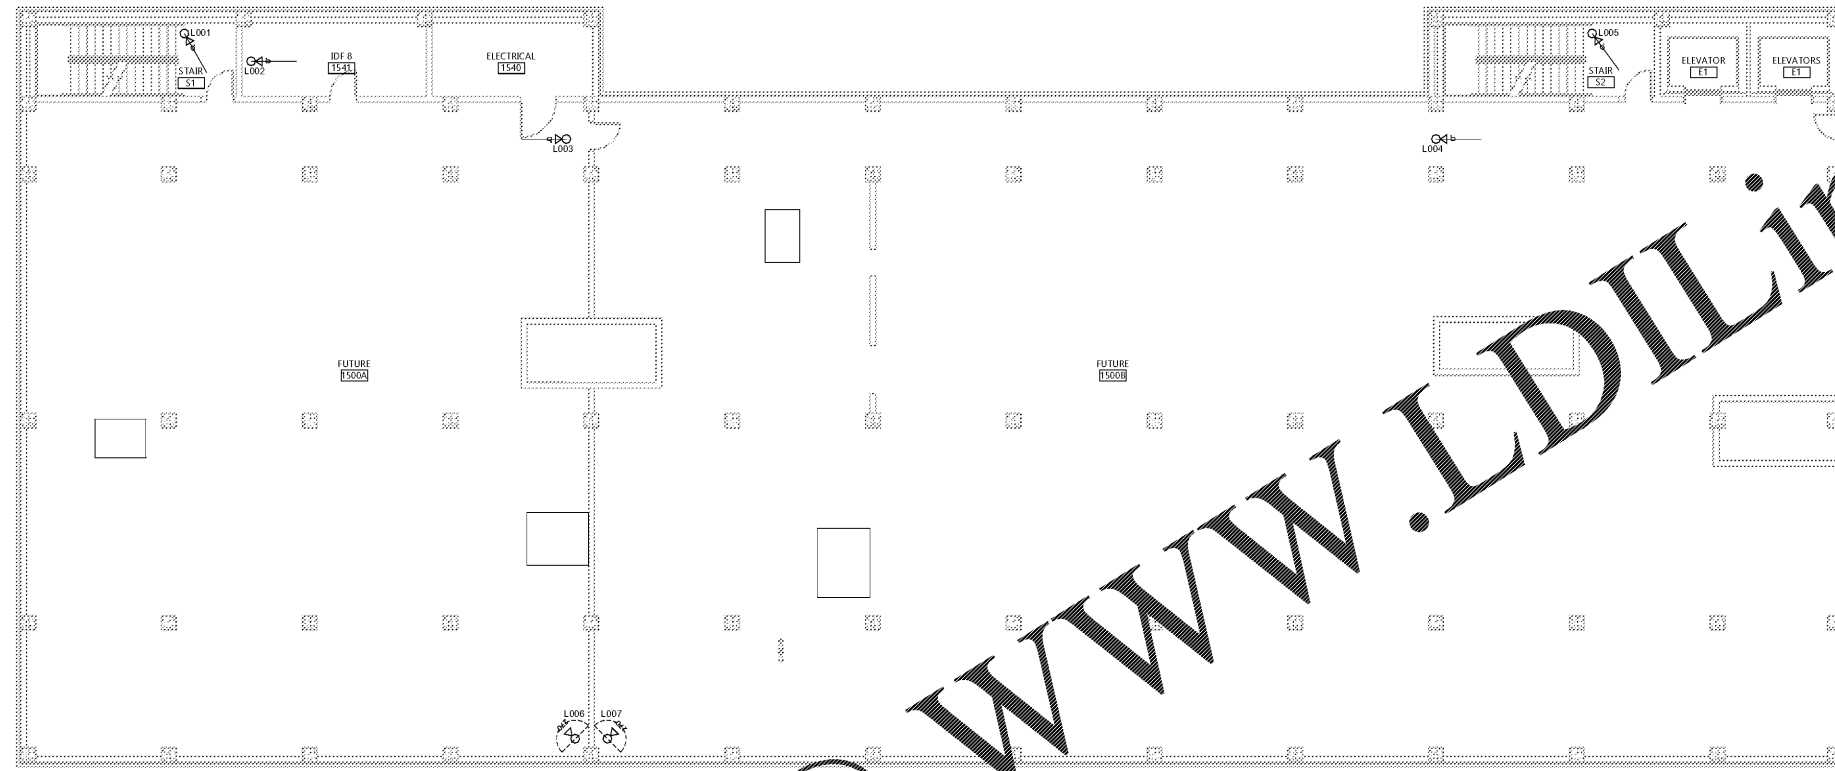



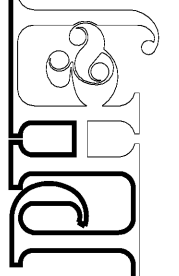
Order Plans @

WWW.LDILine.com





**CAMERA LAYOUT -**  
**3RD FLOOR - ALTERNATE #3**  
 SCALE: 1/8" = 1'-0" FIN FLOOR ELEV =   

 0 2 4 8 16 32  
 Graphic Scale  
**SYMBOL LEGEND**  
 CCTV CAMERA      DIRECTIONAL CAMERA  
 CAMERA      PAN, TILT, ZOOM FUNCTION  
 TV CAMERA      270° CAMERA  
 CCTV CAMERA      FISH EYE CAMERA

architects inc.  
 Montgomery, Alabama

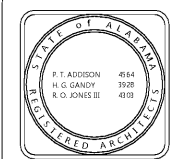

CIP-2017-001  
 UPGRADES TO THE MOBILE COUNTY METRO JAIL  
 For The MOBILE COUNTY COMMISSION  
 MOBILE, ALABAMA



DRAWN	RIS	CHECK	RA
DATE	April 2, 2019 RTA		
REVISED			
REVISED			

SHEET TITLE  
 Camera Layout -  
 3rd Floor Plan -  
 Alternate 3  
 JOB NO.  
 PH&J 1801-GV  
 SEQUENCE  
 NO. 78 of 175

A9.10

PH&J ARCHITECTS, INC.  
 ALL RIGHTS RESERVED