
 


Order Plans @

WWW.LDILINE.COM

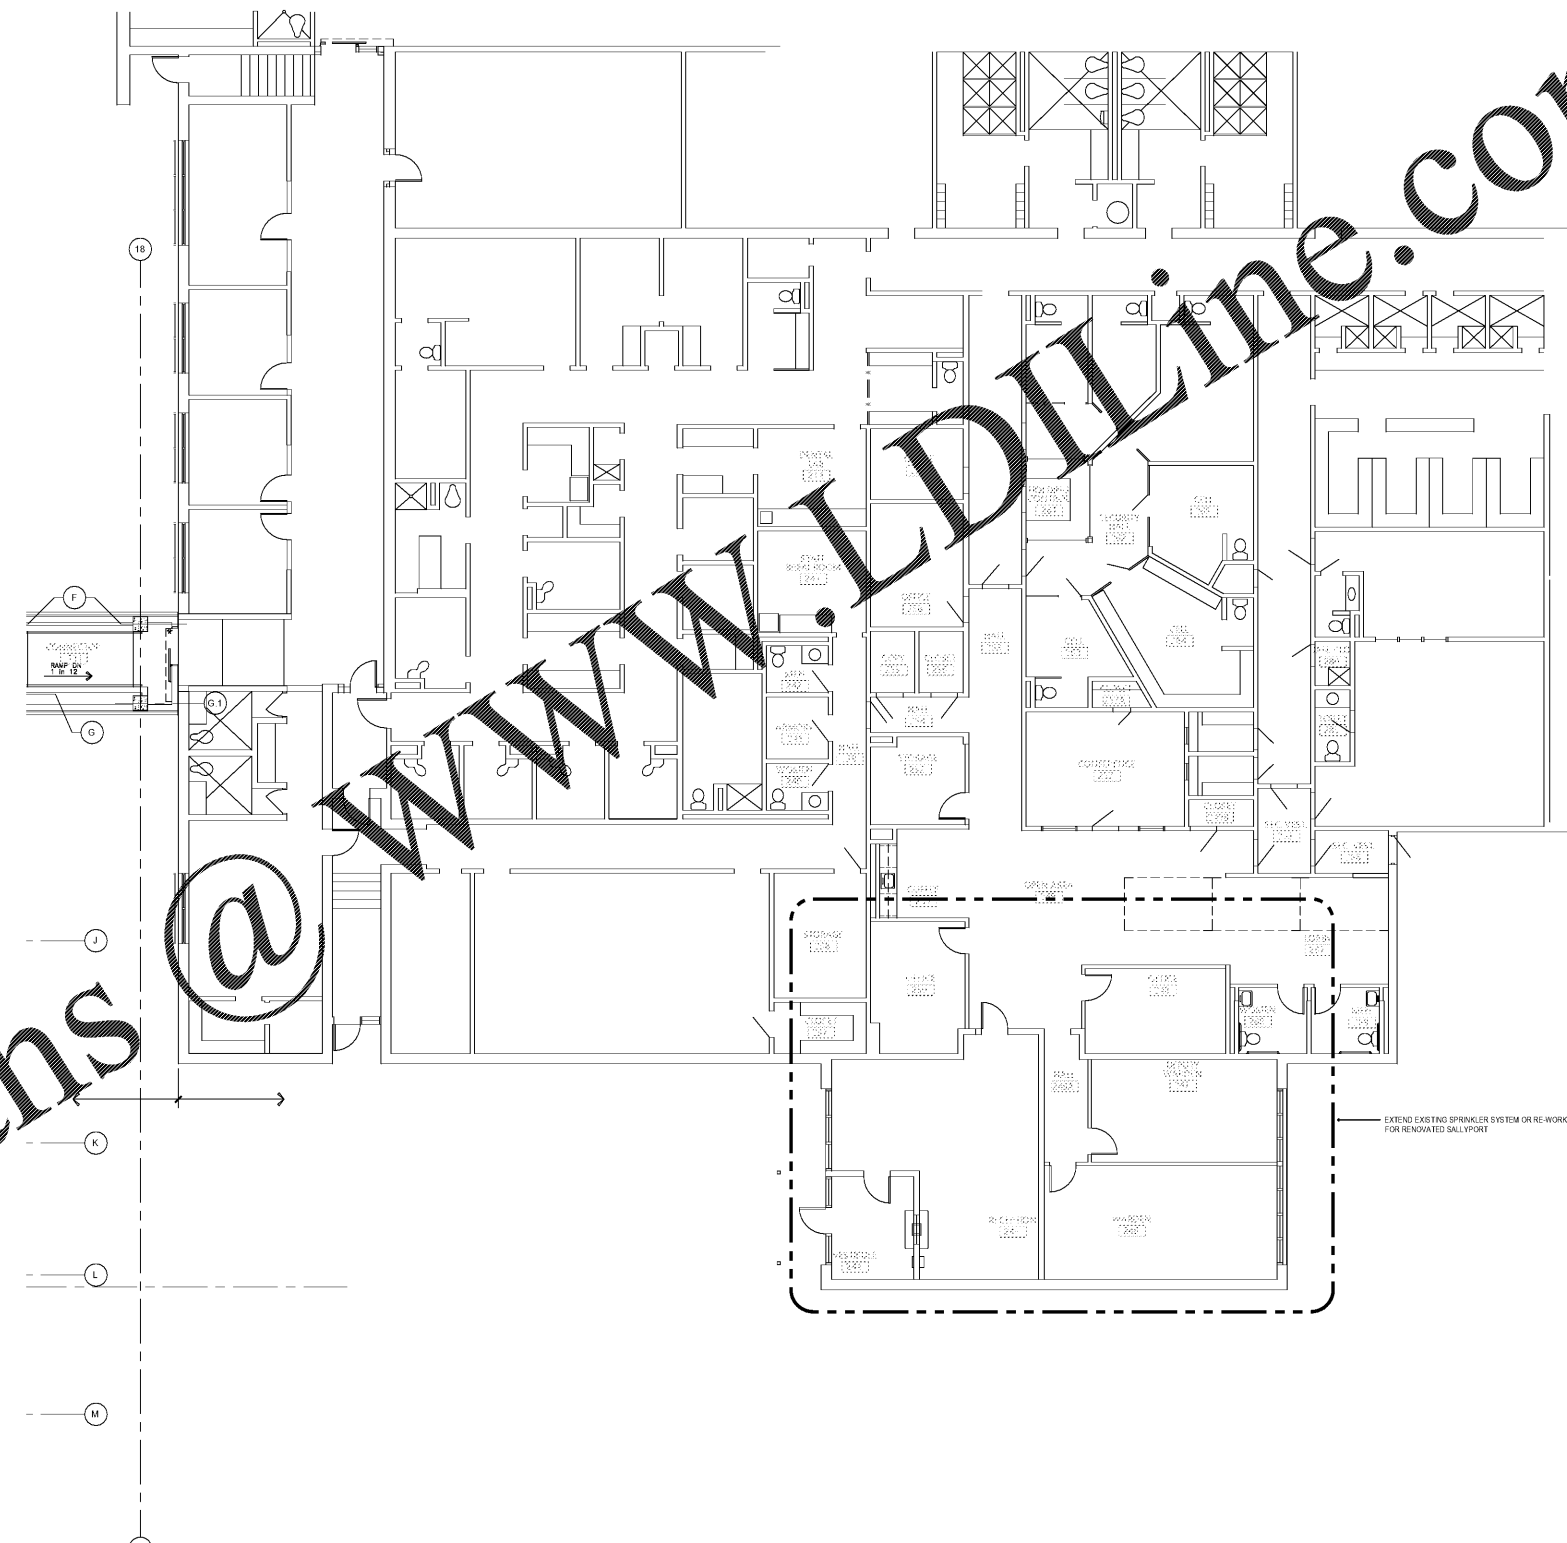

EXISTING BLDG. - BASE BID FIRE PROTECTION
SCALE: 1/8" = 1'-0" FIN FLOOR ELEV = 14.0'




ZGOUVAS, EIRING & ASSOCIATES
CONSULTING ENGINEERS
800 S. MONROUE STREET
MONTGOMERY, AL 36104
334.263-4406
ZEA PROJECT NUMBER 18-166

CIP-2017-001
UPGRADES TO THE MOBILE COUNTY METRO JAIL
FOR THE MOBILE COUNTY COMMISSION
MOBILE, ALABAMA



DRAWN	CW	CHECK	TZ
DATE	APRIL 2, 2019 RTA		
REVISED			
REVISED			
SHEET TITLE			
EXISTING BUILDING BASE BID FIRE PROTECTION PLAN			
JOB NO.			
PH&J#1801GV			
SEQUENCE NO.			
101 of 175			

FP2.1.2
© PH&J ARCHITECTS, INC.
ALL RIGHTS RESERVED

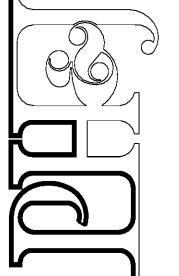

architects inc.
Montgomery, Alabama