

CIP-2017-001
UPGRADES TO THE MOBILE COUNTY METRO JAIL
FOR THE MOBILE COUNTY COMMISSION
MOBILE, ALABAMA



DRAWN	CW	CHECK	TZ
DATE	APRIL 2, 2019 RTA		
REVISED			
REVISED			

SHEET TITLE	FIRST FLOOR NON-PRESSURE PIPING PLAN BASE BID
DWG NO.	PH&J#1801GV
SEQUENCE	NO. 107 OF 175


P3

© PH&J ARCHITECTS, INC.
ALL RIGHTS RESERVED

ZGOUVAS, EIRING & ASSOCIATES
CONSULTING ENGINEERS
800 S. McDONOUGH STREET
MONTGOMERY, AL. 36104
334.263.4406
ZEA PROJECT NUMBER 18-166

Order Plans @ www.dlline.com

WWW.DLLINE.COM

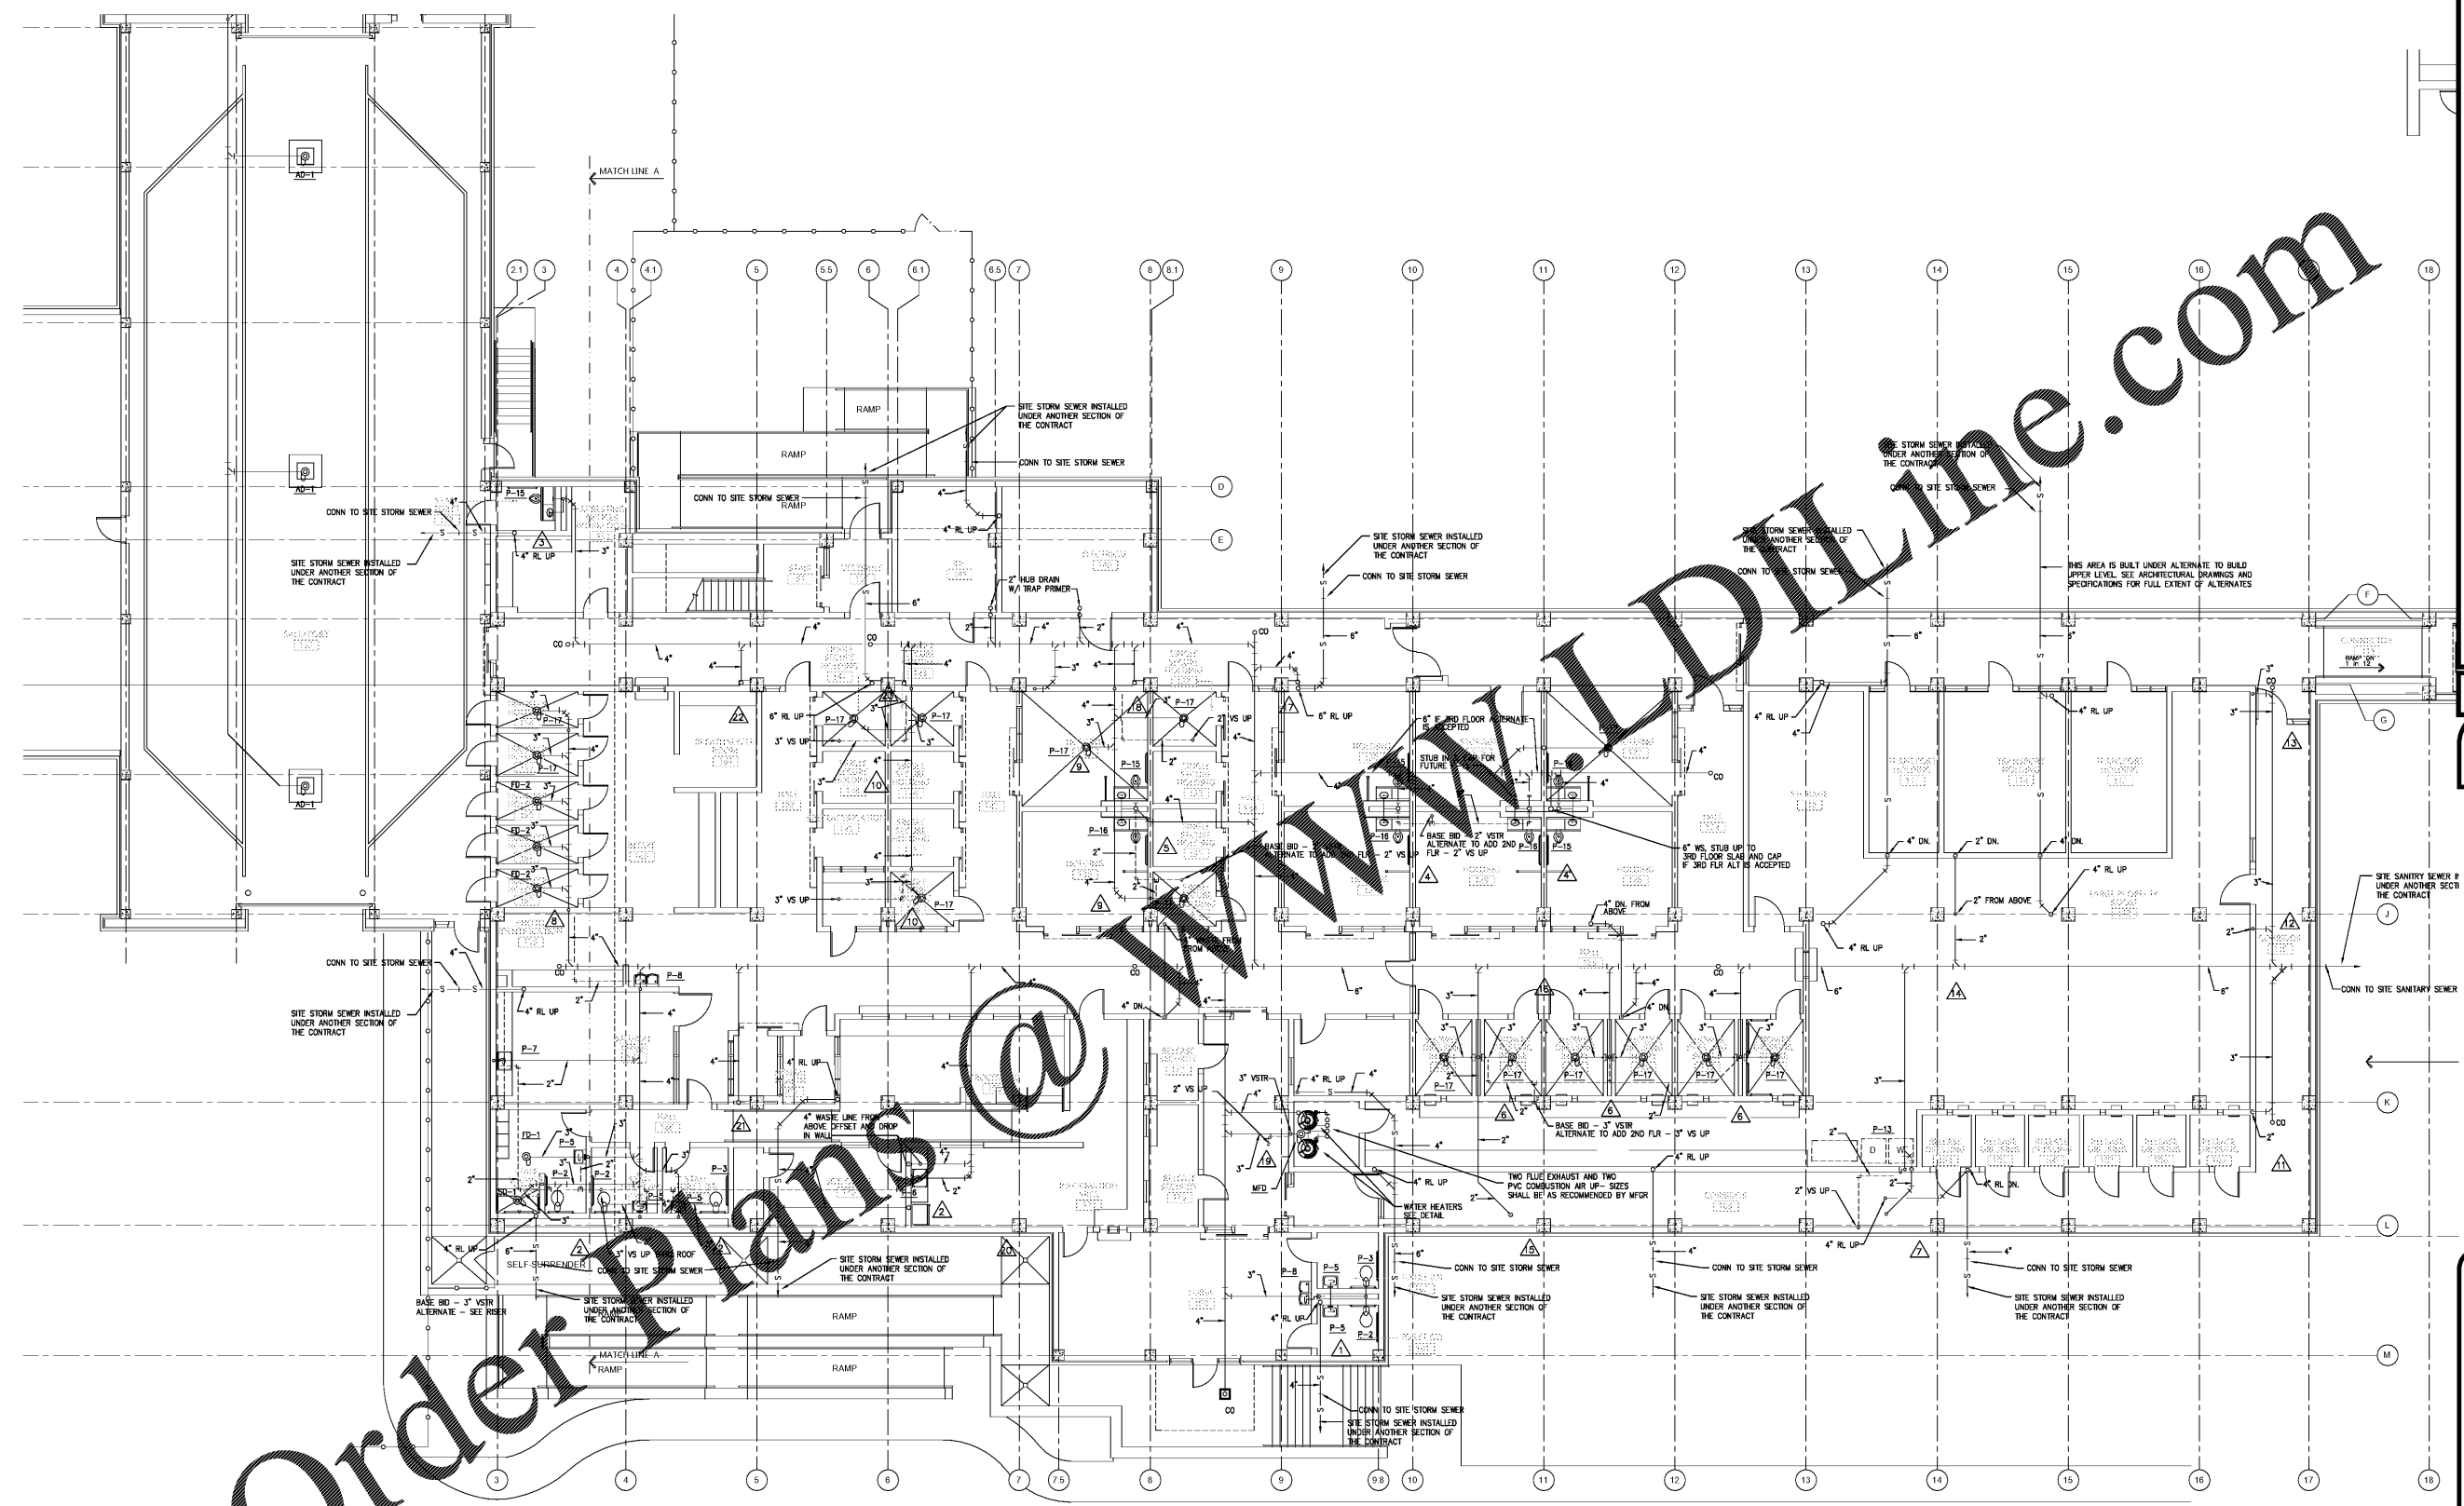

NOTE:
FIRST FLOOR IS OVER A CRAWL SPACE AND A SERIES OF GRADE BEAMS.
COORDINATE CAREFULLY WITH ARCHITECTURAL AND STRUCTURAL PLANS.

FIRST FLOOR PLAN - NON-PRESSURE PIPING - BASE BID

