

CIP-2017-001
UPGRADES TO THE MOBILE COUNTY METRO JAIL
For The MOBILE COUNTY COMMISSION
MOBILE, ALABAMA




DRAWN	CW	CHECK	TZ
DATE	APRIL 2, 2019 RTA		
REVISED			
REVISION			

SHEET TITLE
ALTERNATE #2 FLOOR PLAN -
NON-PRESSURE PIPING

DSB NO.
PH&J#1801GV

SEQUENCE
No. 108 of 175

P4
© PH&J ARCHITECTS, INC.
ALL RIGHTS RESERVED

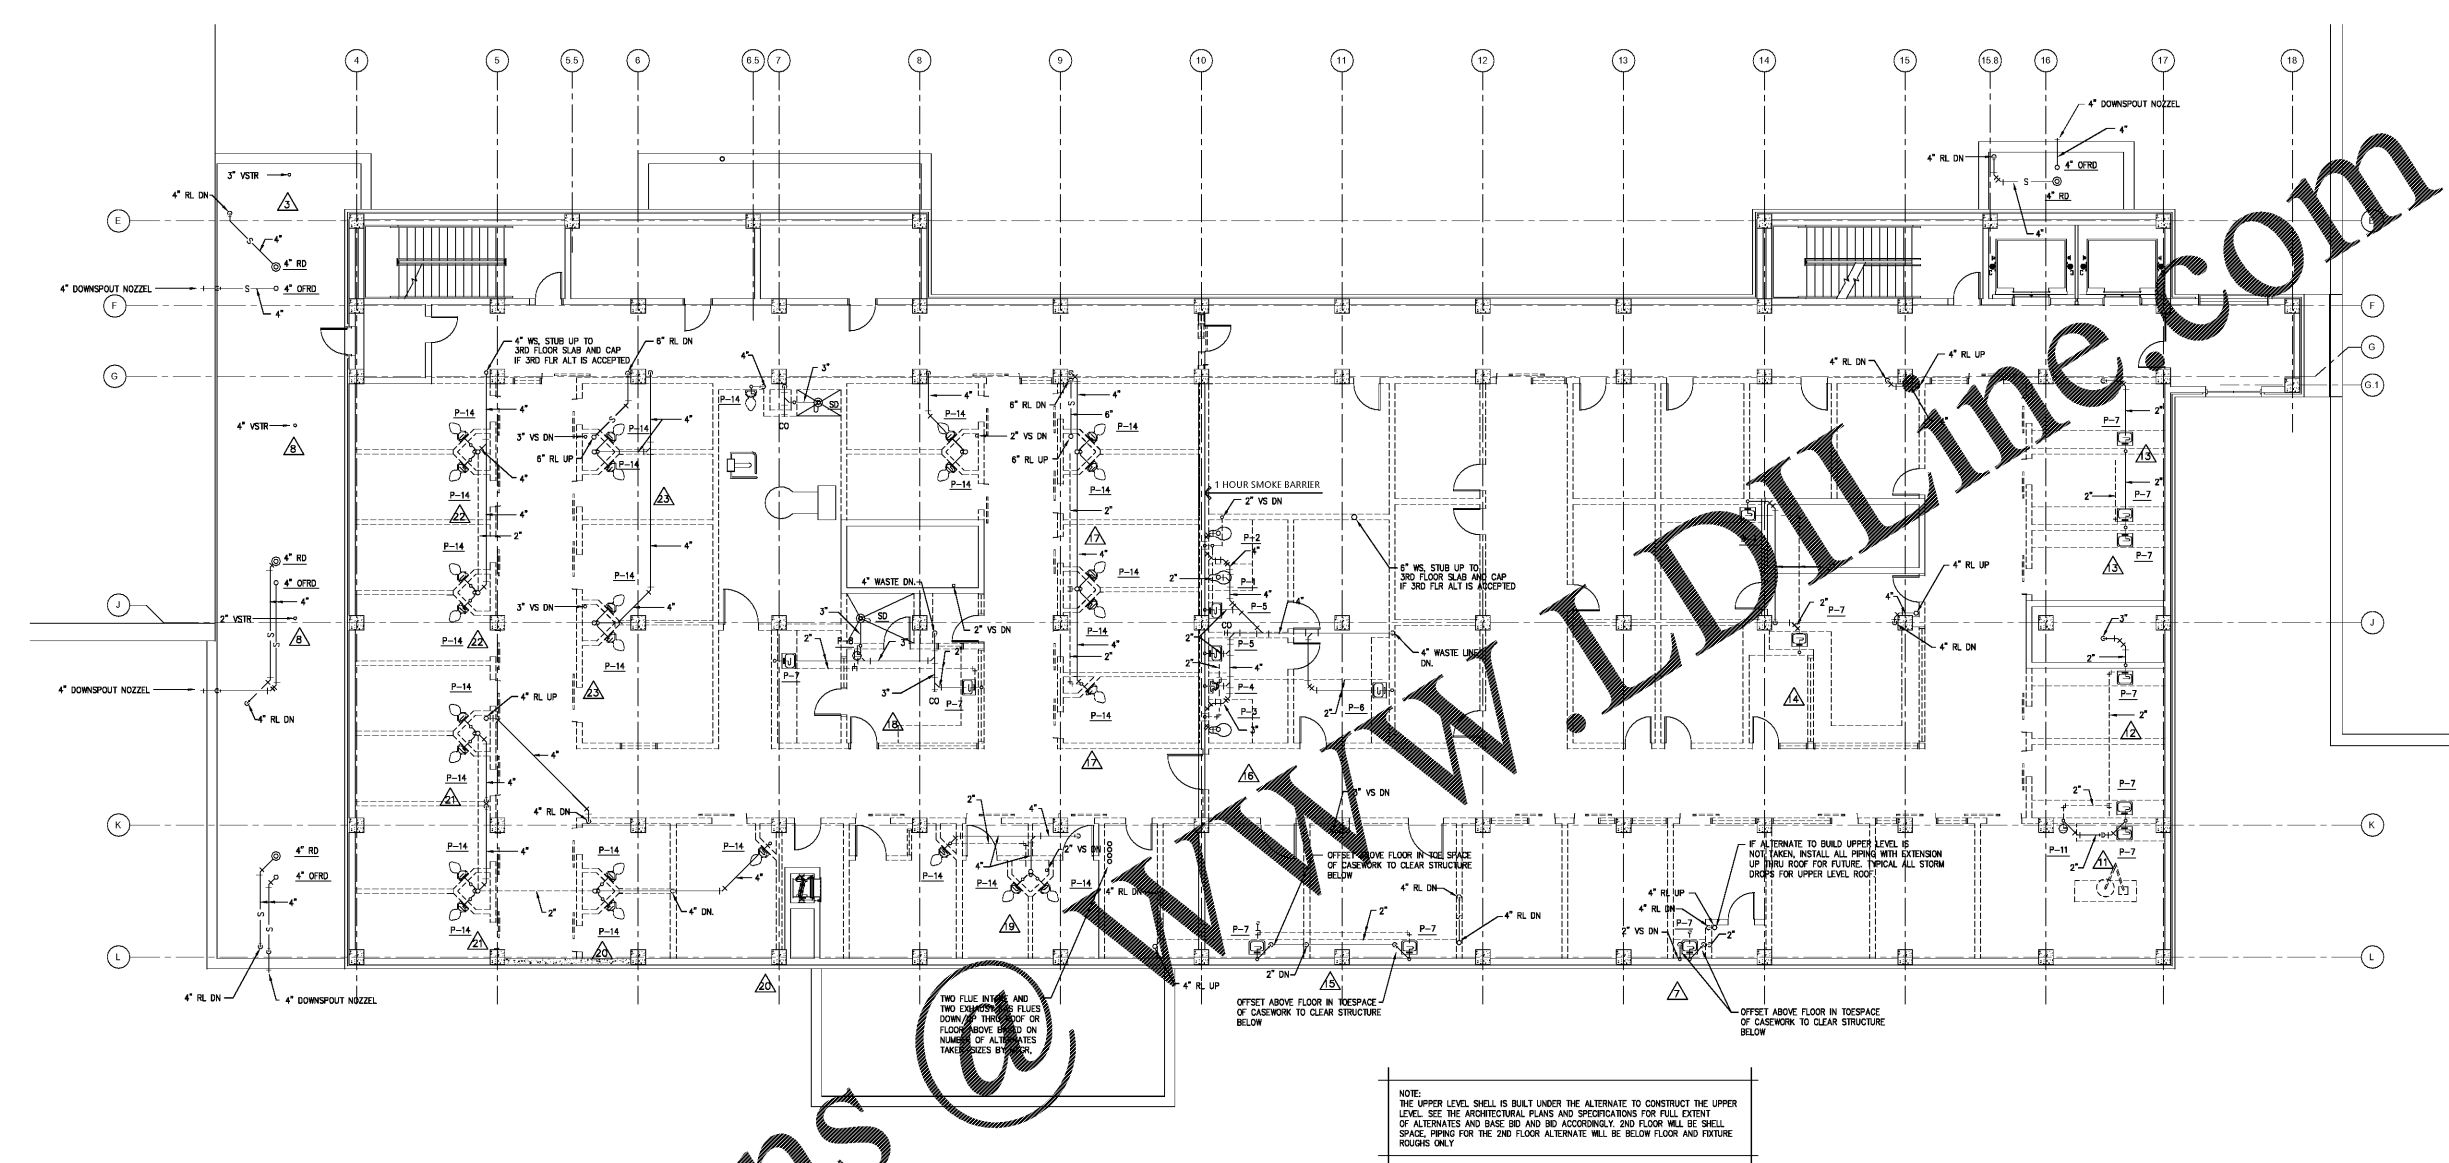

ALTERNATE #2 SECOND FLOOR PLAN - NON-PRESSURE PIPING

SCALE: 1/8"=1'-0"



Order Plans