

CIP-2017-001
UPGRADES TO THE MOBILE COUNTY METRO JAIL
For The MOBILE COUNTY COMMISSION
MOBILE, ALABAMA



DRAWN	CW	CHECK	TZ
DATE	APRIL 2, 2019 RTA		
REVISION			
REVISION			

SHEET TITLE
FIRST FLOOR PRESSURE PIPING
PLAN BASE BID


IDB NO.
PH&J#1801GV

SEQUENCE
No. 109 of 173

P5
© PH&J ARCHITECTS, INC.
ALL RIGHTS RESERVED



800 S. McDONOUGH STREET
MONTGOMERY, AL 36104
334.293.4408
ZEA PROJECT NUMBER 18-166

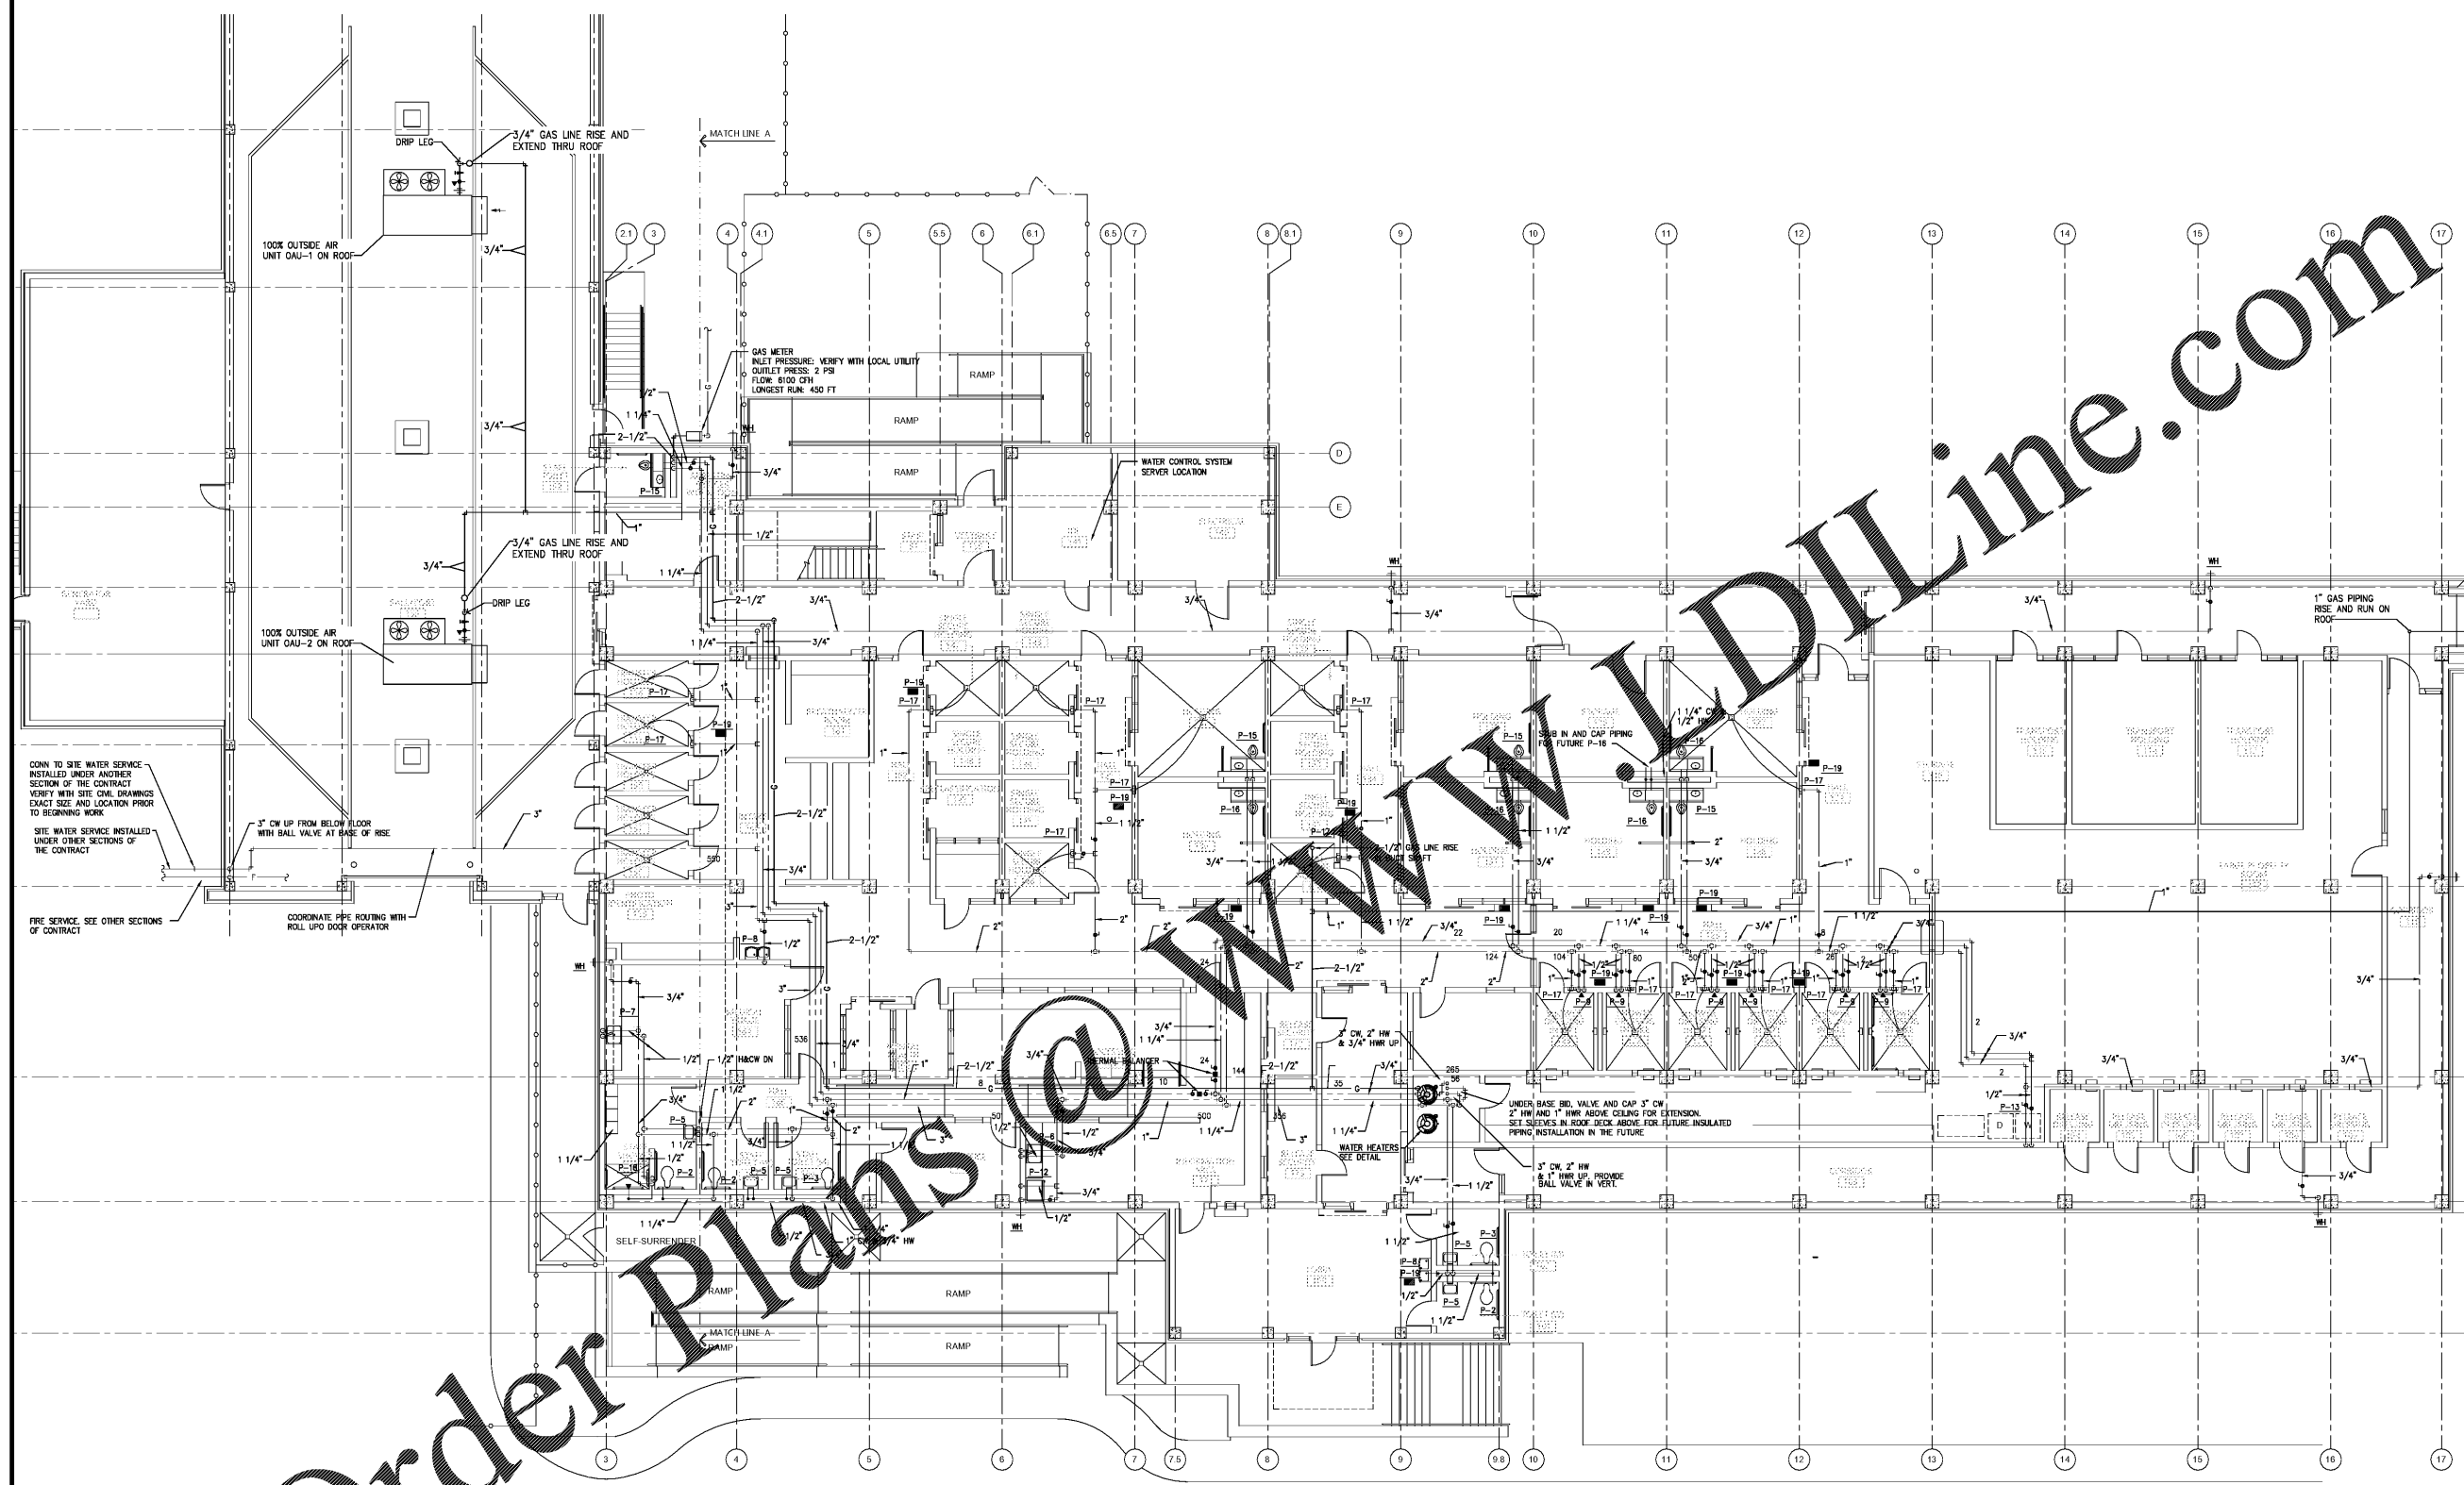

Order Plans @ WWW.DIline.com

FIRST FLOOR PLAN - PRESSURE PIPING - BASE BID

SCALE: 1/8"=1'-0"



800 S. McDONOUGH STREET
MONTGOMERY, AL 36104
334.293.4408
ZEA PROJECT NUMBER 18-166