


PARTIAL THIRD FLOOR PLAN - ALTERNATE #3 - PRESSURE PIPING

SCALE: 1/8"=1'-0"

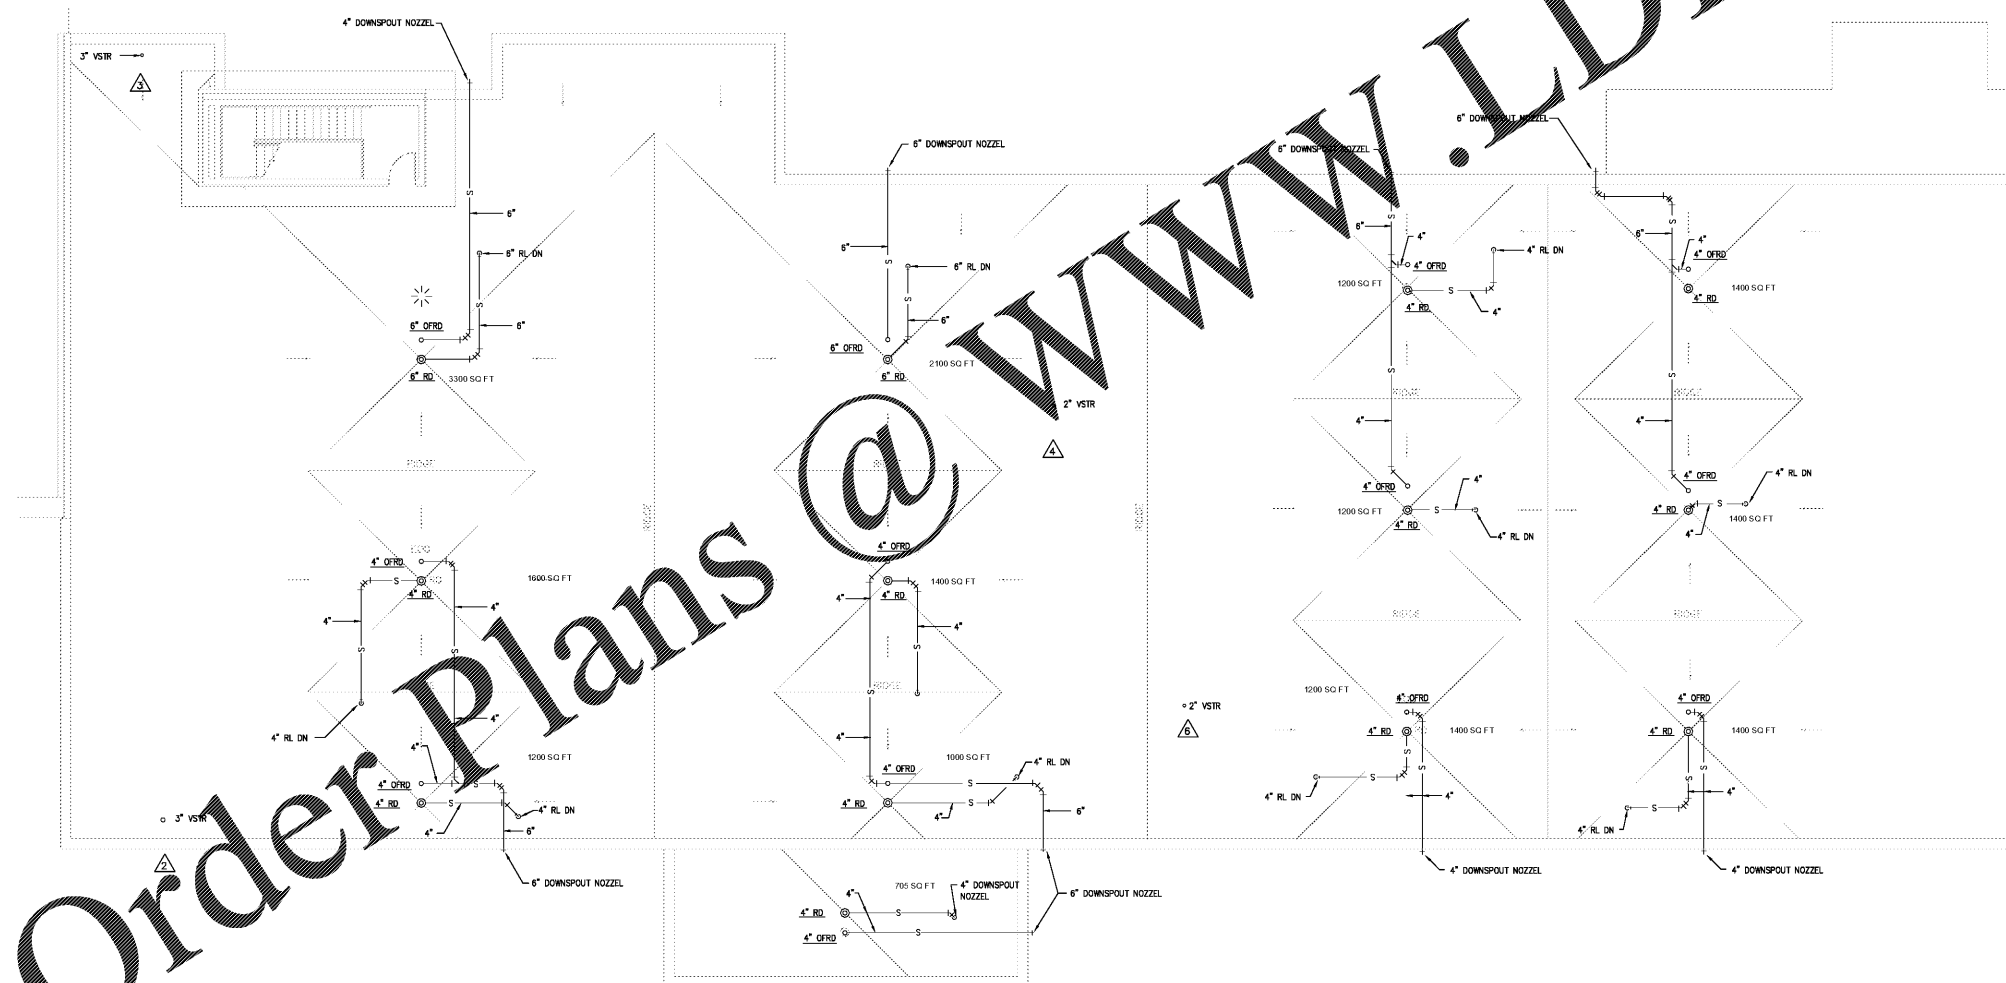


BASE BID ROOF PLAN - NON-PRESSURE PIPING

SCALE: 1/8"=1'-0"



THE INFORMATION CONTAINED IN THIS DRAWING IS COPYRIGHTED MATERIAL AND SHALL NOT BE REPRODUCED, DIGITIZED, OR REVISED, IN WHOLE OR IN PART, WITHOUT THE WRITTEN CONSENT OF ZGOUVAS, EIRING AND ASSOCIATES

architects inc.
Montgomery, Alabama

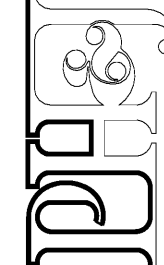

CIP-2017-001
UPGRADES TO THE MOBILE COUNTY METRO JAIL
For The MOBILE COUNTY COMMISSION
MOBILE, ALABAMA



DRAWN	CW	CHECK	TZ
DATE	APRIL 2, 2019 RTA		
REVISION			
REVISION			

SHEET TITLE
BASE BID ROOF PLAN -
NON-PRESSURE PIPING

JOB NO.
PH&J#1801GV

SEQUENCE
No. 111 of 175

P7
© PH&J ARCHITECTS, INC.
ALL RIGHTS RESERVED

ZGOUVAS, EIRING & ASSOCIATES
CONSULTING ENGINEERS
800 S. McDONOUGH STREET
MONTGOMERY, AL 36104
334.263-4408
ZEA PROJECT NUMBER 18-166