


CIP-2017-001
UPGRADES TO THE MOBILE COUNTY METRO JAIL
FOR THE MOBILE COUNTY COMMISSION
MOBILE, ALABAMA

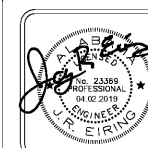

DRAWN	CW	CHECK	TR
DATE	APRIL 2, 2019 RTA		
REVISED			
REVISED			

SHEET TITLE
ALTERNATE ROOF PLAN -
NON-PRESSURE PIPING


DWG NO.
PH&J#1801GV

SEQUENCE
NO. 112 of 175

P8
© PH&JARCHITECTS, INC.
ALL RIGHTS RESERVED




800 S. McDONOUGH STREET
MONTGOMERY, AL 36104
334.293.4400
ZEA PROJECT NUMBER 18-166

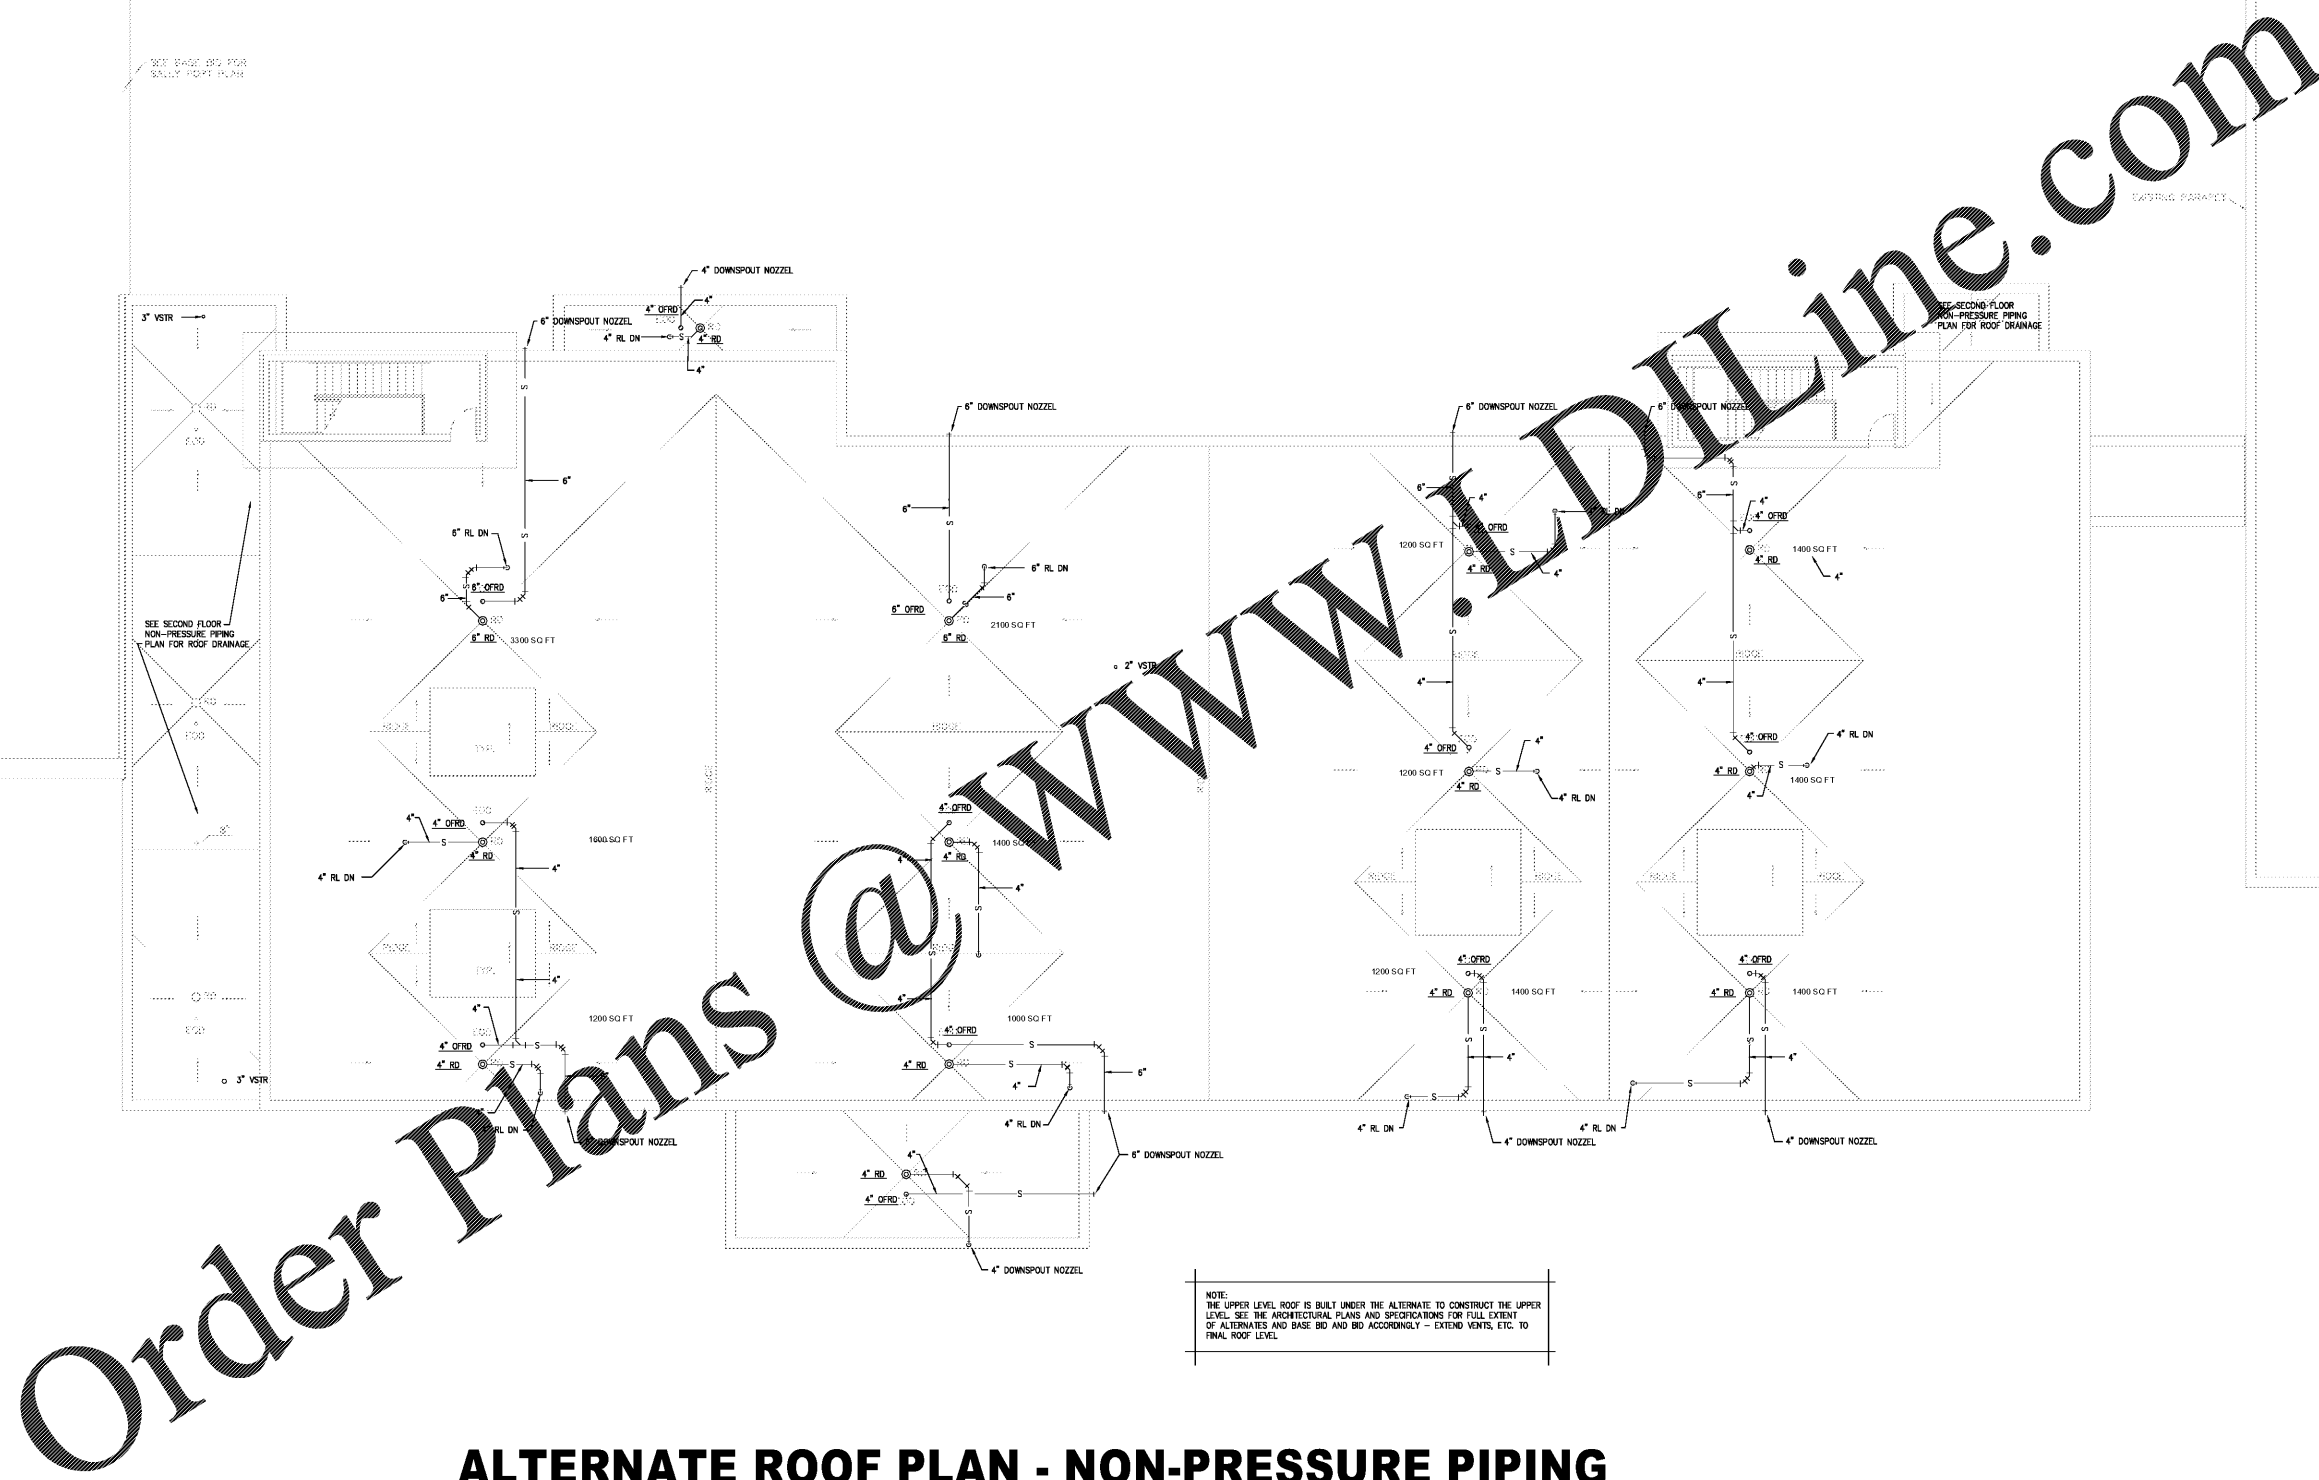

NOTE:
THE UPPER LEVEL ROOF IS BUILT UNDER THE ALTERNATE TO CONSTRUCT THE UPPER LEVEL. SEE THE ARCHITECTURAL PLANS AND SPECIFICATIONS FOR FULL EXTENT OF ALTERNATES AND BASE BID AND BID ACCORDINGLY - EXTEND VENTS, ETC. TO FINAL ROOF LEVEL.

ALTERNATE ROOF PLAN - NON-PRESSURE PIPING

 SCALE: 1/8"=1'-0"



Order Plans @ WWW.DIline.com