



Order Plans @

WWW.IDLINE.COM

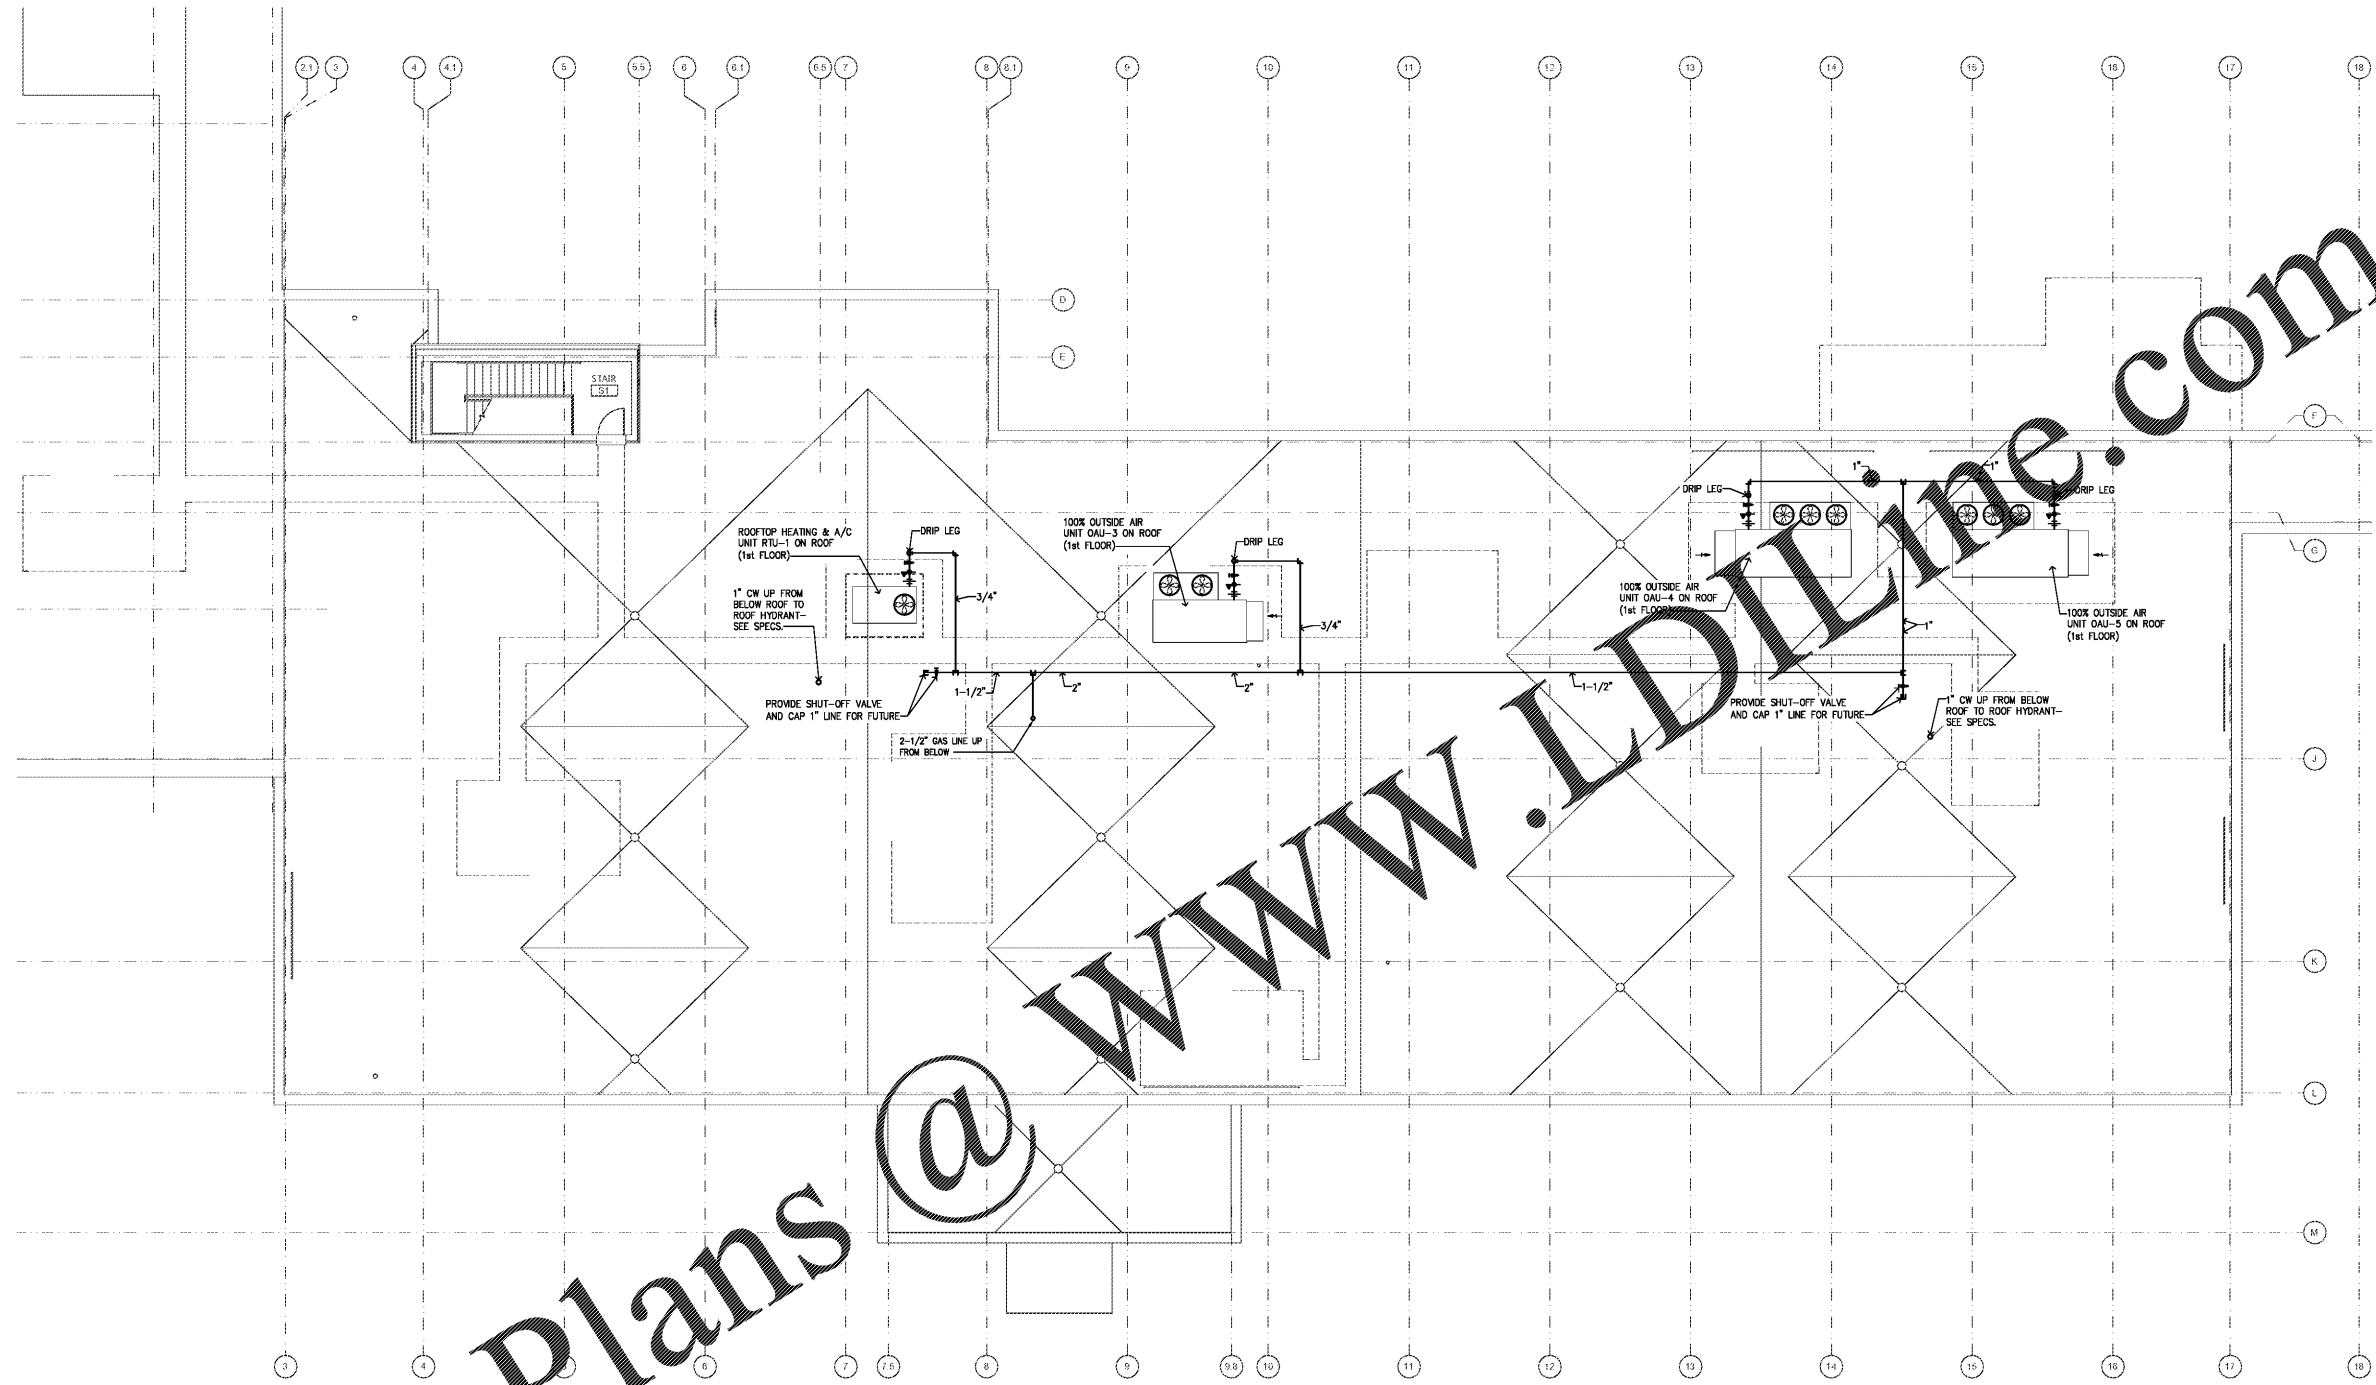


### BASE BID ROOF PLAN - PRESSURE PIPING

 SCALE: 1/8"=1'-0"



architects inc.  
Montgomery, Alabama

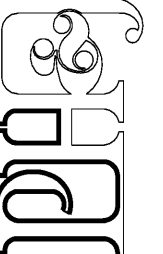

CIP-2017-001  
UPGRADES TO THE MOBILE COUNTY METRO JAIL  
For The MOBILE COUNTY COMMISSION  
MOBILE, ALABAMA



DRAWN	CW	CHECK	TZ
DATE	APRIL 2, 2019 RTA		
REVISED			
REVISED			
SHEET TITLE			
BASE BID ROOF PLAN - PRESSURE PIPING			
DSB NO.			
PH&J#1801GV			
SEQUENCE			
No. 113 of 175			

**ZGOUVAS, EIRING & ASSOCIATES**  
CONSULTING ENGINEERS  
800 S. McDONOUGH STREET  
MONTGOMERY, AL 36104  
334.263.4406  
ZEA PROJECT NUMBER 18-166

P9