
 


Order Plans @


WWW.WLDLINE.COM

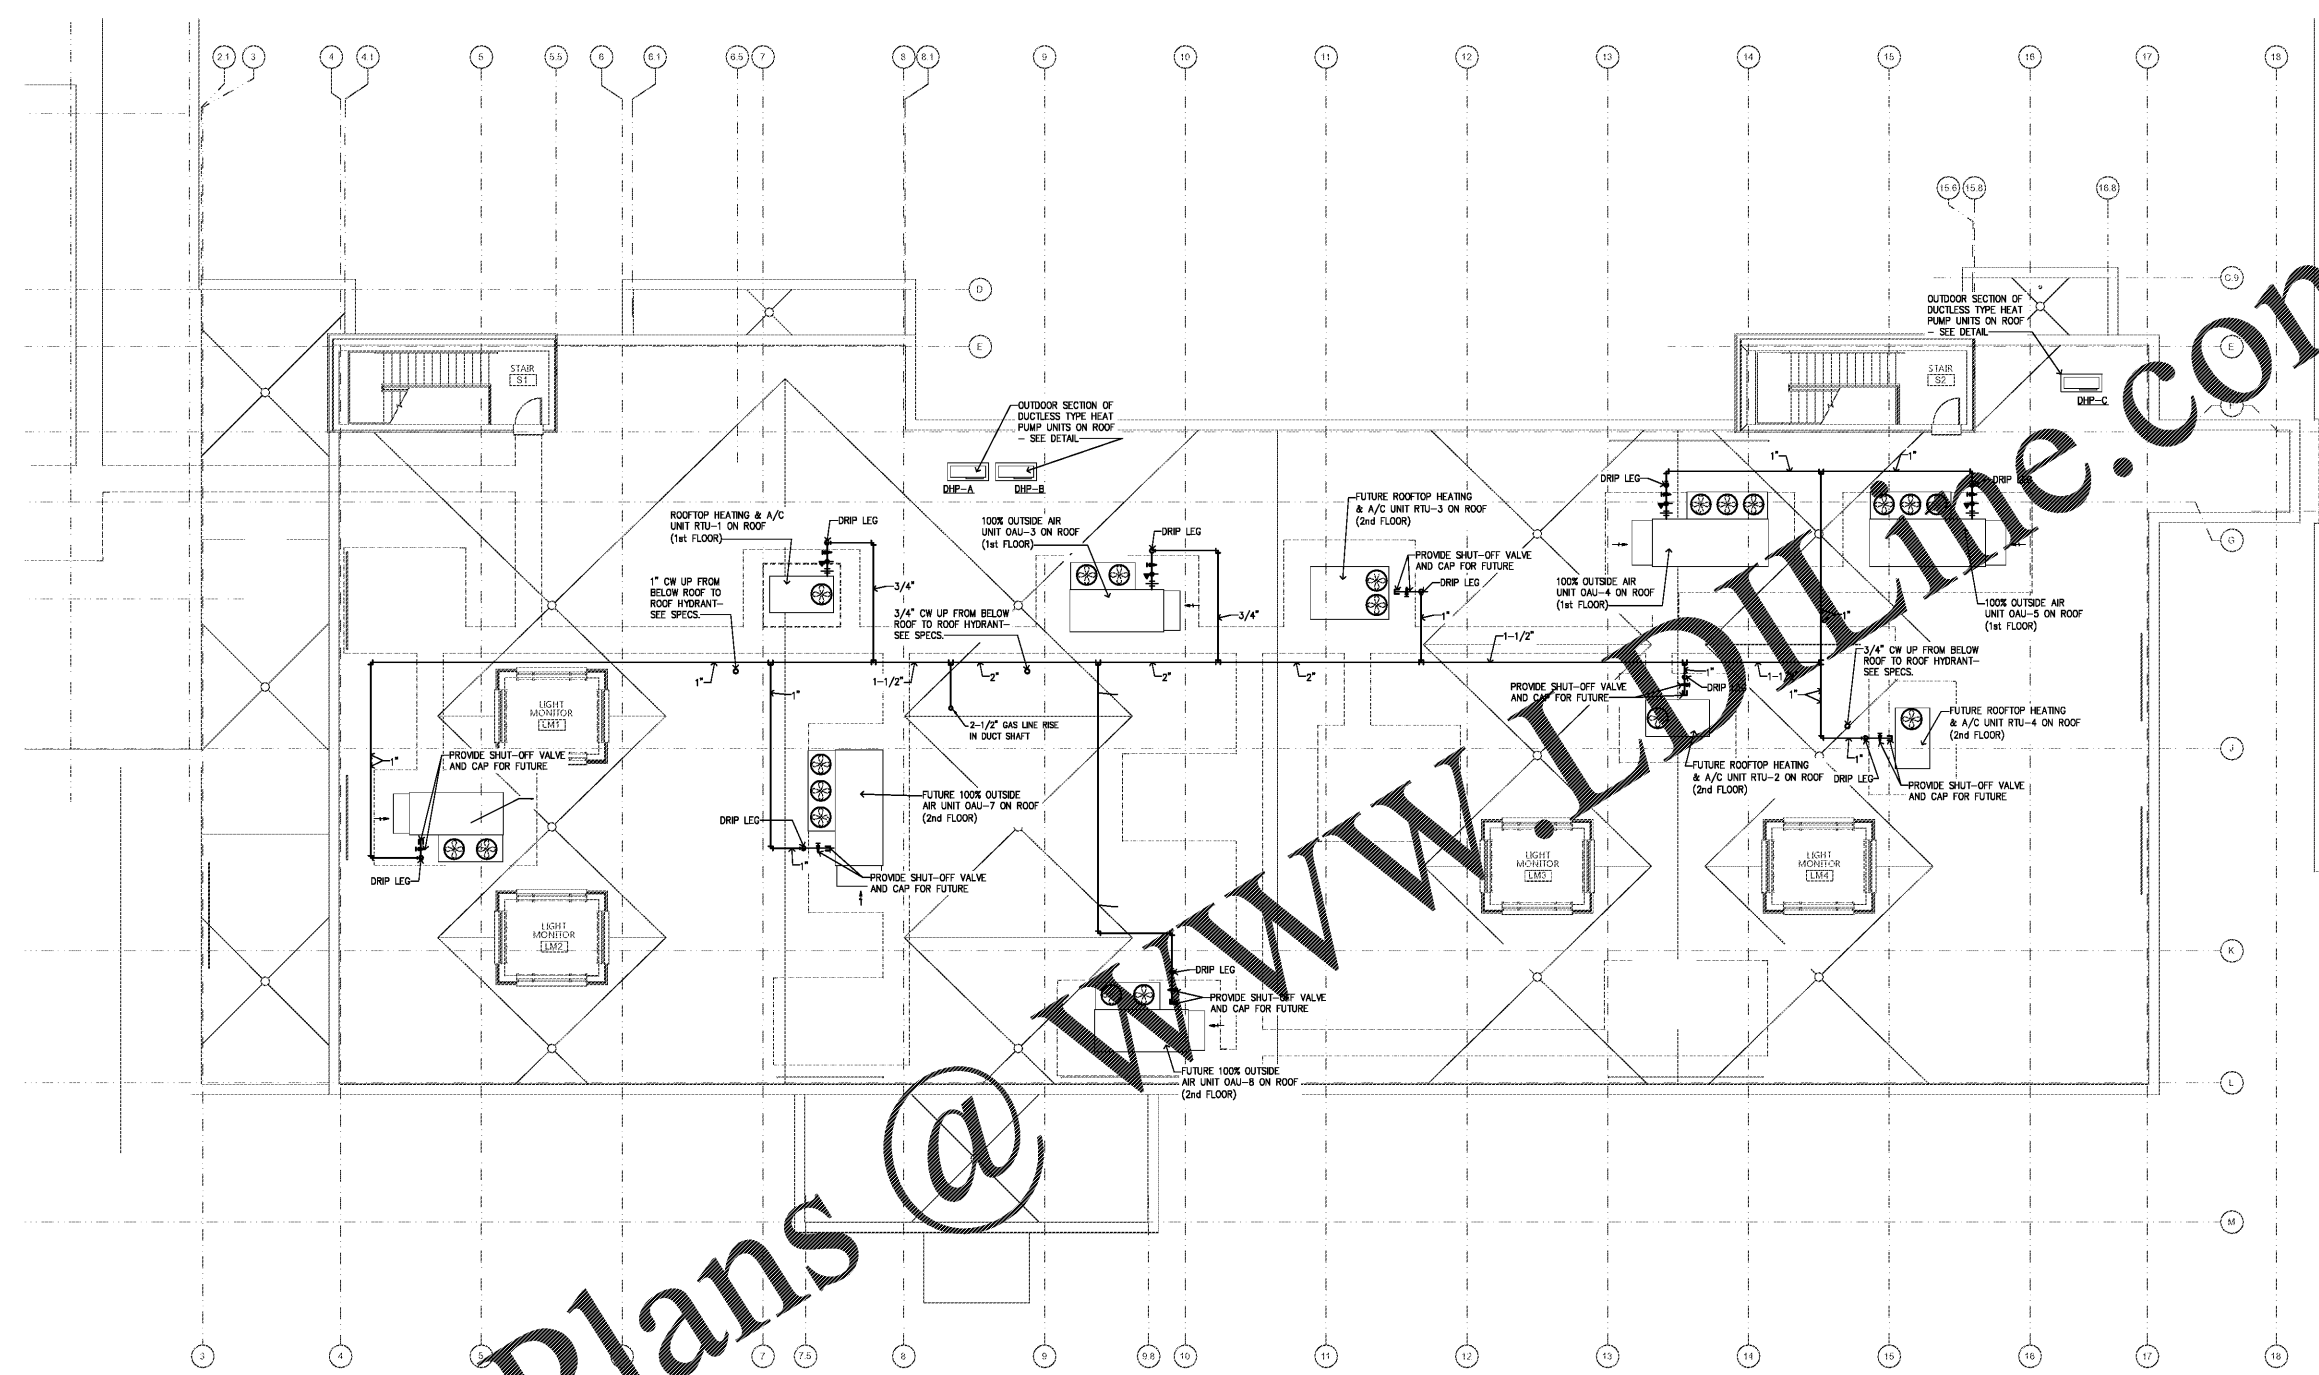

ALTERNATE #2 ROOF PLAN - PRESSURE PIPING



architects inc.
Montgomery, Alabama

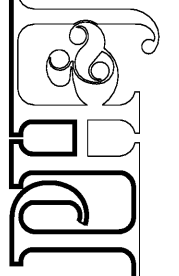

CIP-2017-001
UPGRADES TO THE MOBILE COUNTY METRO JAIL
For The MOBILE COUNTY COMMISSION
MOBILE, ALABAMA



DRAWN	CW	CHECK	TZ
DATE	APRIL 2, 2019 RTA		
REVISED			
REVISED			

SHEET TITLE
ALTERNATE #2 ROOF PLAN - PRESSURE PIPING

DSB NO.
PH&J#1801GV

SEQUENCE
No. 114 of 175



P10