


Order Plans @

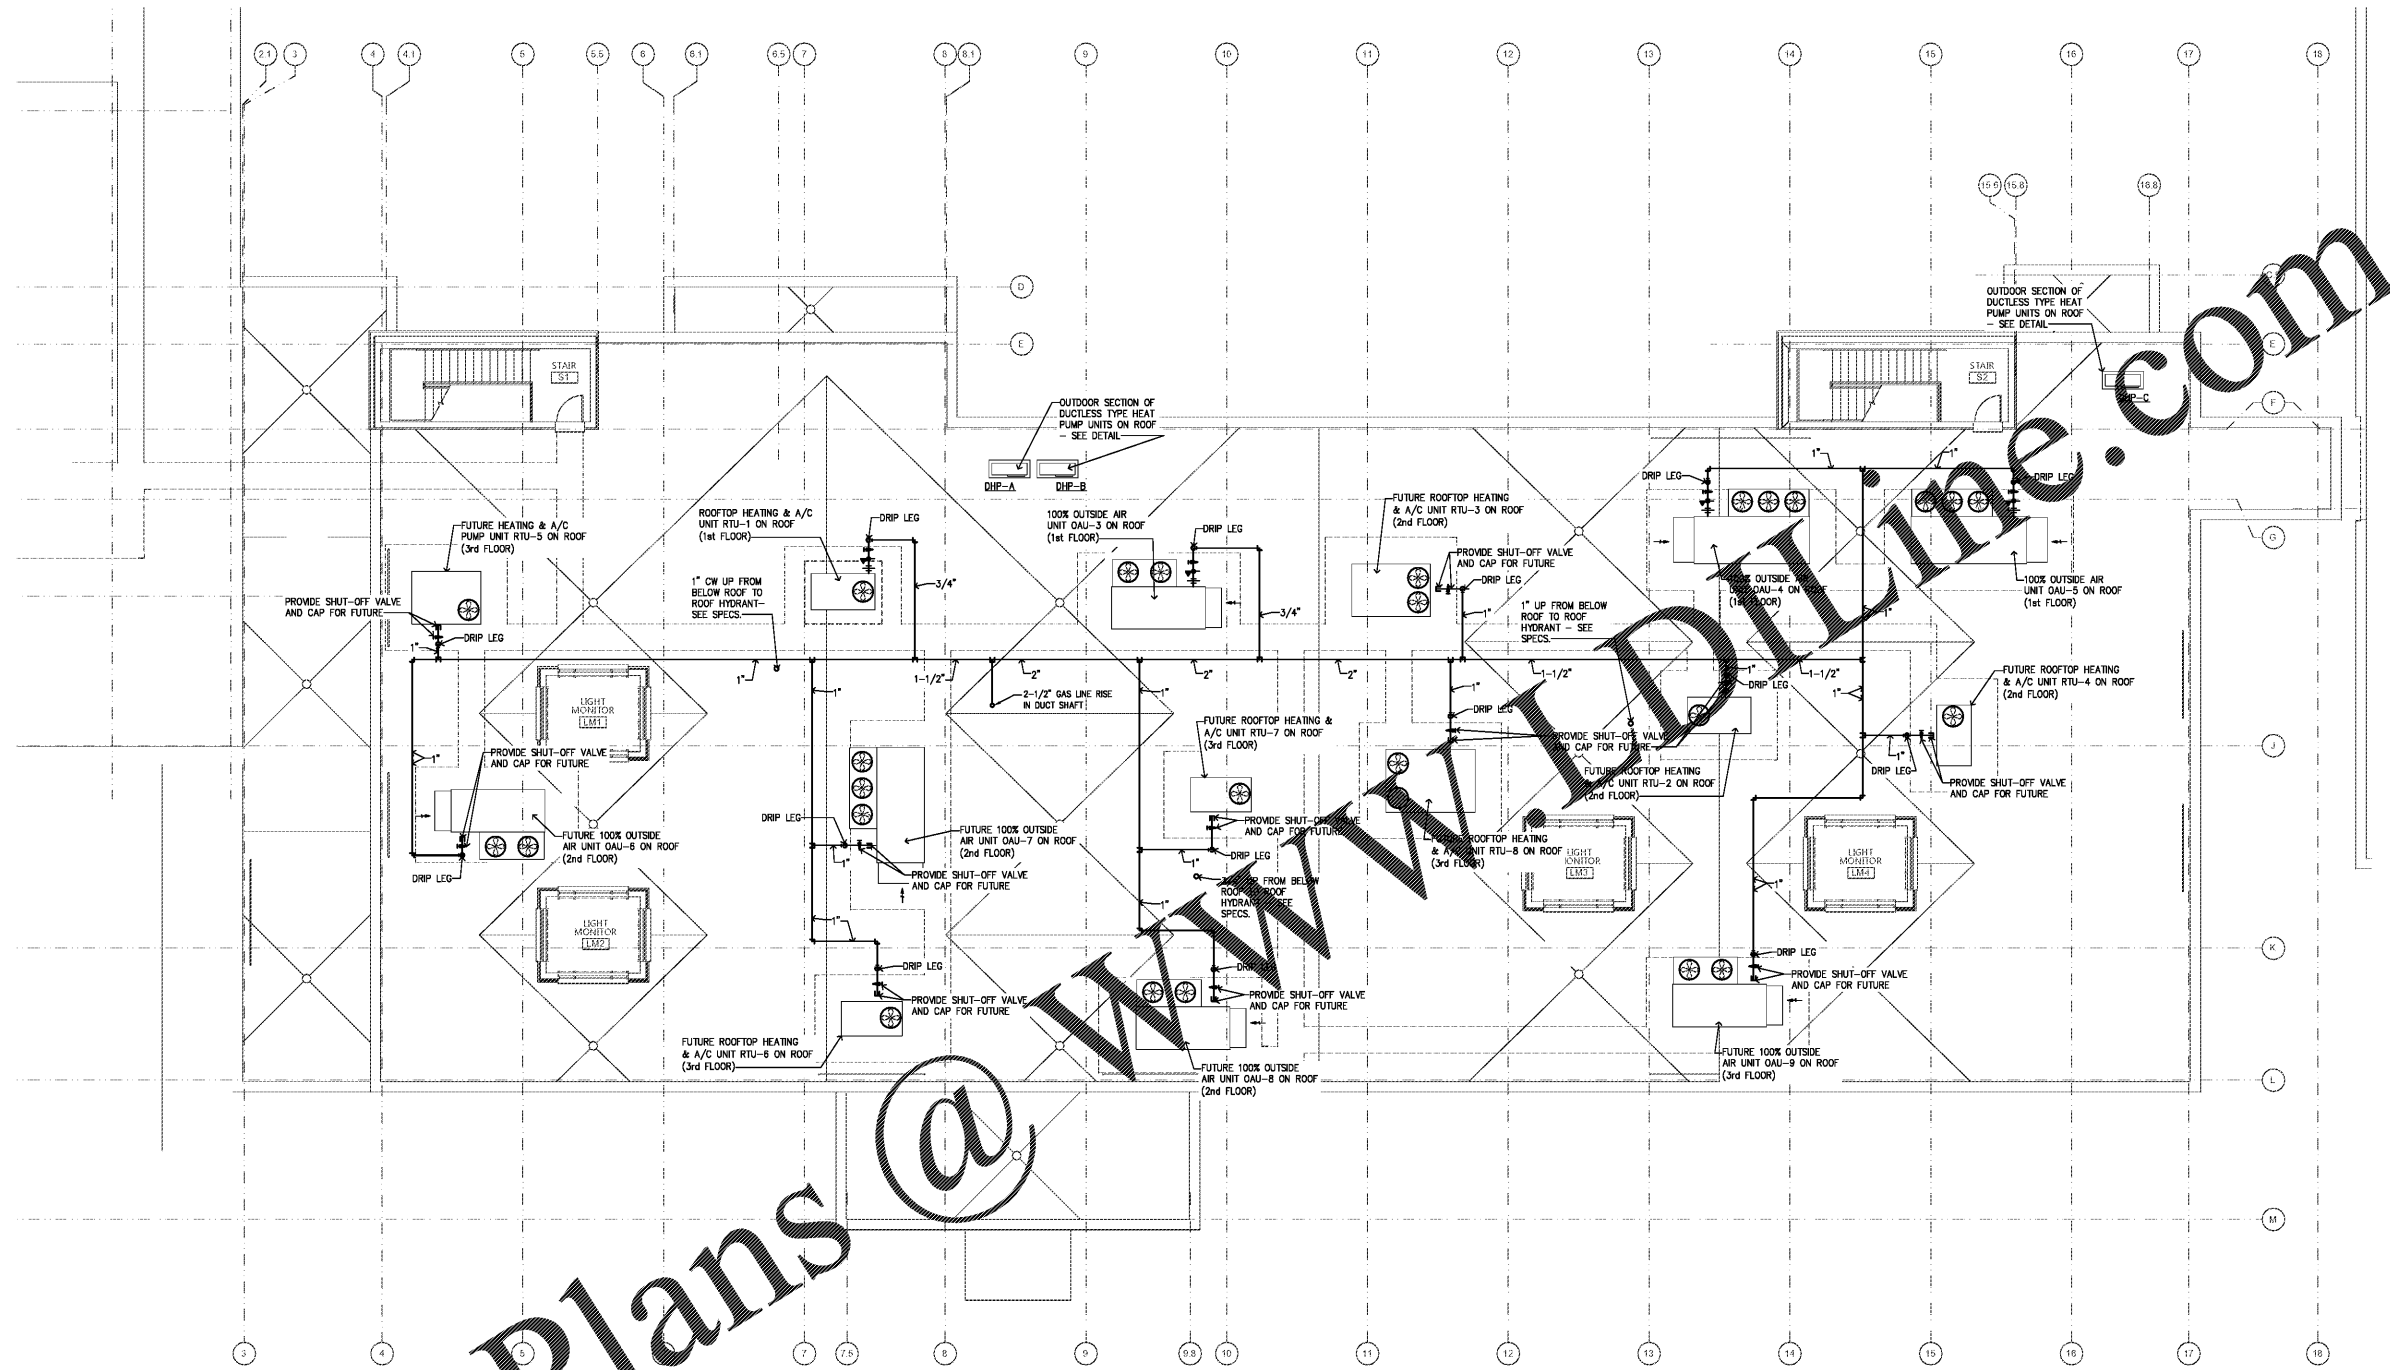


ALTERNATE #3 ROOF PLAN - PRESSURE PIPING

SCALE: 1/8"=1'-0"



architects inc.
Montgomery, Alabama

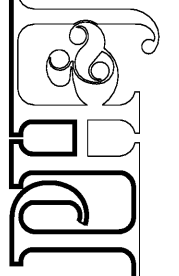

CIP-2017-001
UPGRADES TO THE MOBILE COUNTY METRO JAIL
For The MOBILE COUNTY COMMISSION
MOBILE, ALABAMA



DRAWN	CW	CHECK	TZ
DATE	APRIL 2, 2019 RTA		
REVISED			
REVISED			

SHEET TITLE
ALTERNATE #3 ROOF PLAN -
PRESSURE PIPING

DWG NO.
PH&J#1801GV

SEQUENCE
No. 115 of 175

ZGOUVAS, EIRING & ASSOCIATES
CONSULTING ENGINEERS
800 S. McDONOUGH STREET
MONTGOMERY, AL. 36104
334.263.4406
ZEA PROJECT NUMBER 18-166

P11