


1ST FLOOR - HVAC PLAN - ALTERNATE #2  
SCALE: 1/8" = 1'-0"

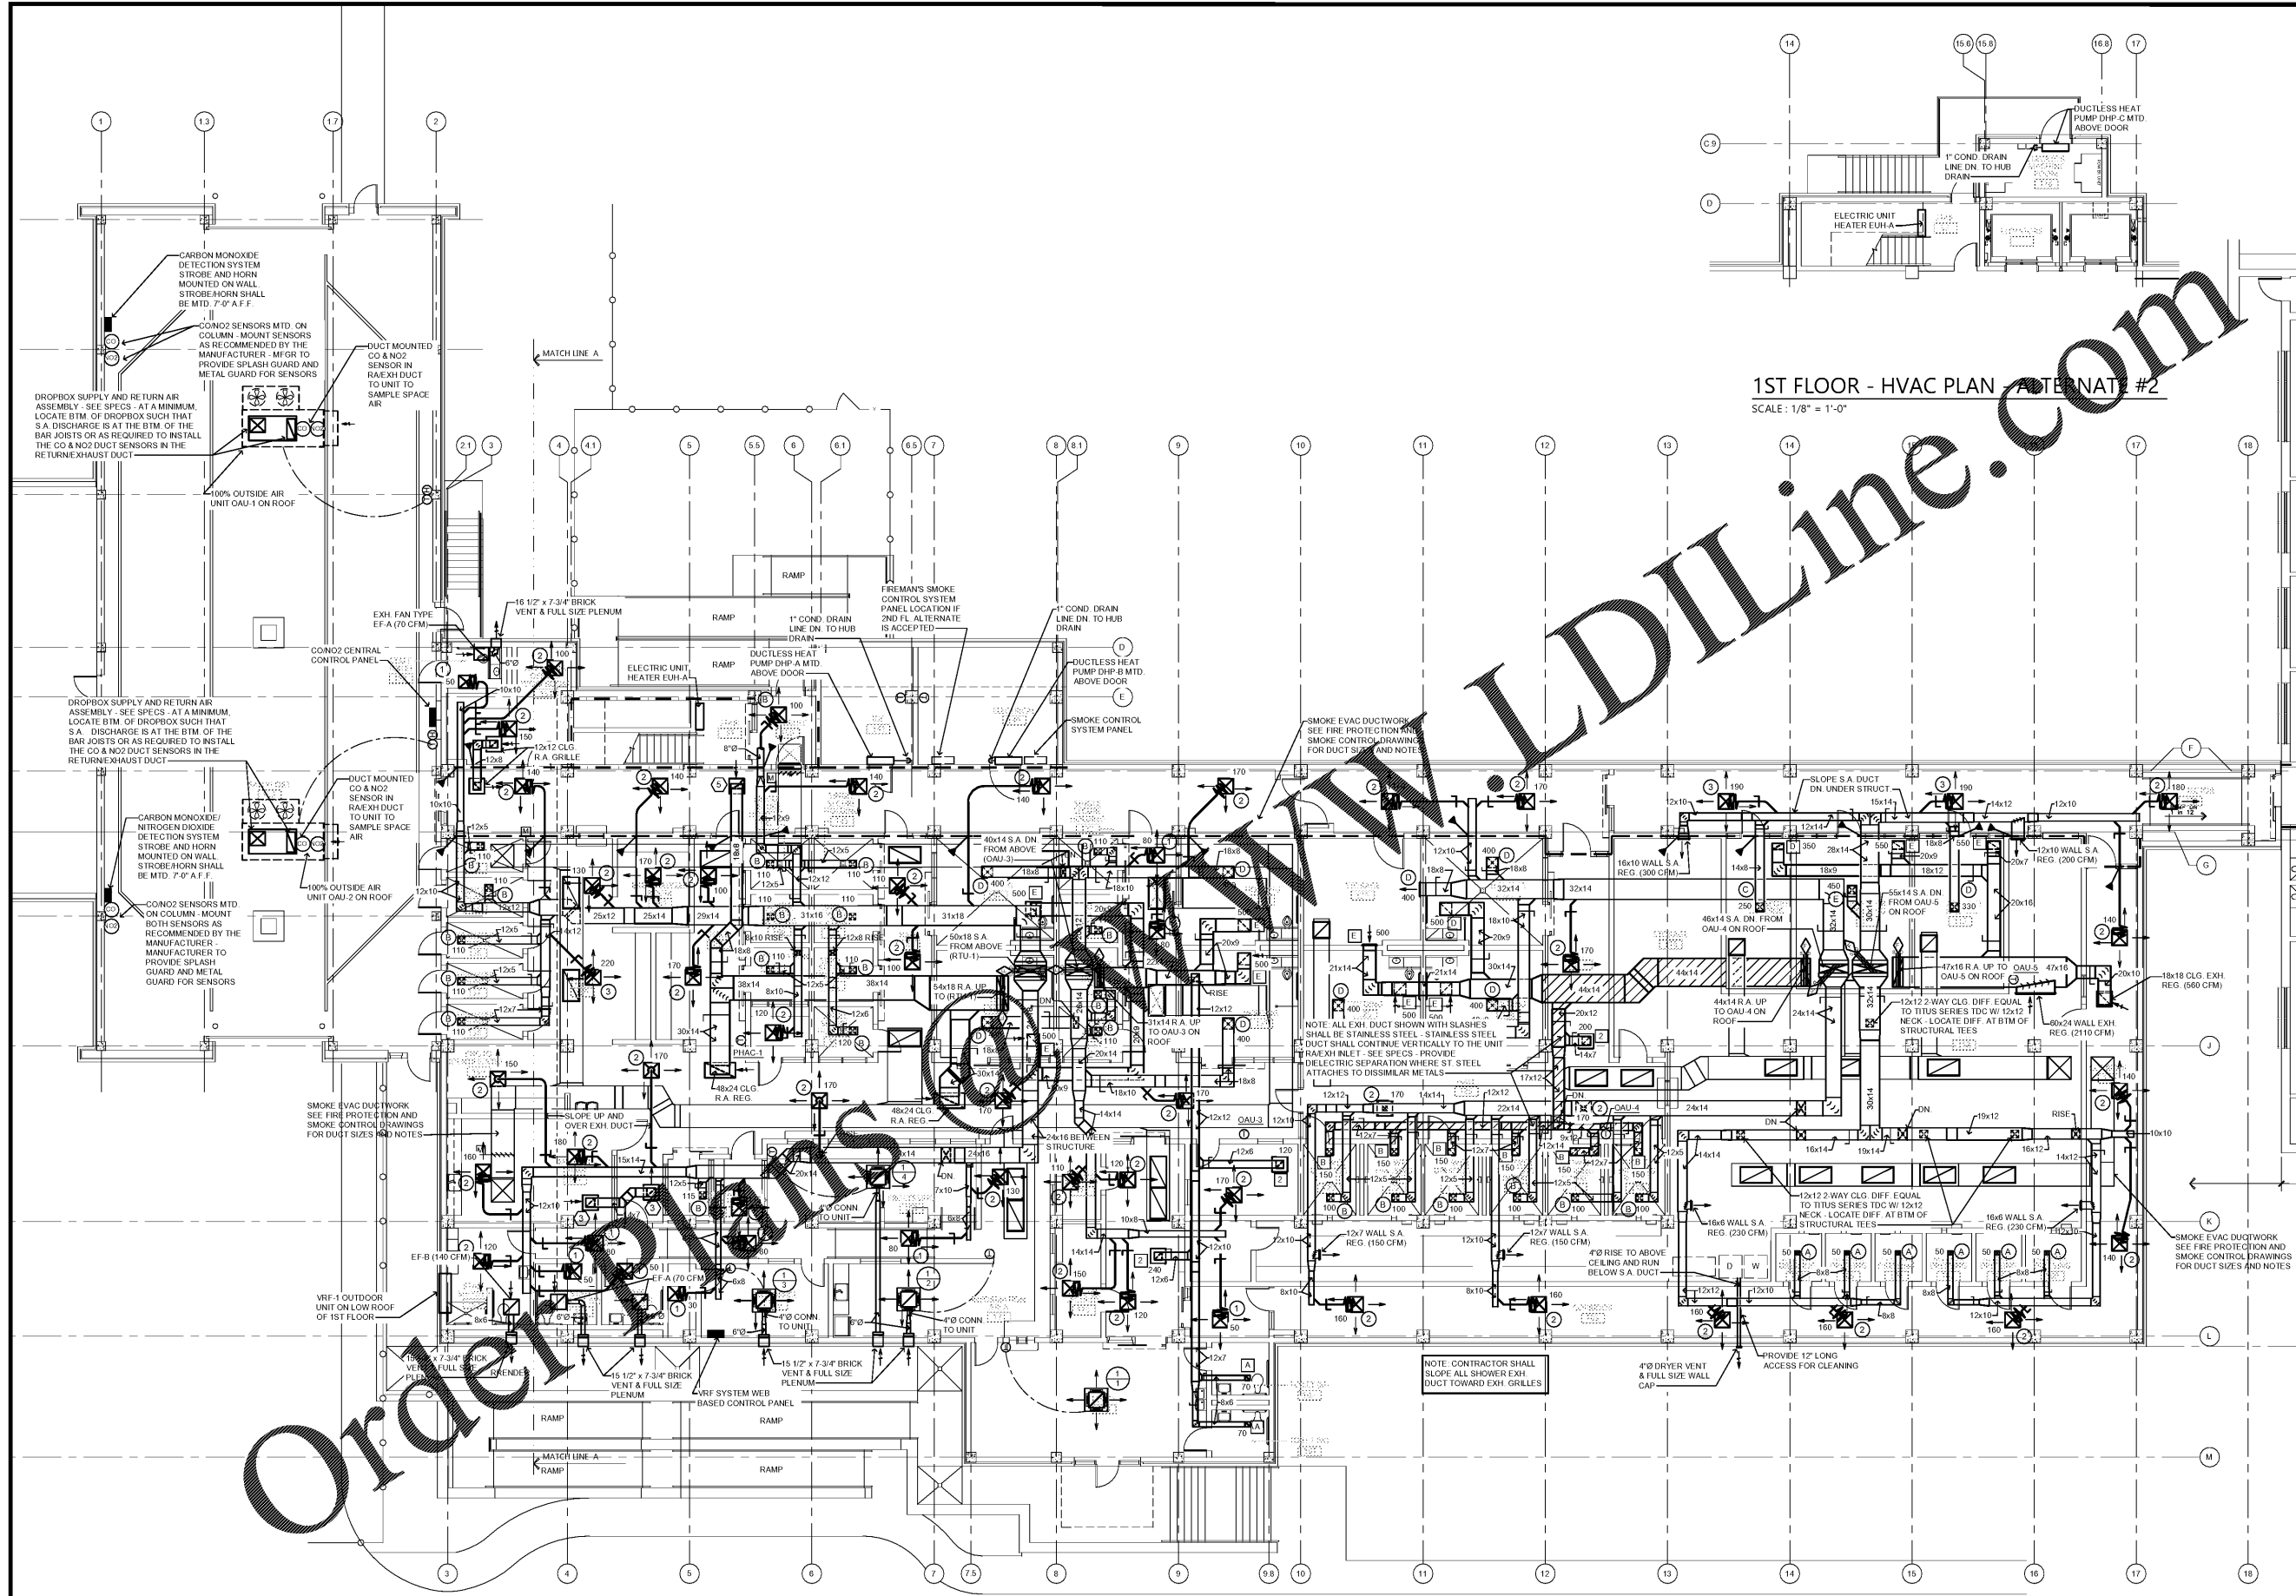

1ST FLOOR - HVAC PLAN - BASE BID  
SCALE: 1/8" = 1'-0"



architects inc.  
Montgomery, Alabama

CIP-2017-001  
UPGRADES TO THE MOBILE COUNTY METRO JAIL  
For The MOBILE COUNTY COMMISSION  
MOBILE, ALABAMA



DRAWN	CW	CHECK	TZ
DATE	APRIL 2, 2019 RTA		
REVISED			
REVISED			

SHEET TITLE	FIRST FLOOR HVAC PLAN - BASE BID
JOB NO.	PH&J#1801GV
SEQUENCE NO.	116 of 175

M1

ZGOUVAS, EIRING & ASSOCIATES  
CONSULTING ENGINEERS  
800 S. MOBILBOUGH STREET  
MONTGOMERY, AL 36104  
334.263-4406  
ZEA PROJECT NUMBER 18-166