


Order Plans

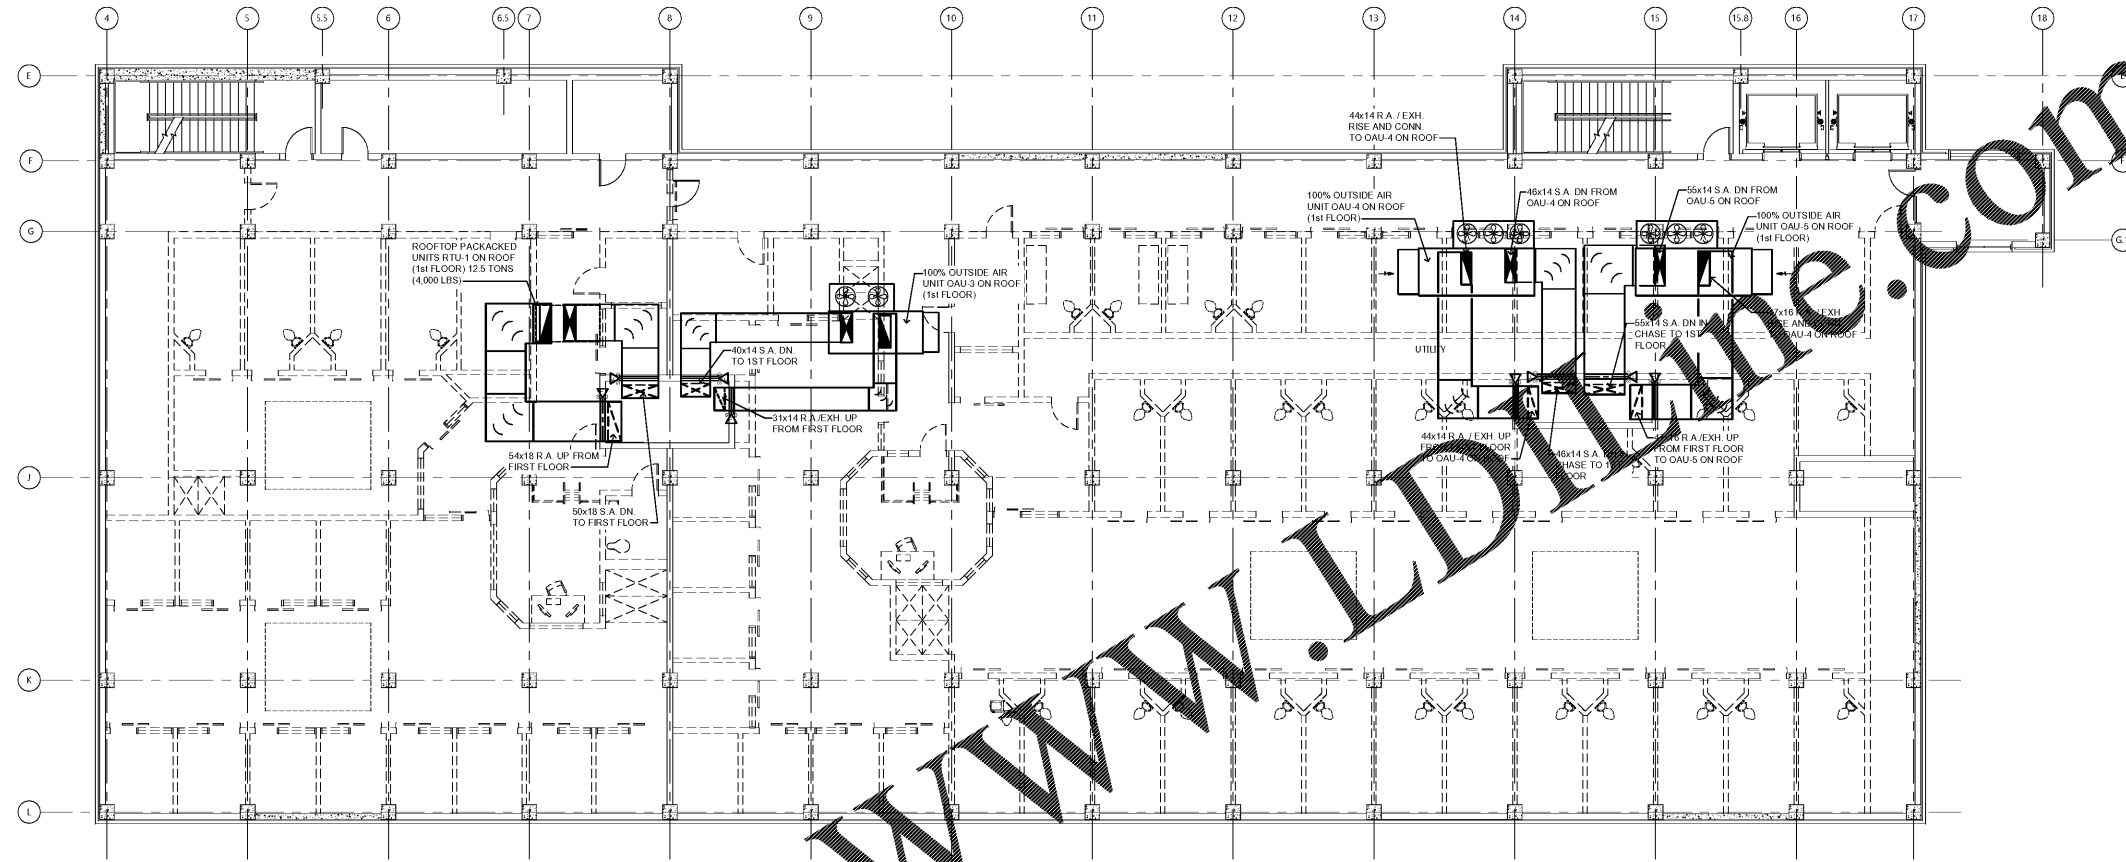

3rd FLOOR - HVAC PLAN - ALTERNATE #3

SCALE: 1/8" = 1'-0"



LEGEND

	MANUAL VOLUME DAMPER (MVD)		DUCT W/ RECTANGULAR SIZE
	MOTORIZED DAMPER (MD)		RECTANGULAR SUPPLY DUCT TURNING UP
	SMOKE DETECTOR		RECTANGULAR SUPPLY AIR DUCT TURNING DOWN
	DENOTES LOCATION OF VERTICAL ACTION FIRE DAMPER		RECTANGULAR RETURN AIR OR EXHAUST DUCT TURNING UP
	DENOTES LOCATION OF HORIZONTAL ACTION FIRE DAMPER		RECTANGULAR RETURN AIR OR EXHAUST DUCT TURNING DOWN
	DENOTES LOCATION OF HORIZONTAL ACTION FIRE / SMOKE DAMPER		RECTANGULAR SUPPLY AIR DUCT FLOOR OR ROOF PENETRATION
	DENOTES LOCATION OF VERTICAL ACTION FIRE / SMOKE DAMPER		RECTANGULAR RETURN OR EXHAUST AIR DUCT FLOOR OR ROOF PENETRATION
	CONNECT TO EXISTING		AIR TRANSFER DUCT
	CEILING DIFFUSER		AUXILIARY DRAIN
	RETURN AIR GRILLE/REGISTER		THERMOSTAT
	EXHAUST AIR GRILLE/REGISTER		HUMIDISTAT
	CEILING DIFFUSER DESIGNATOR		ABOVE FINISH FLOOR
	RETURN AIR GRILLE/REGISTER		CEILING DIFFUSER
	EXHAUST AIR GRILLE/REGISTER		CEILING OR COOLING
			CONNECT OR CONNECTION
			RETURN AIR
			SUPPLY AIR
			FACTORY FABRICATED AND INSULATED DOUBLE WALL DUCT


CIP-2017-001
UPGRADES TO THE MOBILE COUNTY METRO JAIL
For The MOBILE COUNTY COMMISSION
MOBILE, ALABAMA



DRAWN	CW	CHECK	TZ
DATE	APRIL 2, 2019 RTA		
REVISED			
REVISED			
SHEET TITLE			
3rd FLOOR HVAC PLAN - ALTERNATE #3			
JOB NO.			
PH&J#1801GV			
SEQUENCE NO.			
118 of 175			

ZGOUVAS, EIRING & ASSOCIATES
CONSULTING ENGINEERS
800 S. MONROUE STREET
MONTGOMERY, AL 36104
334.263-4406
ZEA PROJECT NUMBER 18-166

architects inc.
Montgomery, Alabama

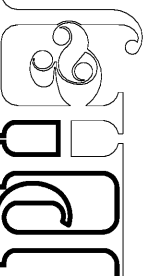

M3