



Order Plans @

WWW.LDILLINE.COM

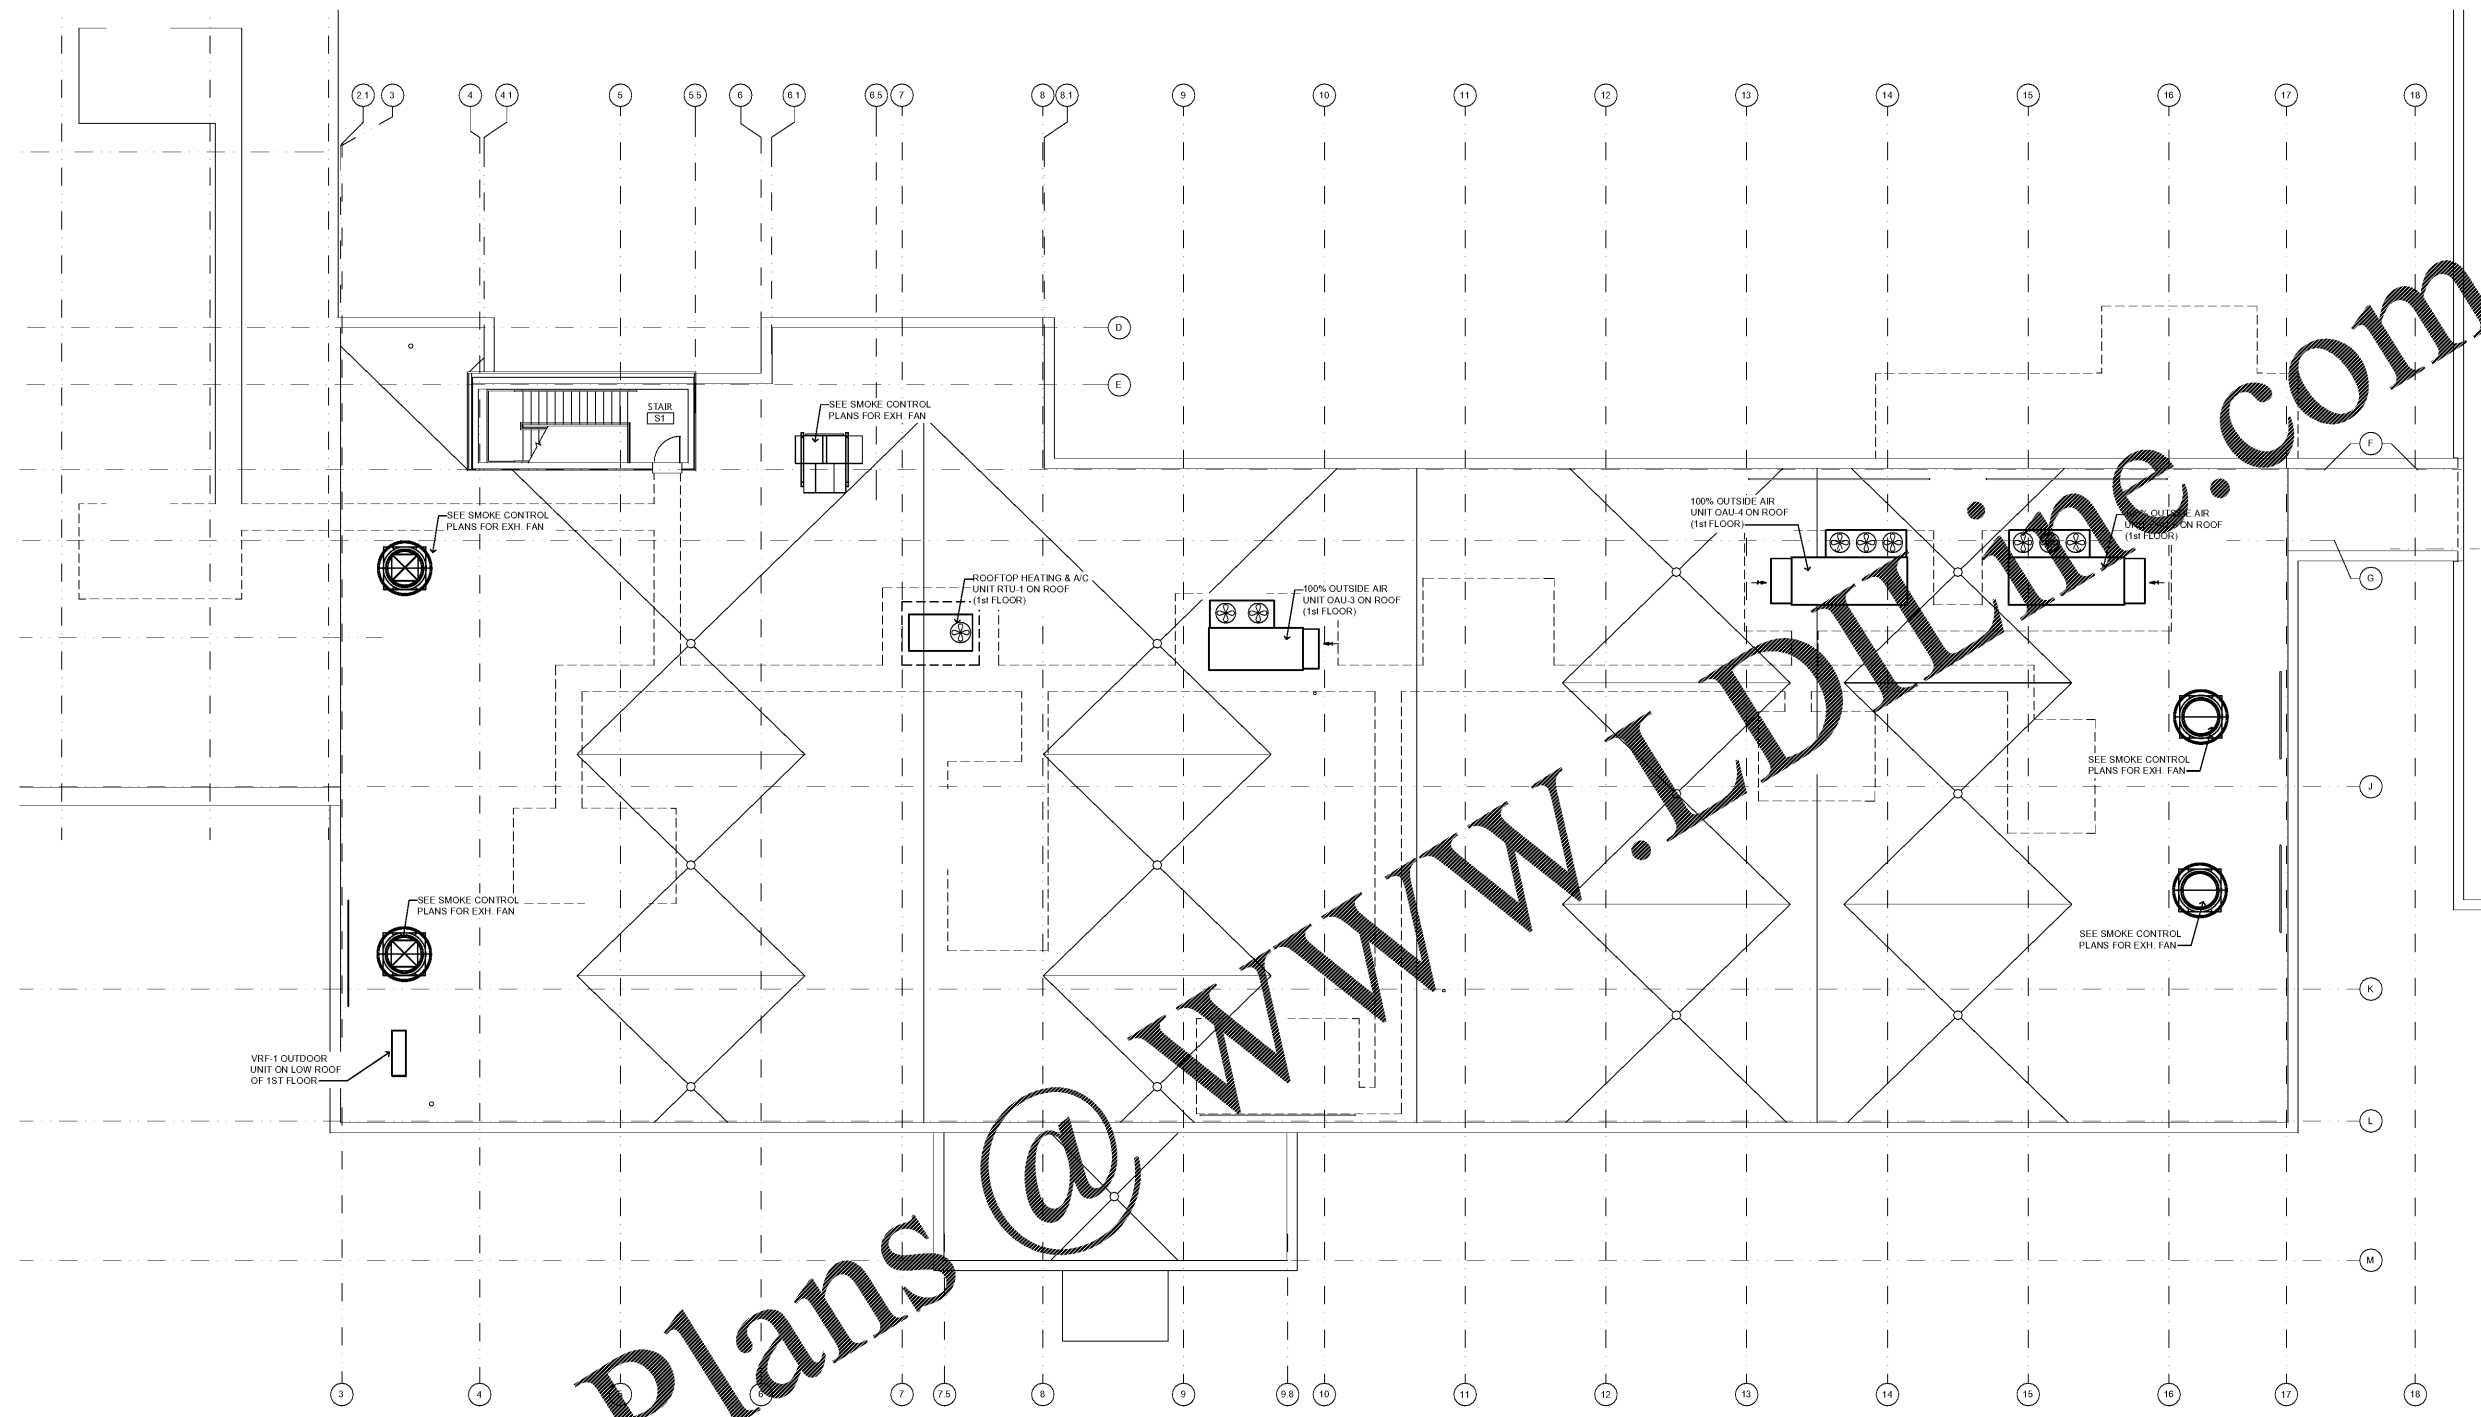

HVAC BASE BID ROOF PLAN
 SCALE: 1/8" = 1'-0"
 0 2 4 8 16 32
 Graphic Scale

architects inc.
 Montgomery, Alabama

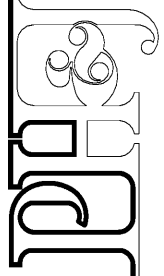

CIP-2017-001
 UPGRADES TO THE MOBILE COUNTY METRO JAIL
 For The MOBILE COUNTY COMMISSION
 MOBILE, ALABAMA



DRAWN	CW	CHECK	TZ
DATE	APRIL 2, 2019 RTA		
REVISED			
REVISED			
SHEET TITLE			
HVAC ROOF PLAN - BASE BID			
JOB NO.			
PH&J#1801GV			
SEQUENCE NO.			
119 of 175			



M4