


Order Plans

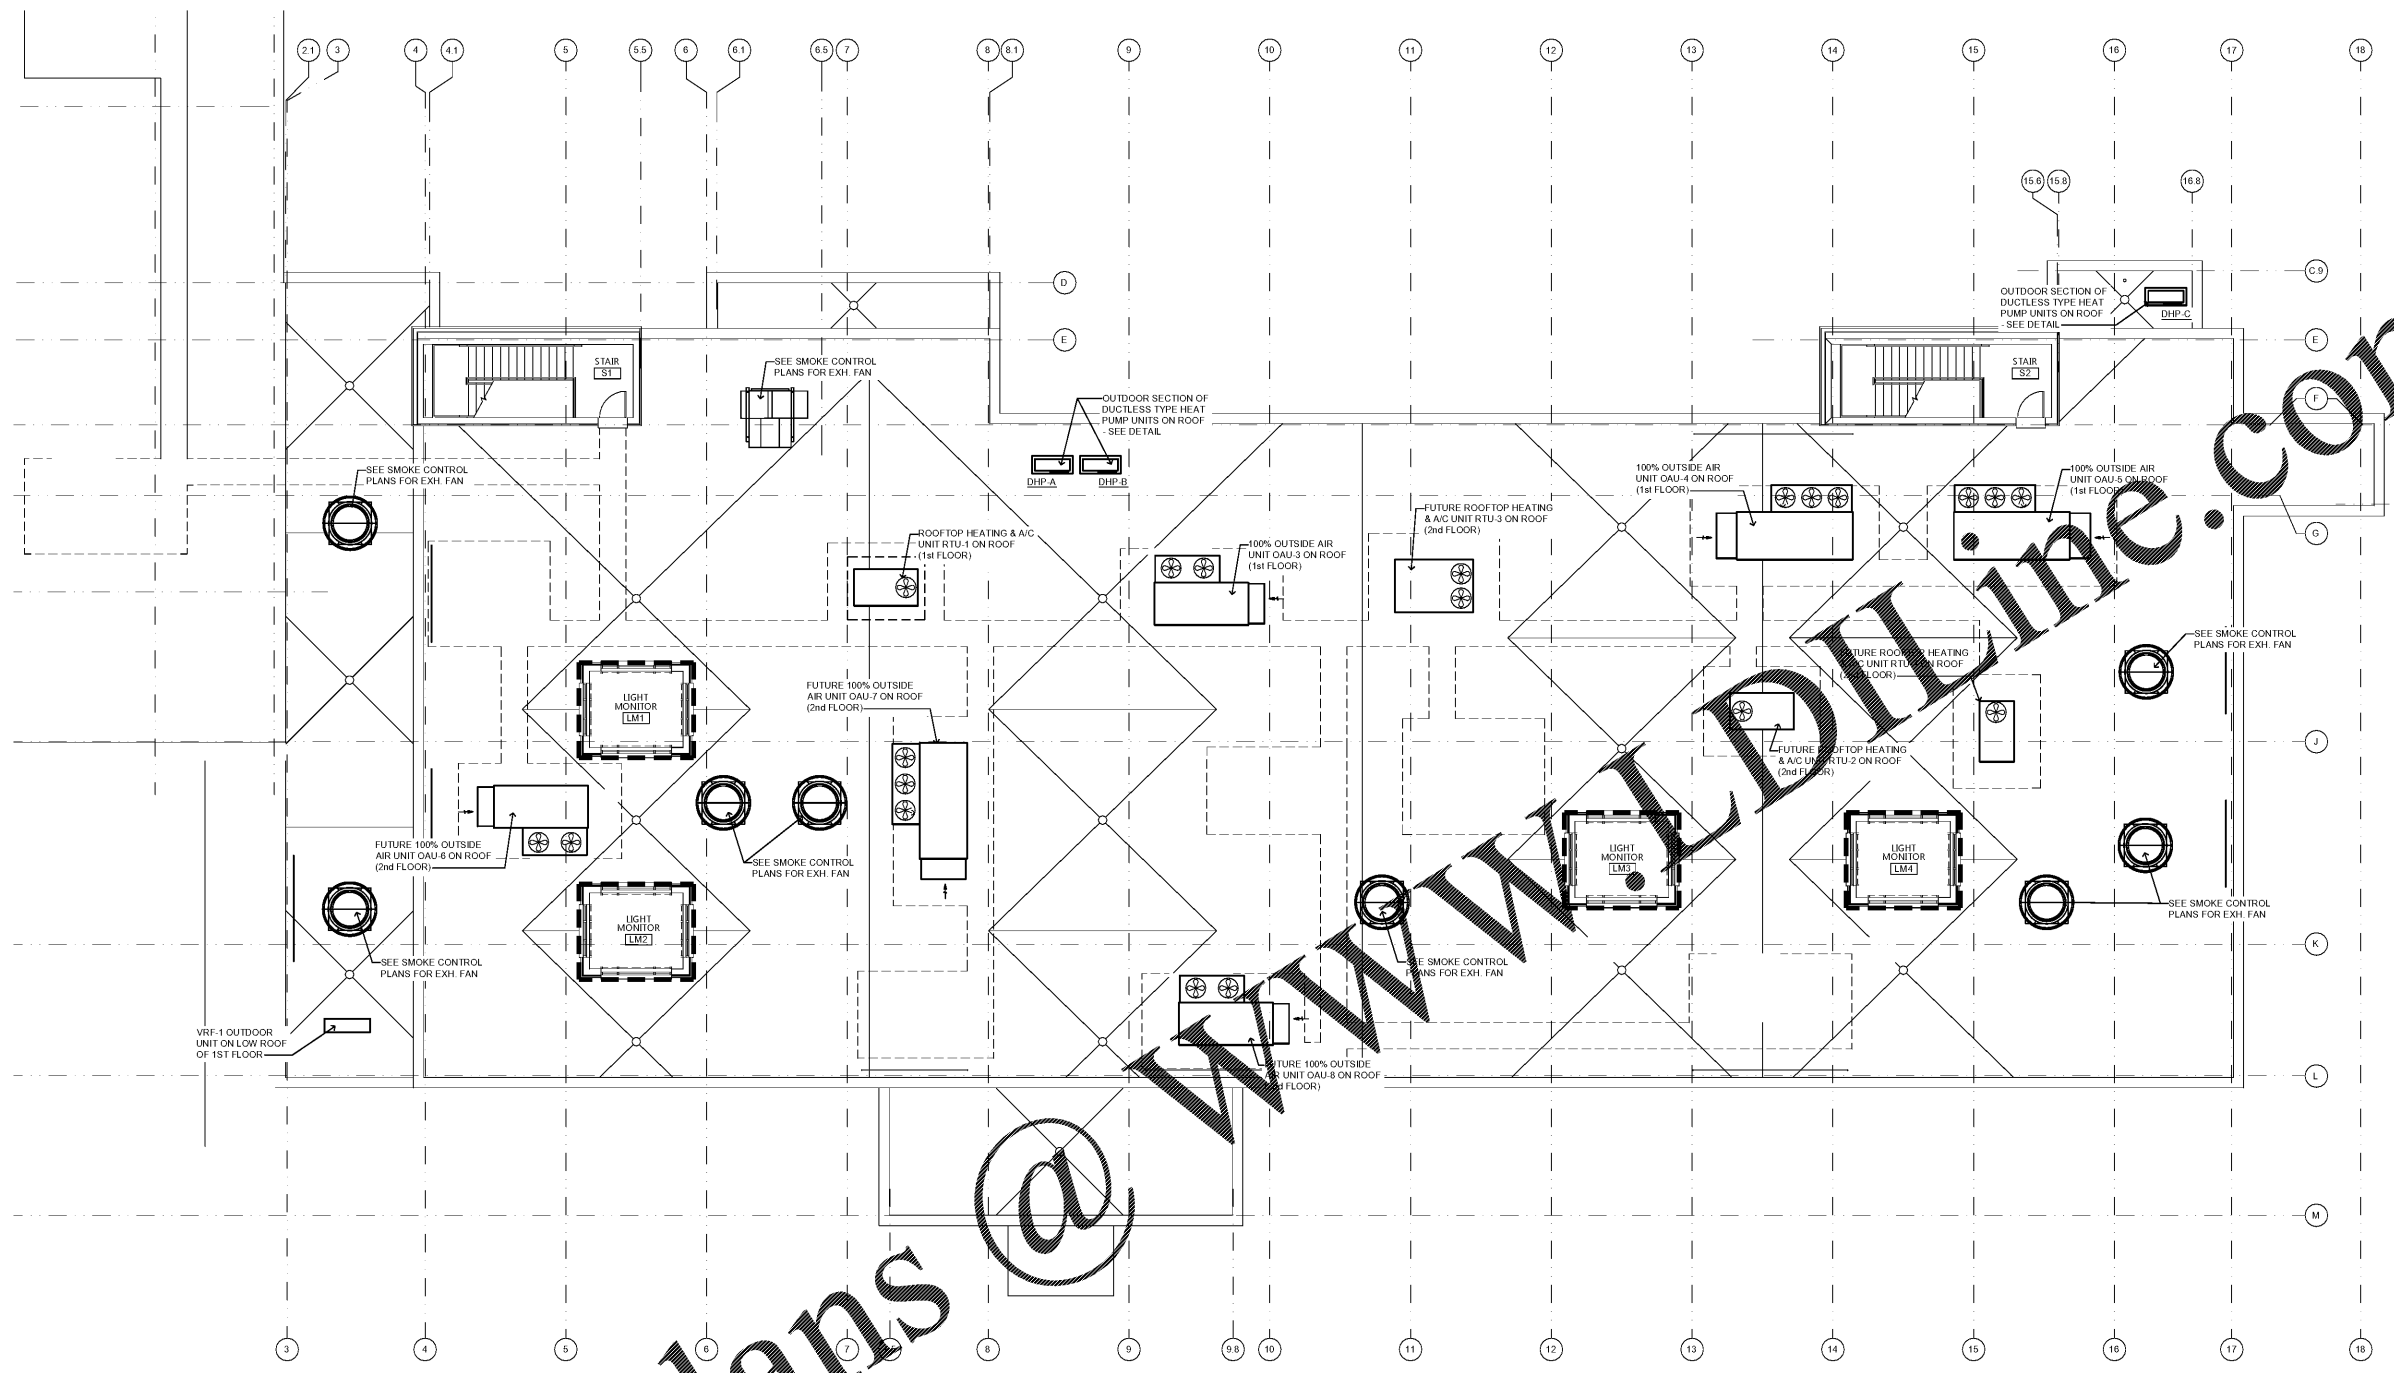


**HVAC ALTERNATE #2 ROOF PLAN**

SCALE: 1/8" = 1'-0"

NOTE: LIGHT MONITORS ONLY OCCUR UNDER ALTERNATE NO.3



architects inc.  
Montgomery, Alabama

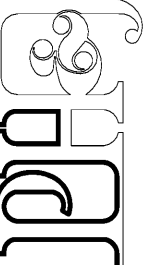

CIP-2017-001  
UPGRADES TO THE MOBILE COUNTY METRO JAIL  
For The MOBILE COUNTY COMMISSION  
MOBILE, ALABAMA



DRAWN	CW	CHECK	TZ
DATE	APRIL 2, 2019 RTA		
REVISED			
REVISED			
SHEET TITLE			
HVAC ROOF PLAN - ALTERNATE 2			
JOB NO.			
PH&J#1801GV			
SEQUENCE NO.			
120 of 175			



ZGOUVAS, EIRING & ASSOCIATES  
CONSULTING ENGINEERS  
800 S. MONROUEUX STREET  
MONTGOMERY, AL 36104  
334.263-4406  
ZEA PROJECT NUMBER 18-166

M5