

CIP-2017-001
UPGRADES TO THE MOBILE COUNTY METRO JAIL
For The MOBILE COUNTY COMMISSION
MOBILE, ALABAMA




| | | | |
|----------------------------------|-------------------|-------|----|
| DRAWN | CW | CHECK | TZ |
| DATE | APRIL 2, 2019 RTA | | |
| REVISED | | | |
| REVISED | | | |
| SHEET TITLE | | | |
| FIRST FLOOR PLAN - SMOKE CONTROL | | | |
| JOB NO. | | | |
| PH&J#1801GV | | | |
| SEQUENCE NO. | | | |
| 131 of 175 | | | |

SC.2.1

ZGOUVAS, EIRING & ASSOCIATES
CONSULTING ENGINEERS
800 S. MONROUEUX STREET
MONTGOMERY, AL. 36104
334.263-4408
334.263-4409
ZEA PROJECT NUMBER 18-166

1ST FLOOR - SMOKE CONTROL

SCALE: 1/8" = 1'-0" FIN FLOOR ELEV = 14.0'

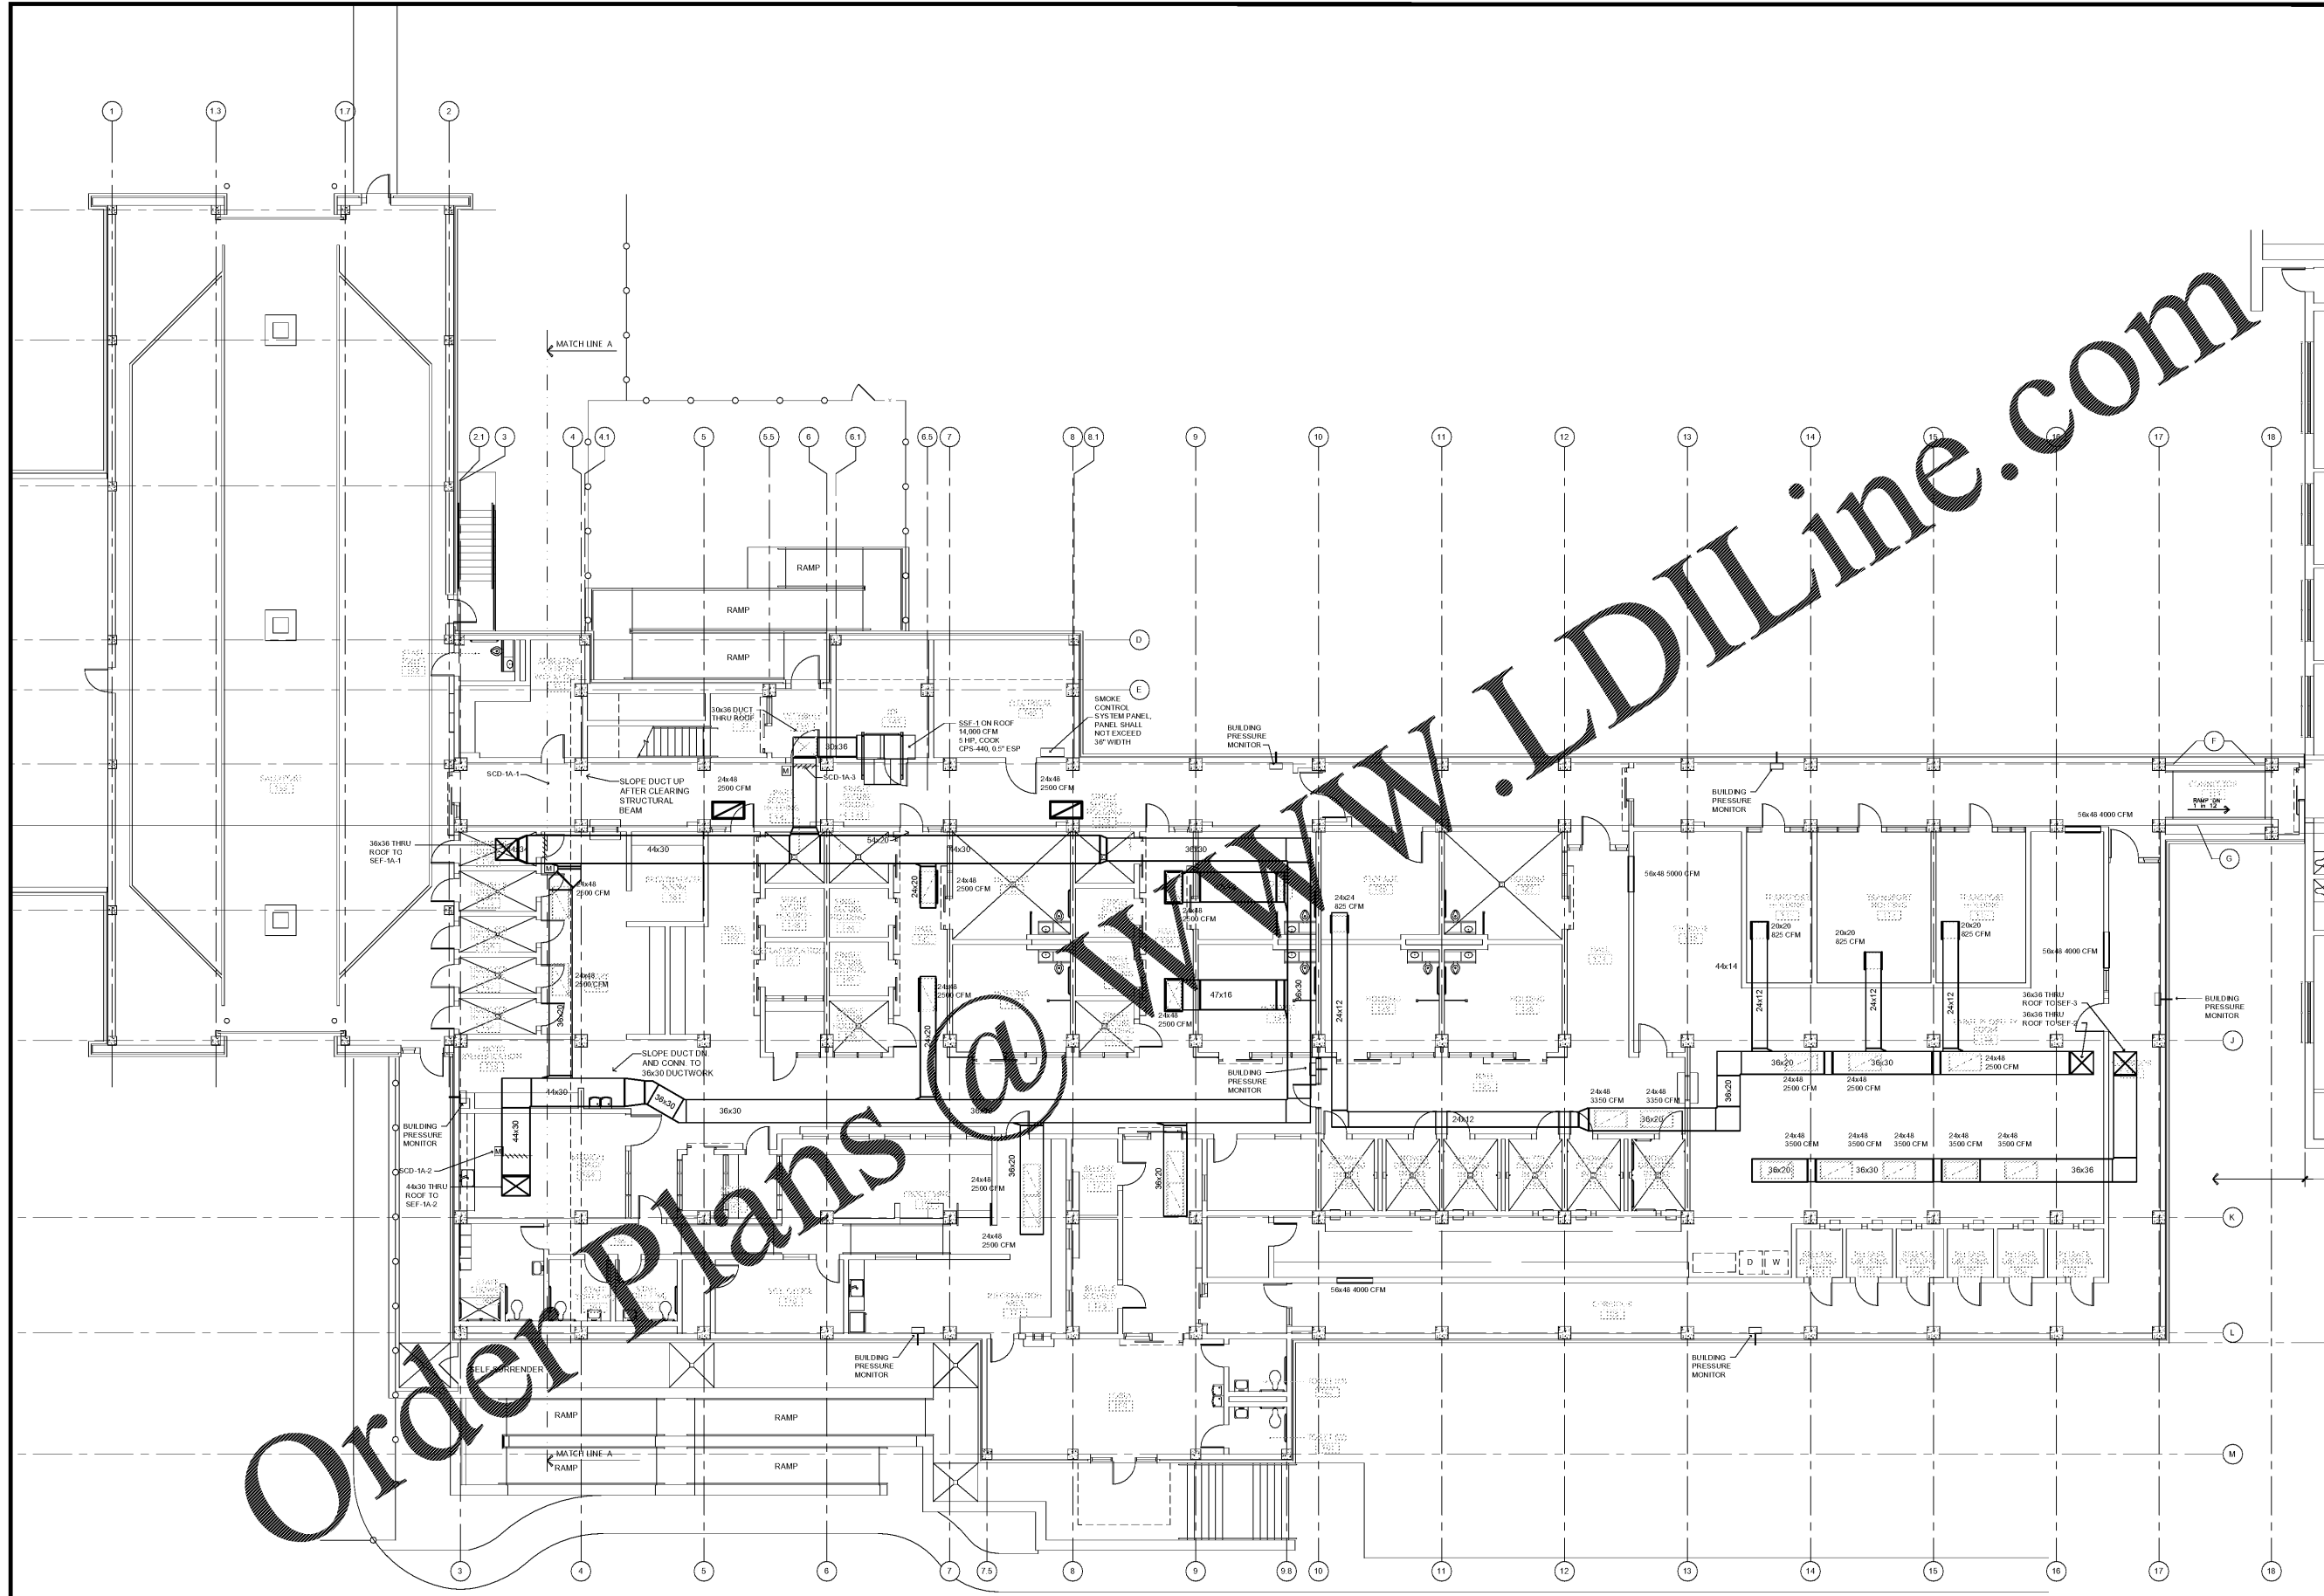

Order Plans @ www.LDILine.com