

CIP-2017-001  
UPGRADES TO THE MOBILE COUNTY METRO JAIL  
For The MOBILE COUNTY COMMISSION  
MOBILE, ALABAMA




DRAWN: CW CHECK: TZ  
DATE: APRIL 2, 2019 RTA  
REVISED:  
REVISED:

SHEET TITLE:  
SECOND FLOOR PLAN -  
ALTERNATE #2 - SMOKE  
CONTROL

JOB NO.:  
PH&J#1801GV

SEQUENCE  
NO. 132 OF 175

SC.2.2

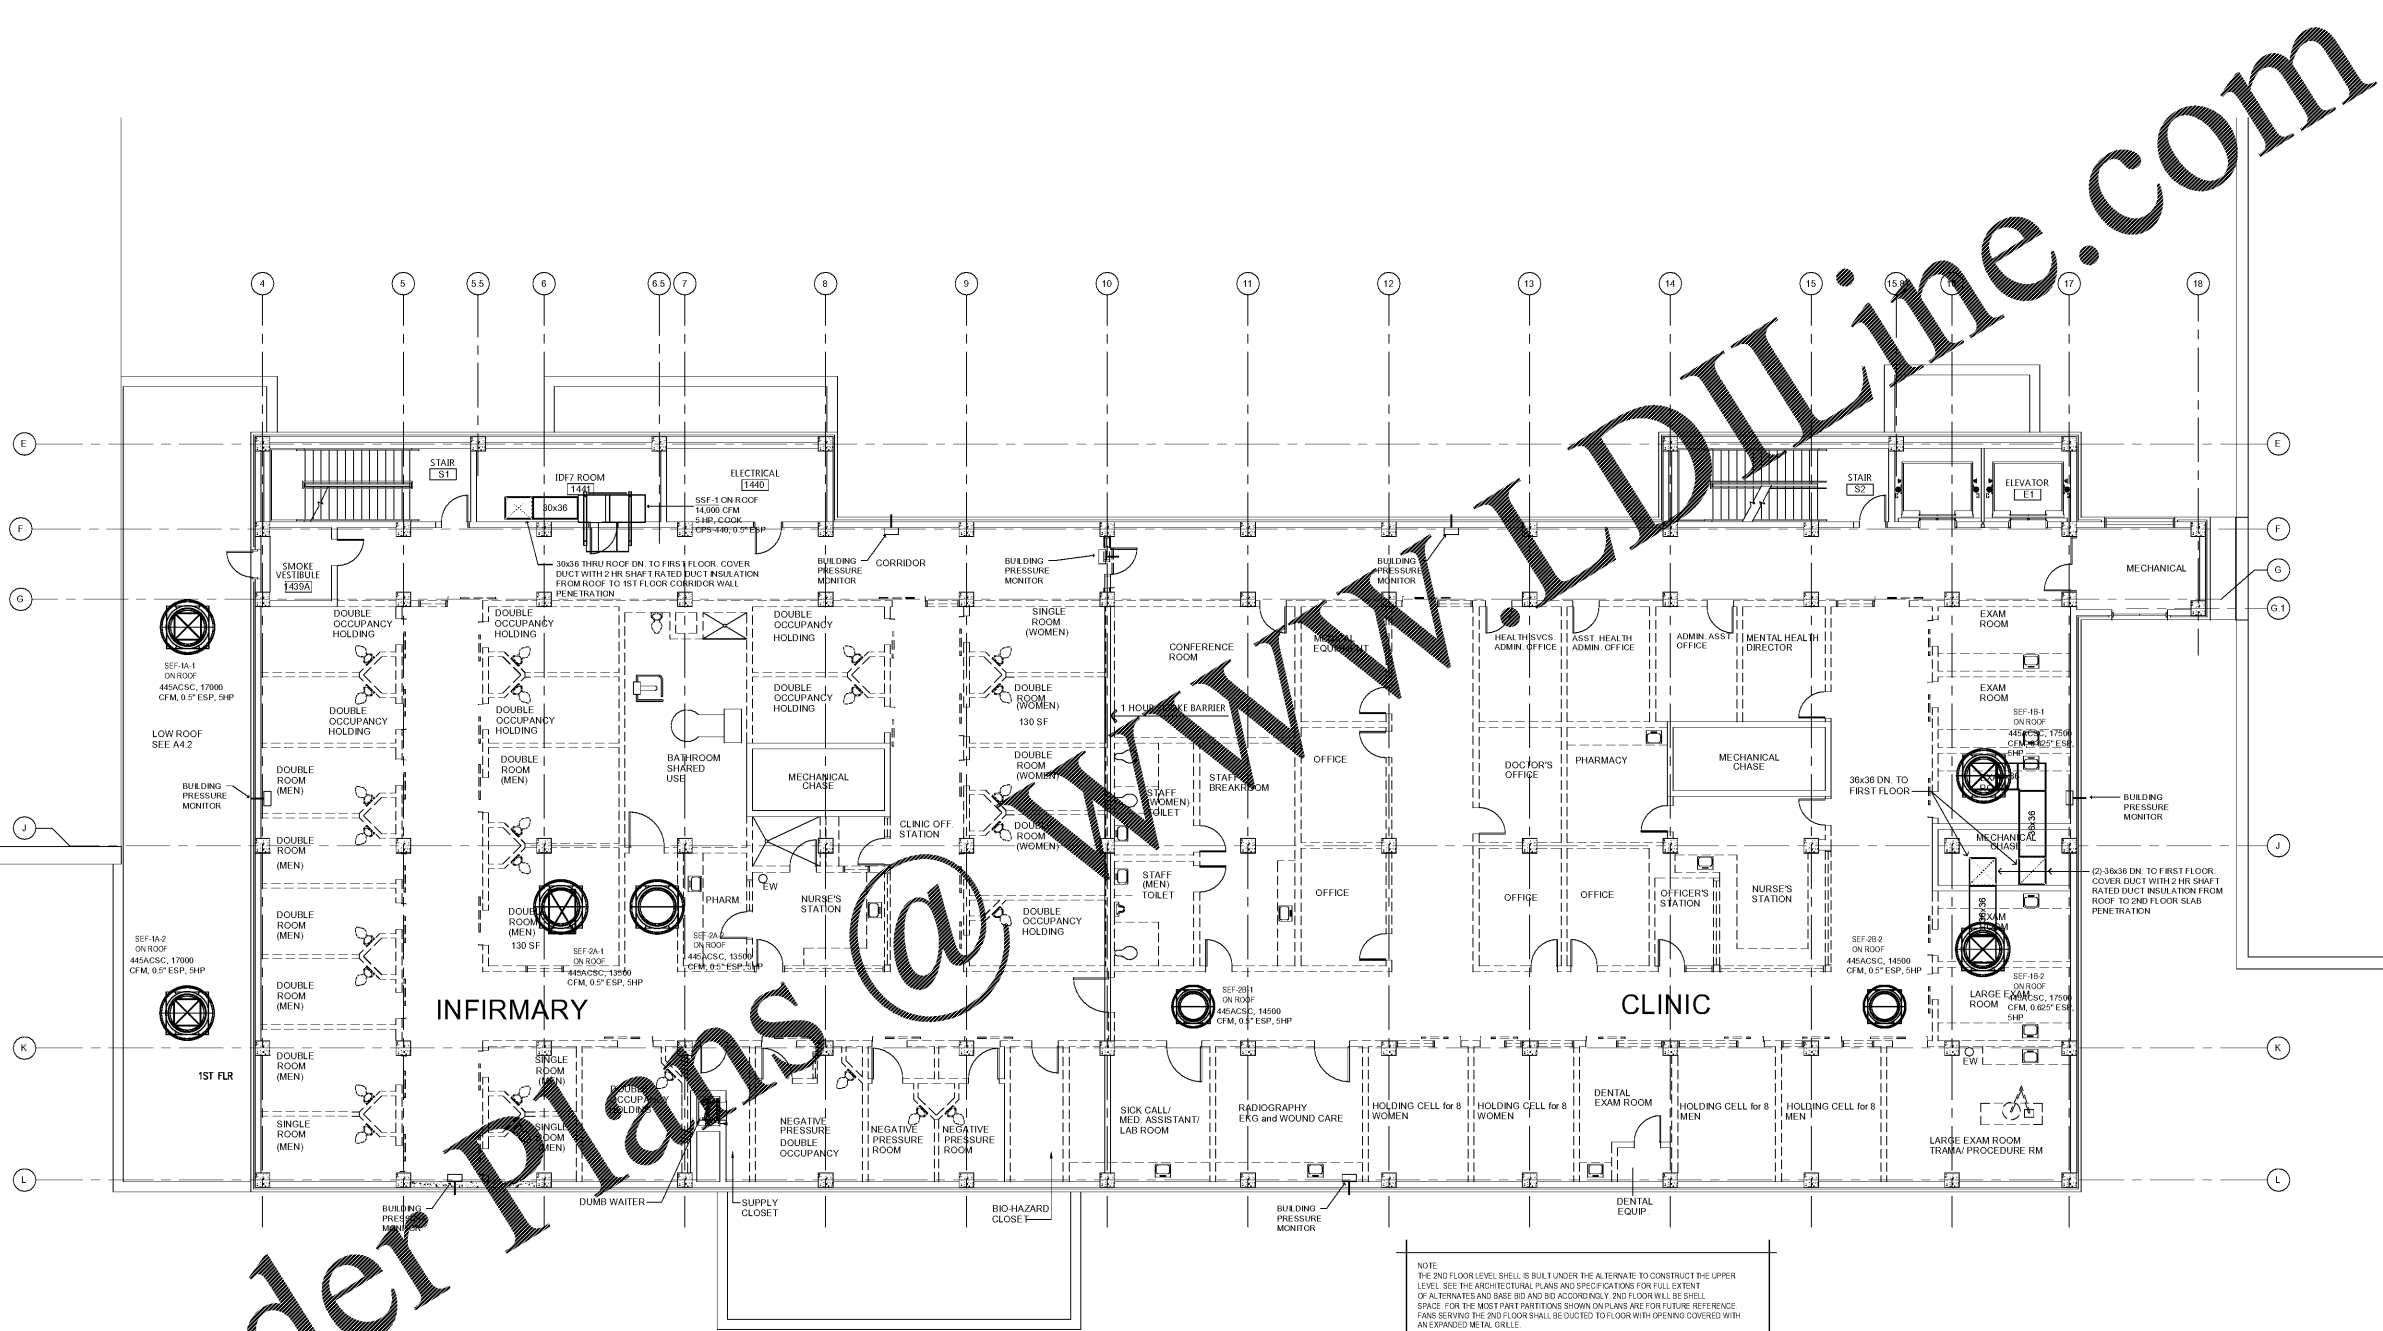

Order Plans @ [www.wldline.com](mailto:www.wldline.com)

2ND FLOOR (ALTERNATE #2) - SMOKE CONTROL  
SCALE: 1/8" = 1'-0" FIN FLOOR ELEV = 14.0'  
Graphic Scale