

CIP-2017-001
UPGRADES TO THE MOBILE COUNTY METRO JAIL
For The MOBILE COUNTY COMMISSION
MOBILE, ALABAMA



DRAWN CW CHECK TZ
DATE APRIL 2, 2019 RTA
REVISED
REVISED

SHEET TITLE
THIRD FLOOR PLAN ALTERNATE #3 - SMOKE CONTROL


JOB NO.
PH&J#1801GV

SEQUENCE NO. 133 OF 175

SC2.3




800 S. MCDONOUGH STREET
MONTGOMERY, AL. 36104
334.263-4406
ZEA PROJECT NUMBER 18-166

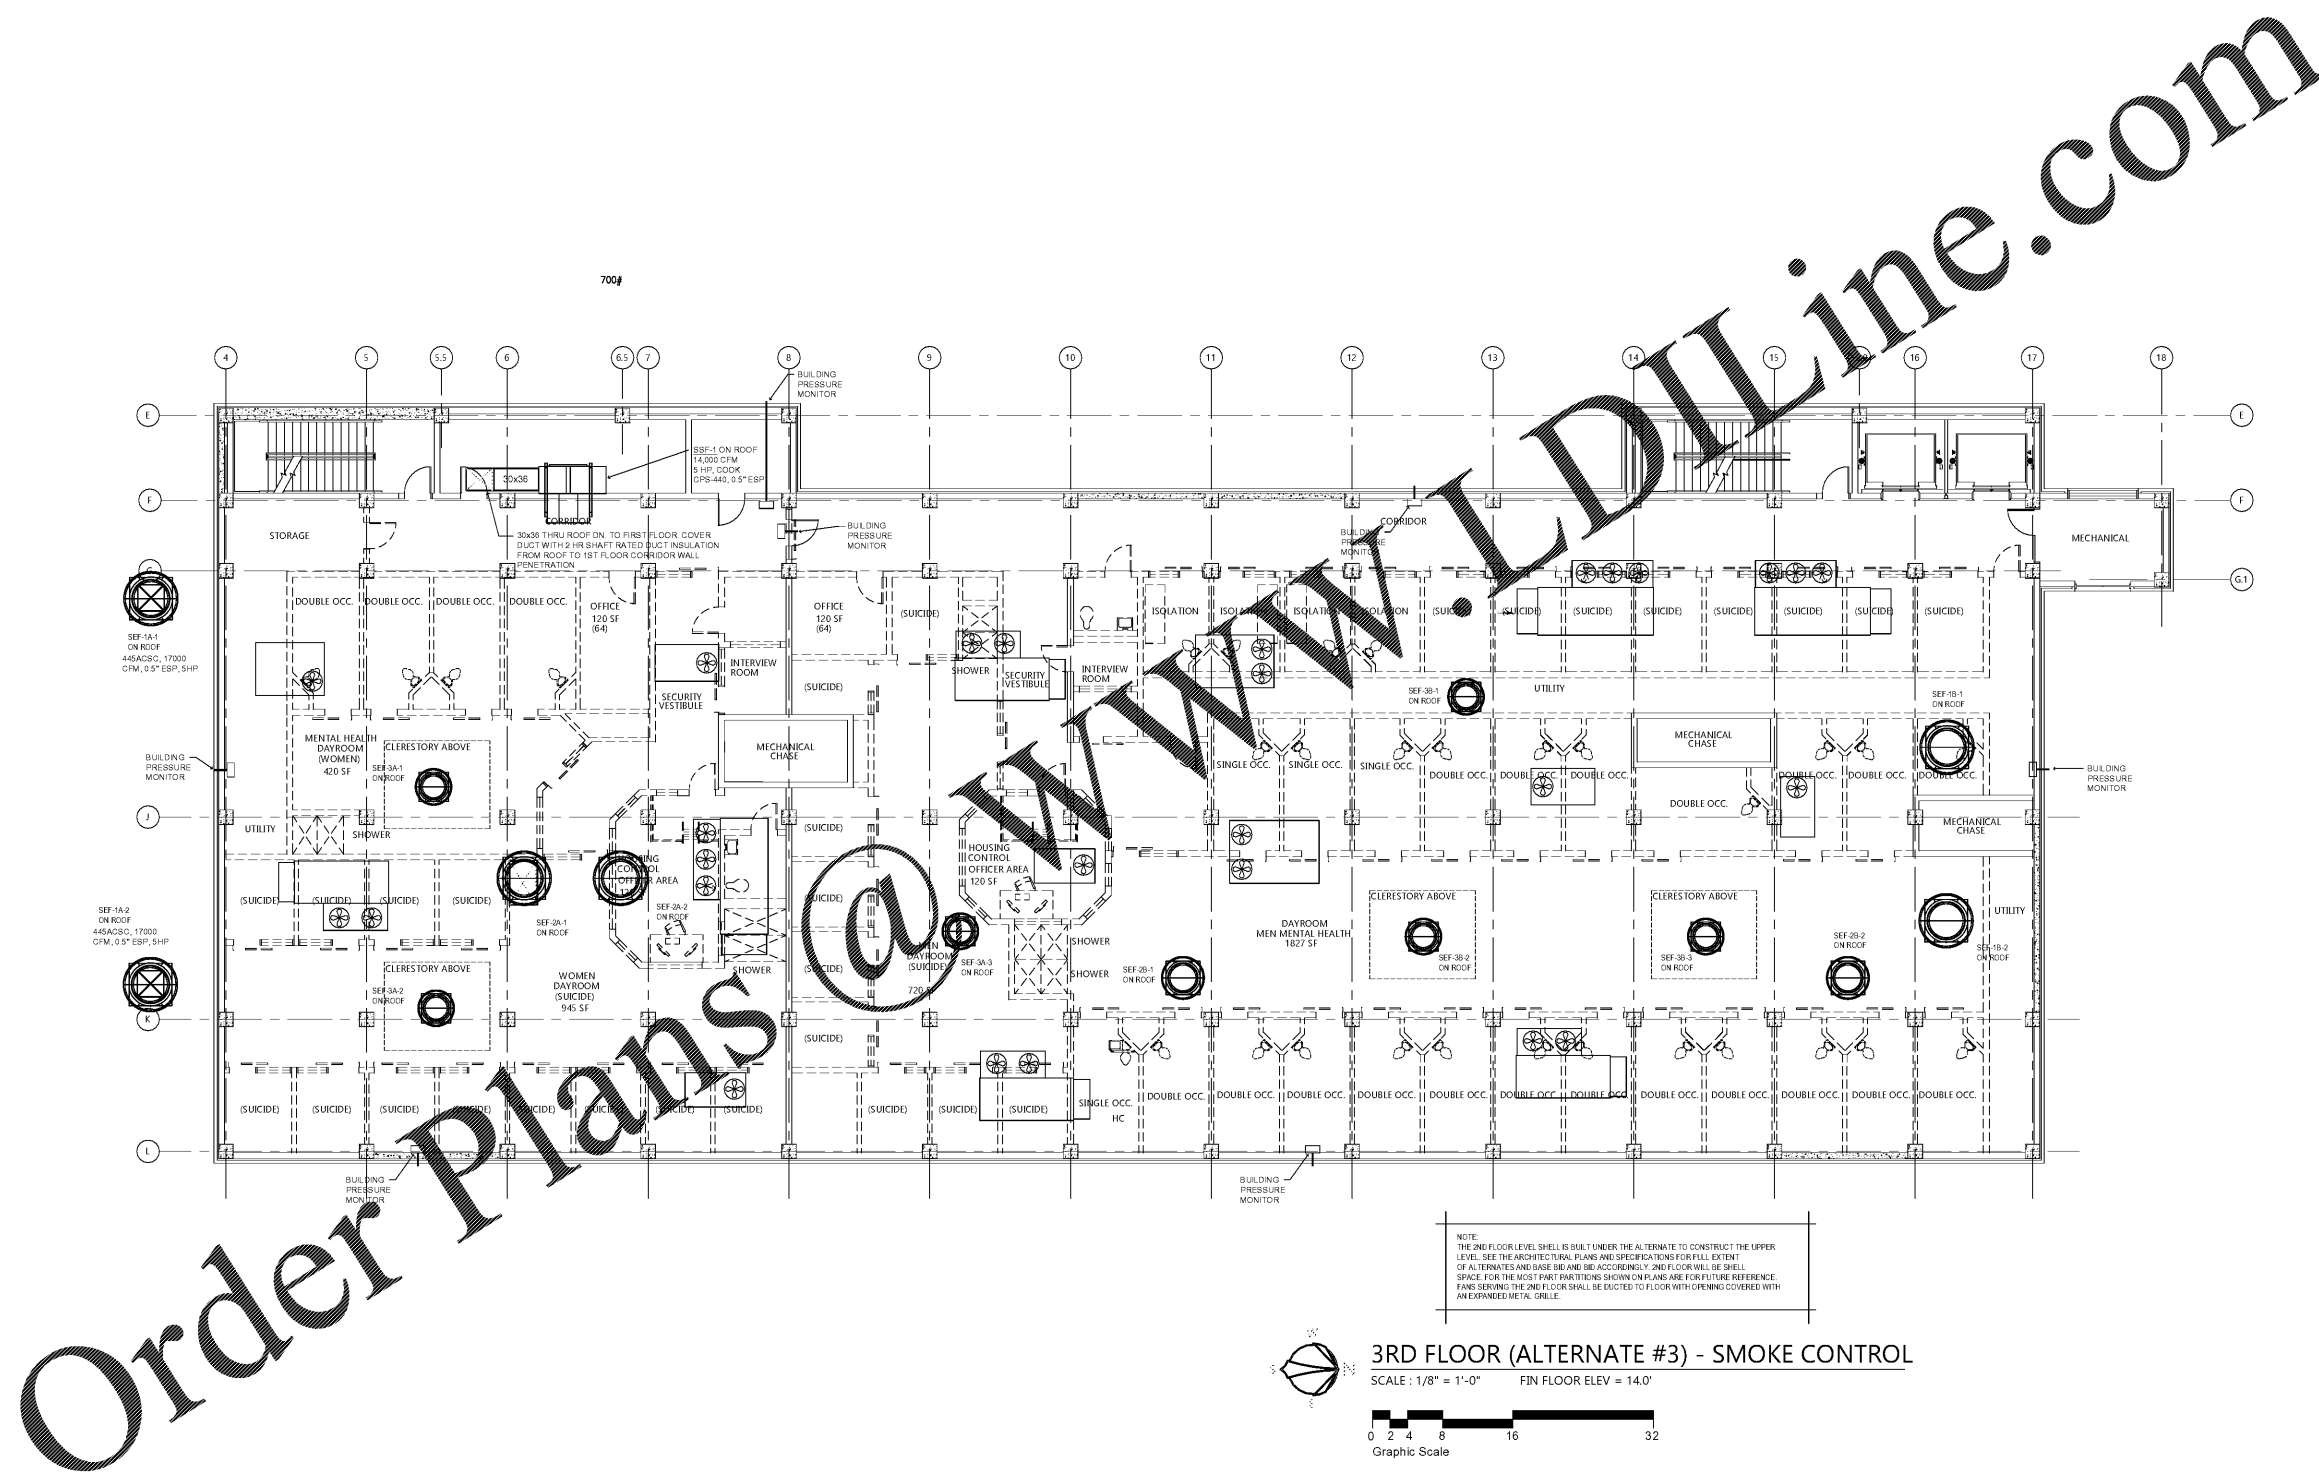

3RD FLOOR (ALTERNATE #3) - SMOKE CONTROL

 SCALE: 1/8" = 1'-0" FIN FLOOR ELEV = 14.0'



NOTE:
THE 2ND FLOOR LEVEL SHELL IS BUILT UNDER THE ALTERNATE TO CONSTRUCT THE UPPER LEVEL. SEE THE ARCHITECTURAL PLANS AND SPECIFICATIONS FOR FULL EXTENT OF ALTERNATES AND BASE SHELL. SEE ACCORDINGLY. 2ND FLOOR WILL BE SHELL SPACE FOR THE MOST PART PARTITIONS SHOWN ON PLANS ARE FOR FUTURE REFERENCE. FANS SERVING THE 2ND FLOOR SHALL BE EXCISED TO FLOOR WITH OPENING COVERED WITH AN EXTENDED METAL GRILLE.

Order Plans