



Order Plans @ WWW.LDILine.com

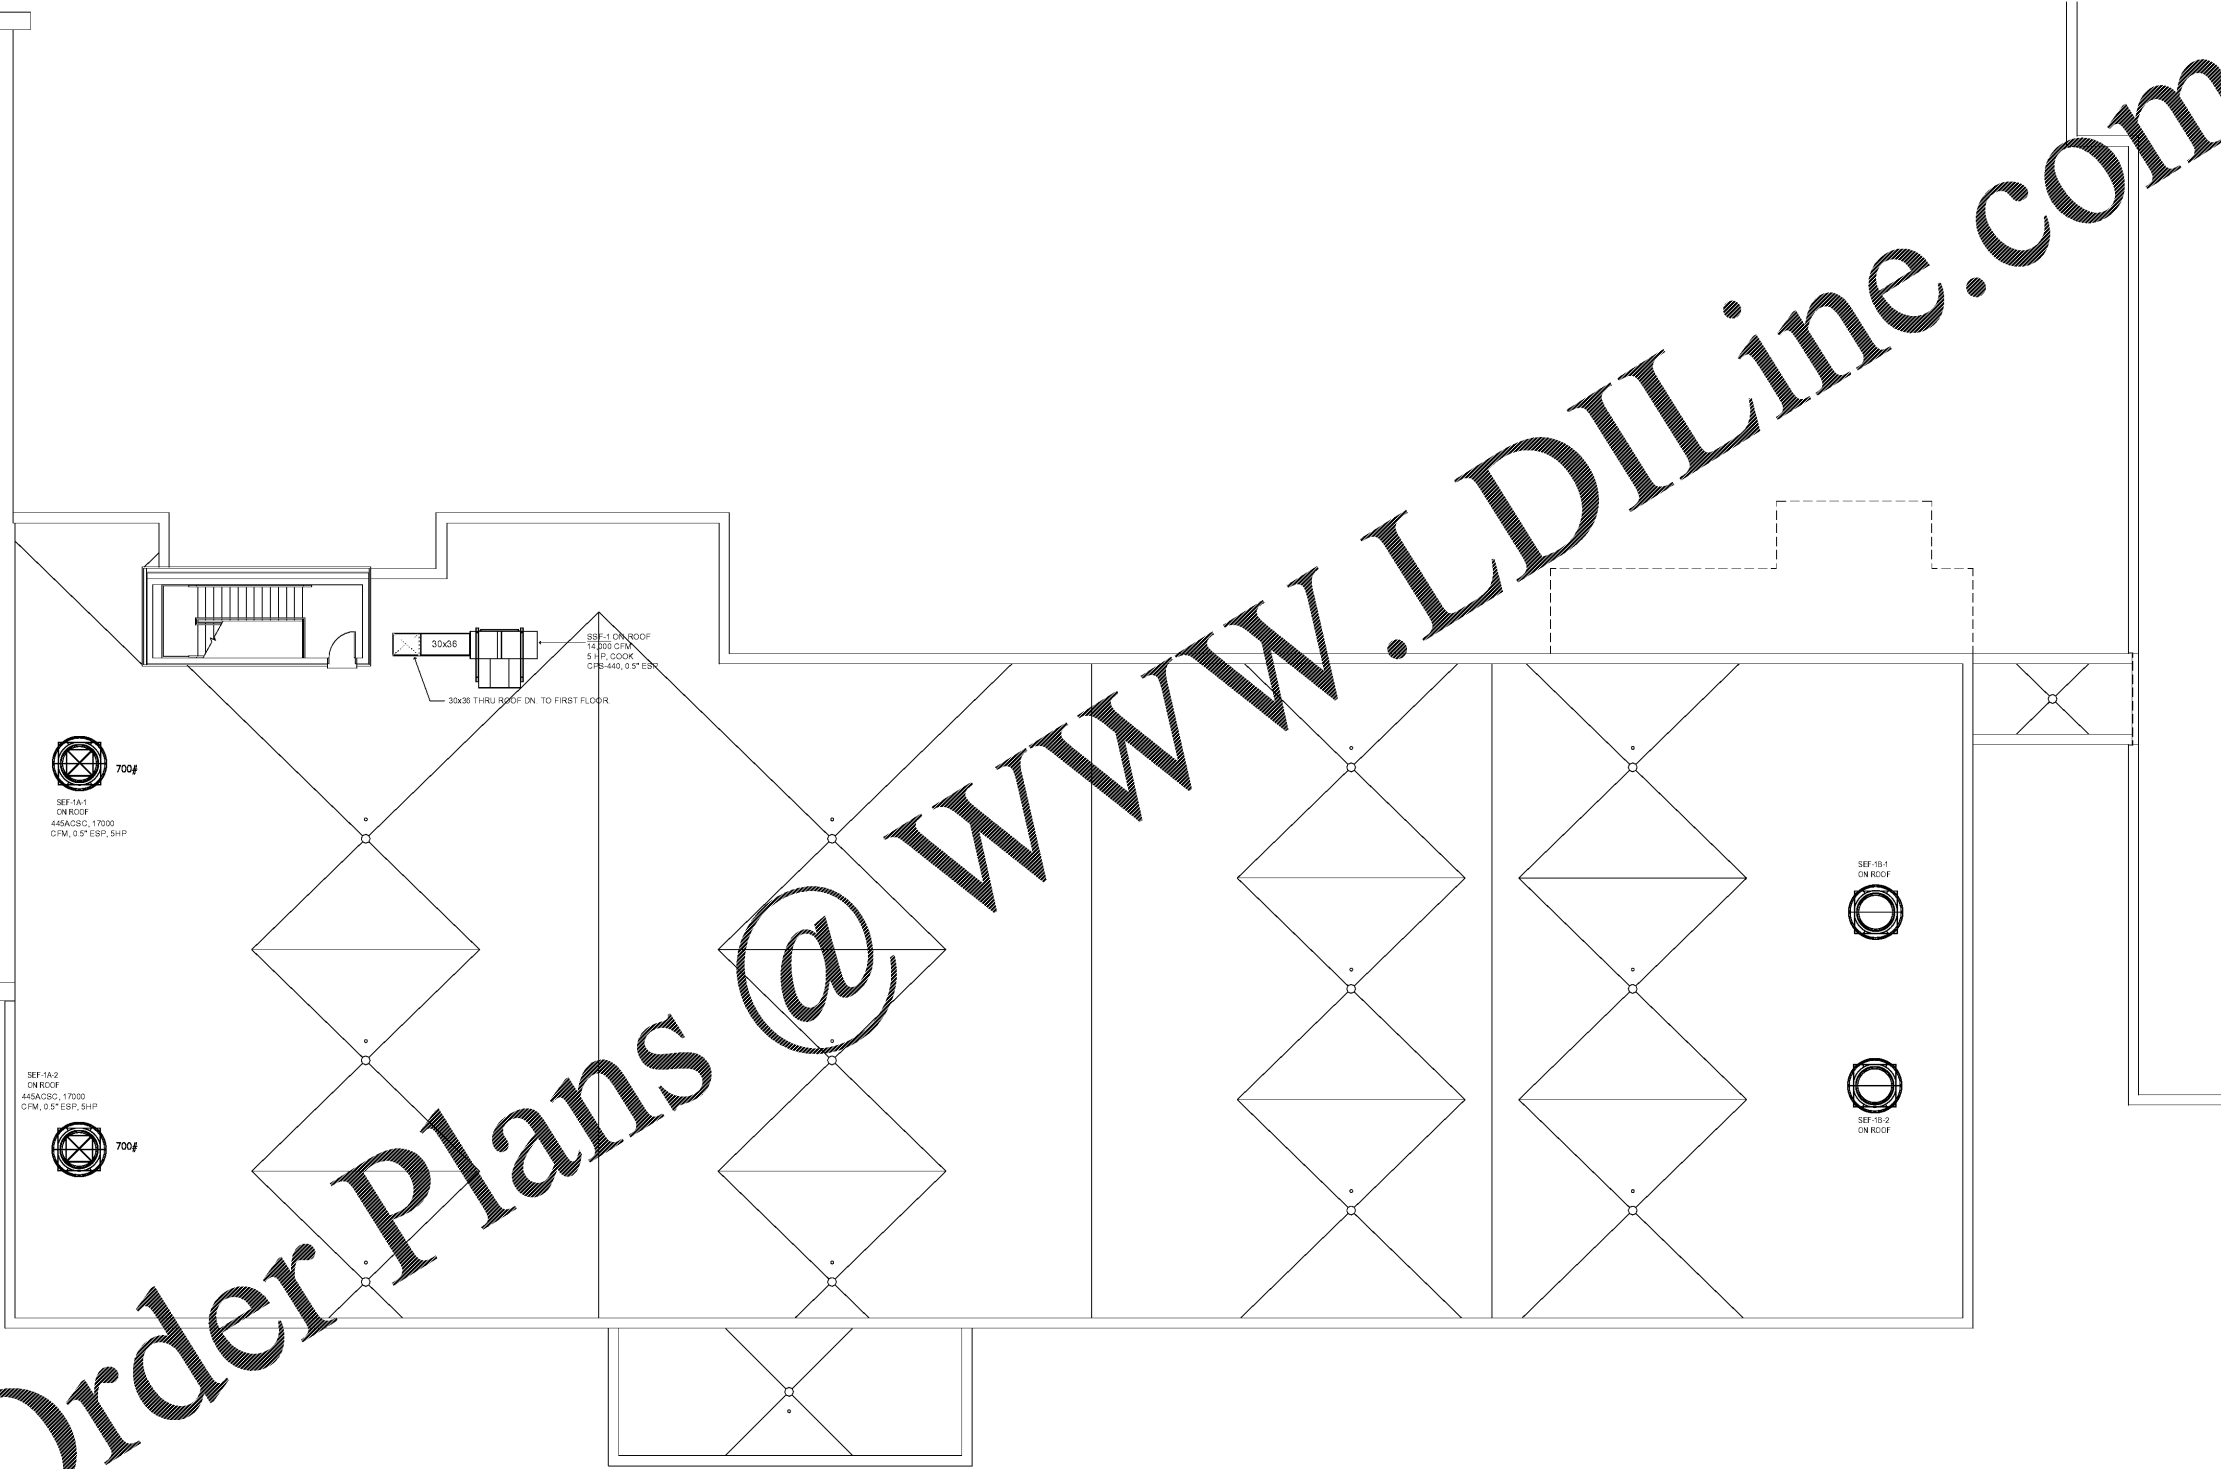


ROOF PLAN - BASE BID - SMOKE CONTROL
 SCALE: 1/8" = 1'-0" FIN FLOOR ELEV = 14.0'


architects inc.
 Montgomery, Alabama

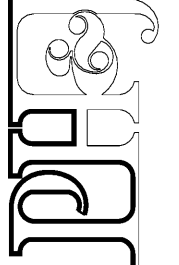

CIP-2017-001
 UPGRADES TO THE MOBILE COUNTY METRO JAIL
 For The MOBILE COUNTY COMMISSION
 MOBILE, ALABAMA



DRAWN	CW	CHECK	TZ
DATE	APRIL 2, 2019 RTA		
REVISED			
REVISED			

SHEET TITLE
ROOF PLAN - BASE BID - SMOKE CONTROL

JOB NO.
PH&J#1801GV

SEQUENCE
NO. 134 OF 175


ZGOUVAS, EIRING & ASSOCIATES
 CONSULTING ENGINEERS
 800 S. MONROUE STREET
 MONTGOMERY, AL. 36104
 334.263-4406
 ZEA PROJECT NUMBER 18-166

SC2.4