



Order Plans @ WWW.LDILine.com

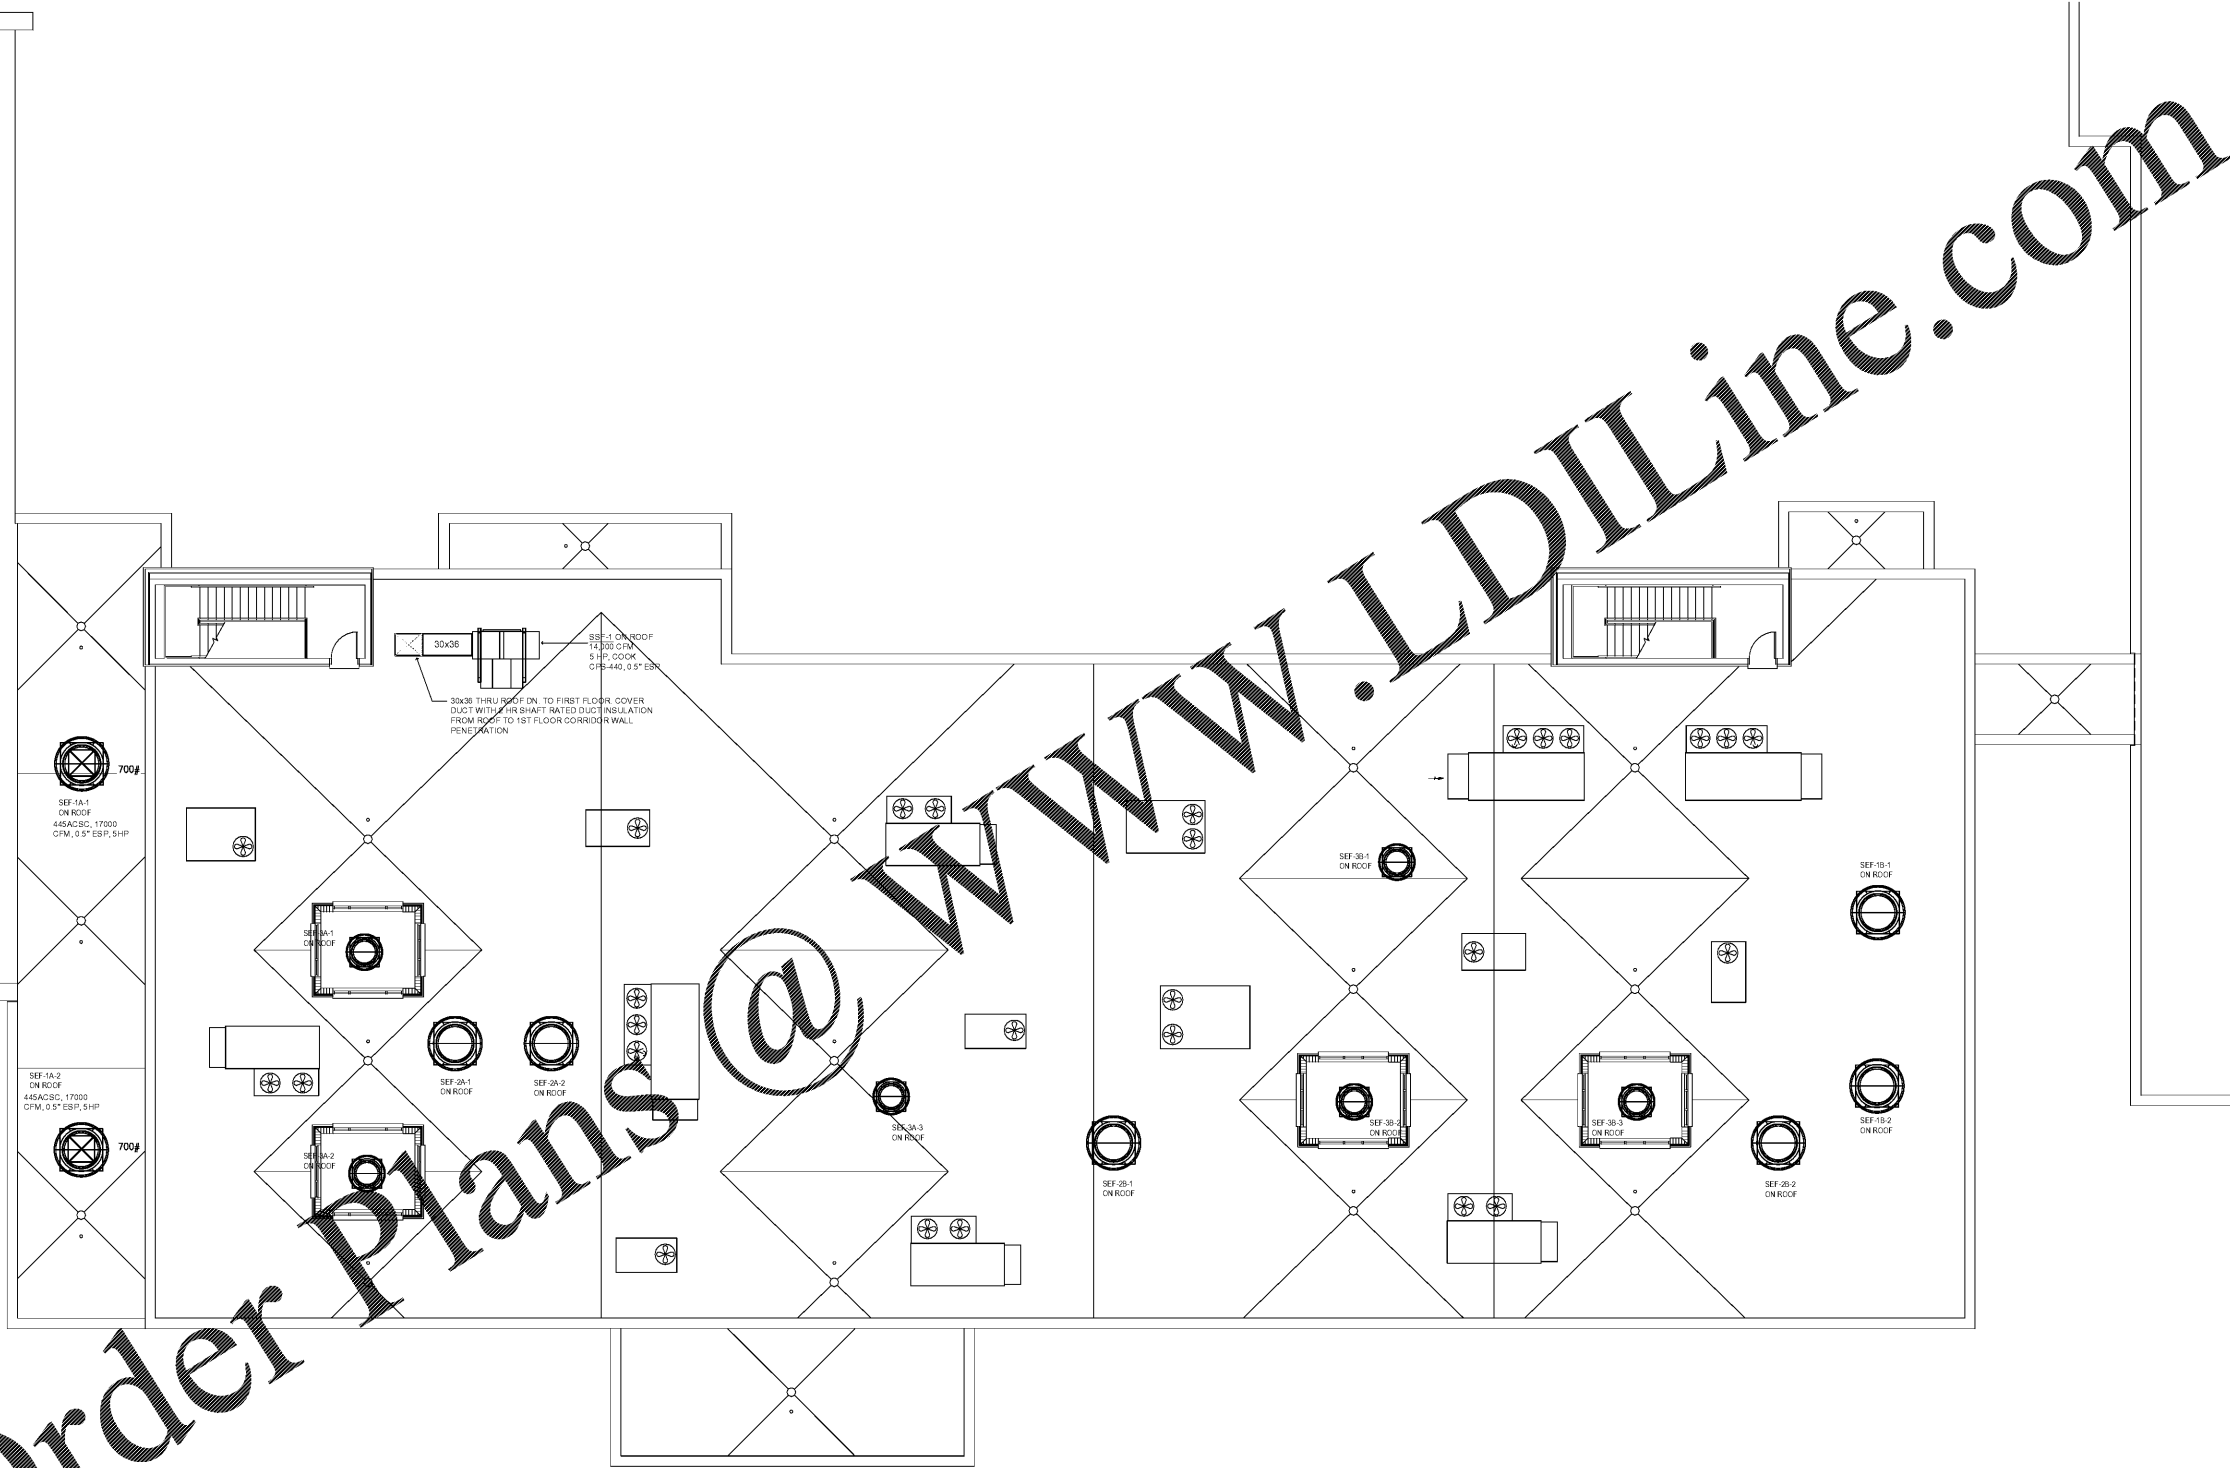

ROOF PLAN - 3RD FLOOR ALTERNATE #3 - SMOKE CONTROL
SCALE: 1/8" = 1'-0" FIN FLOOR ELEV = 14'-0"
Graphic Scale

architects inc.
Montgomery, Alabama

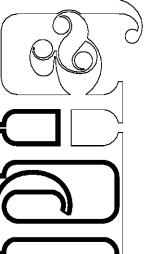

CIP-2017-001
UPGRADES TO THE MOBILE COUNTY METRO JAIL
For The MOBILE COUNTY COMMISSION
MOBILE, ALABAMA



DRAWN	CW	CHECK	TZ
DATE	APRIL 2, 2019 RTA		
REVISED			
REVISED			

SHEET TITLE
ROOF PLAN - 3rd FLOOR
ALTERNATE #3 - SMOKE
CONTROL

JOB NO.
PH&J#1801GV

SEQUENCE
NO. 136 OF 175

SC2.4B

ZGOUVAS, EIRING & ASSOCIATES
CONSULTING ENGINEERS
800 S. MODONOUGH STREET
MONTGOMERY, AL. 36104
334.263-4406
ZEA PROJECT NUMBER 18-166