

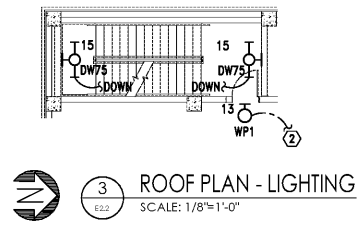


NOTE:
 ALL CONDUITS/CIRCUITRY SHALL BE
 CONCEALED IN THE CONCRETE SLABS.
 BEHIND WALLS, OR IN CHASES.

architects inc.
 Montgomery, Alabama

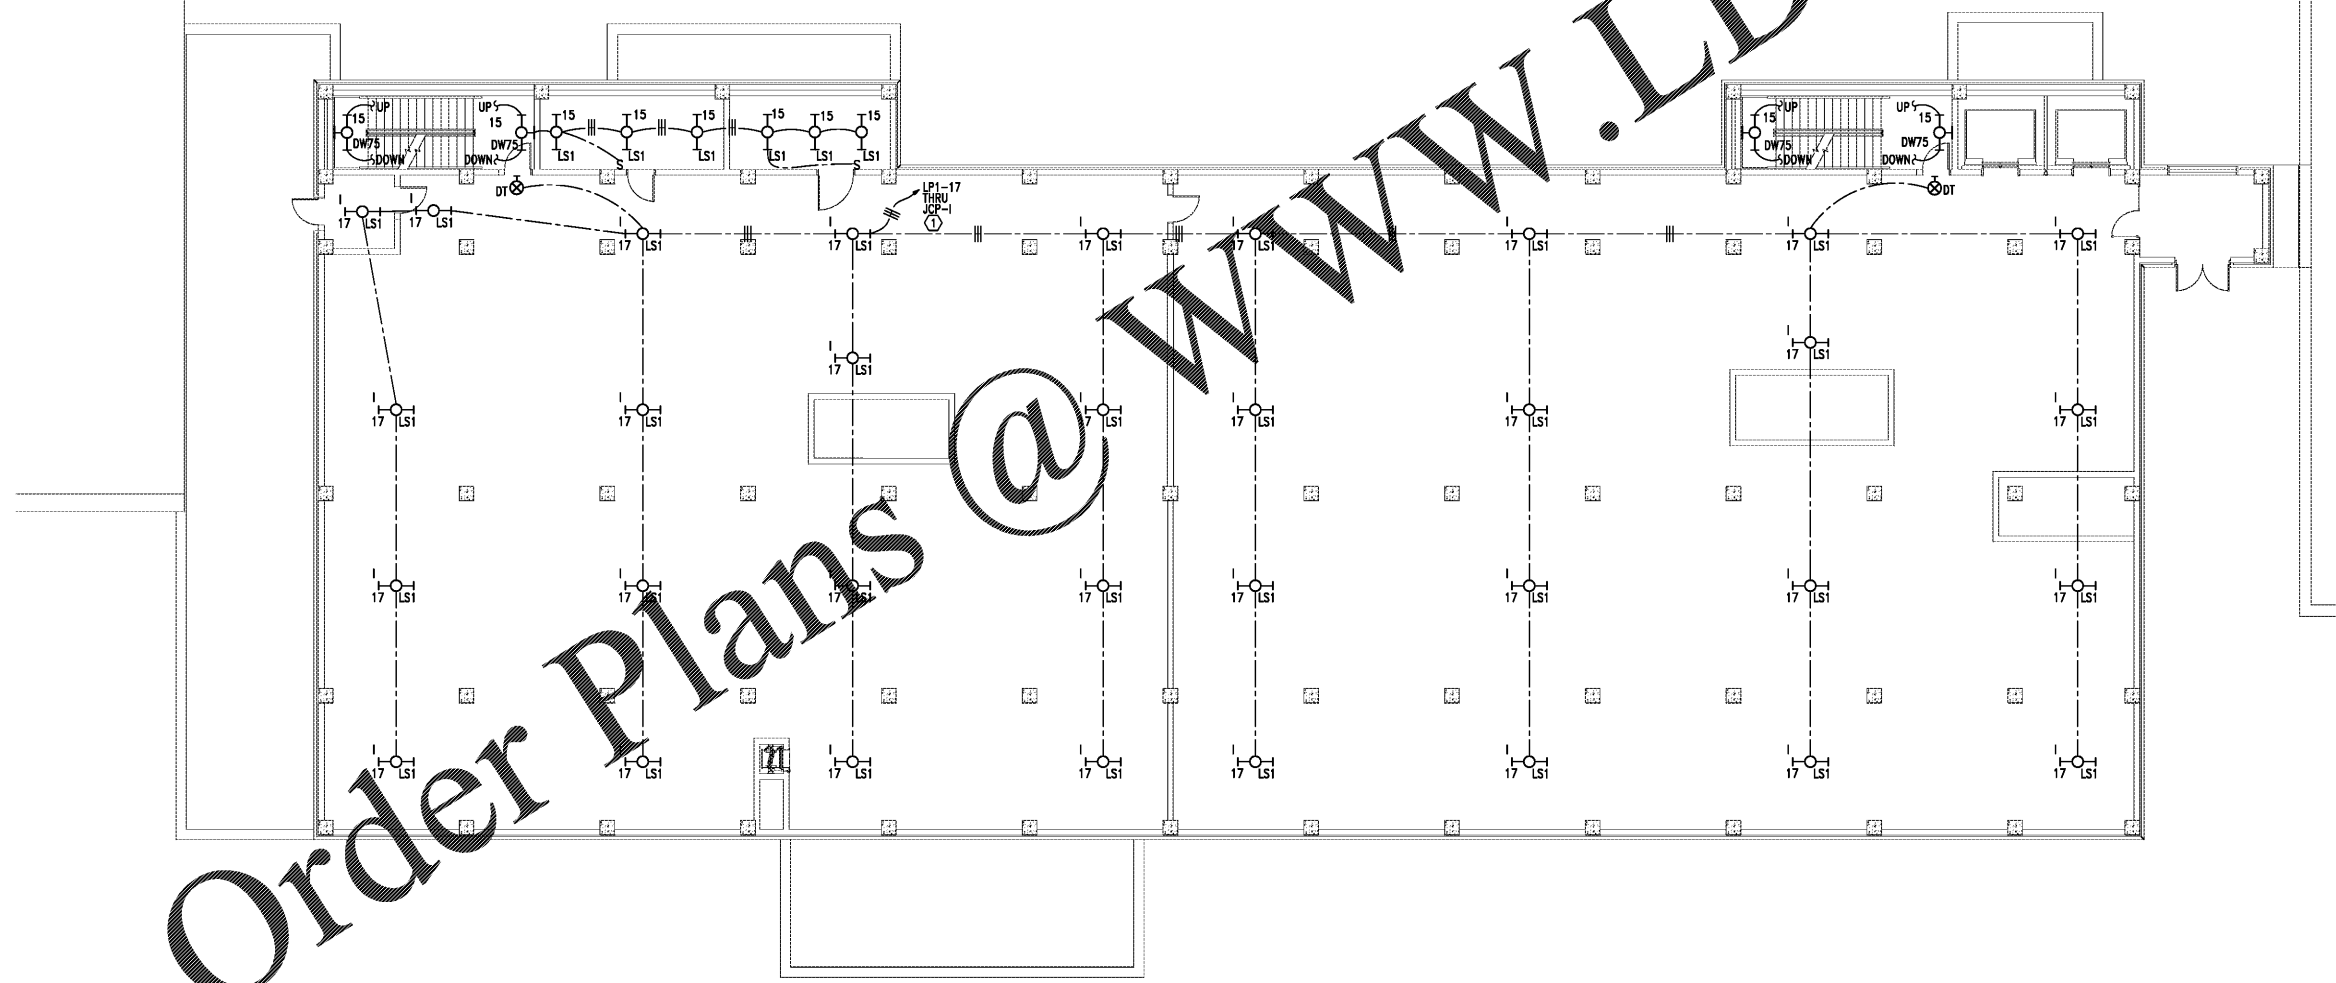

SHEET NOTES:
 ① ROUTE LIGHTS THRU RELAYS IN THE JAIL CONTROL PANEL BEING PROVIDED BY THE JAIL SECURITY CONTRACTOR. COORDINATE ROUTING AND REQUIREMENTS WITH JAIL SECURITY CONTRACTOR.
 ② DOWN TO EXTERIOR WALL PACK LIGHTING CIRCUIT.

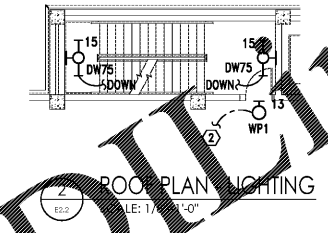

Order Plans @

WWW.LDLINE.COM

CIP-2017-001
 UPGRADES TO THE MOBILE COUNTY METRO JAIL
 For The MOBILE COUNTY COMMISSION
 MOBILE, ALABAMA



DRAWN	J.C.T.	CHECK	K.A.G.
DATE	April 2, 2019 RTA		
REVISED			
REVISED			

SHEET TITLE	2ND FLOOR PLAN - ALTERNATE - LIGHTING
JOB NO.	PH&J 1801-GV
SEQUENCE NO.	143 of 175

1/8" = 1'-0"
 8" 0 8 16 FT
 GRAPHIC SCALE

GA Gunn & Associates, P.C.
 Consulting Engineers
 3102 Highway 14
 Millbrook, AL 36054
 Tel: 334.285.1273

500 Southland Drive Suite 250
 Hoover, AL 35226
 GAF18-192

E2.2

© PH&J ARCHITECTS, INC.
 ALL RIGHTS RESERVED