




NOTE:
ALL CONDUITS/CIRCUITRY SHALL BE
CONCEALED IN THE CONCRETE SLABS.
BEHIND WALLS, OR IN CHASES.

architects inc.
Montgomery, Alabama

WWW.LDILine.com

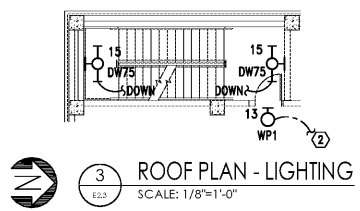

SHEET NOTES:
① ROUTE LIGHTS THRU RELAYS IN THE JAIL CONTROL PANEL BEING PROVIDED BY THE JAIL SECURITY CONTRACTOR. COORDINATE ROUTING AND REQUIREMENTS WITH JAIL SECURITY CONTRACTOR.
② DOWN TO EXTERIOR WALL PACK LIGHTING CIRCUIT.

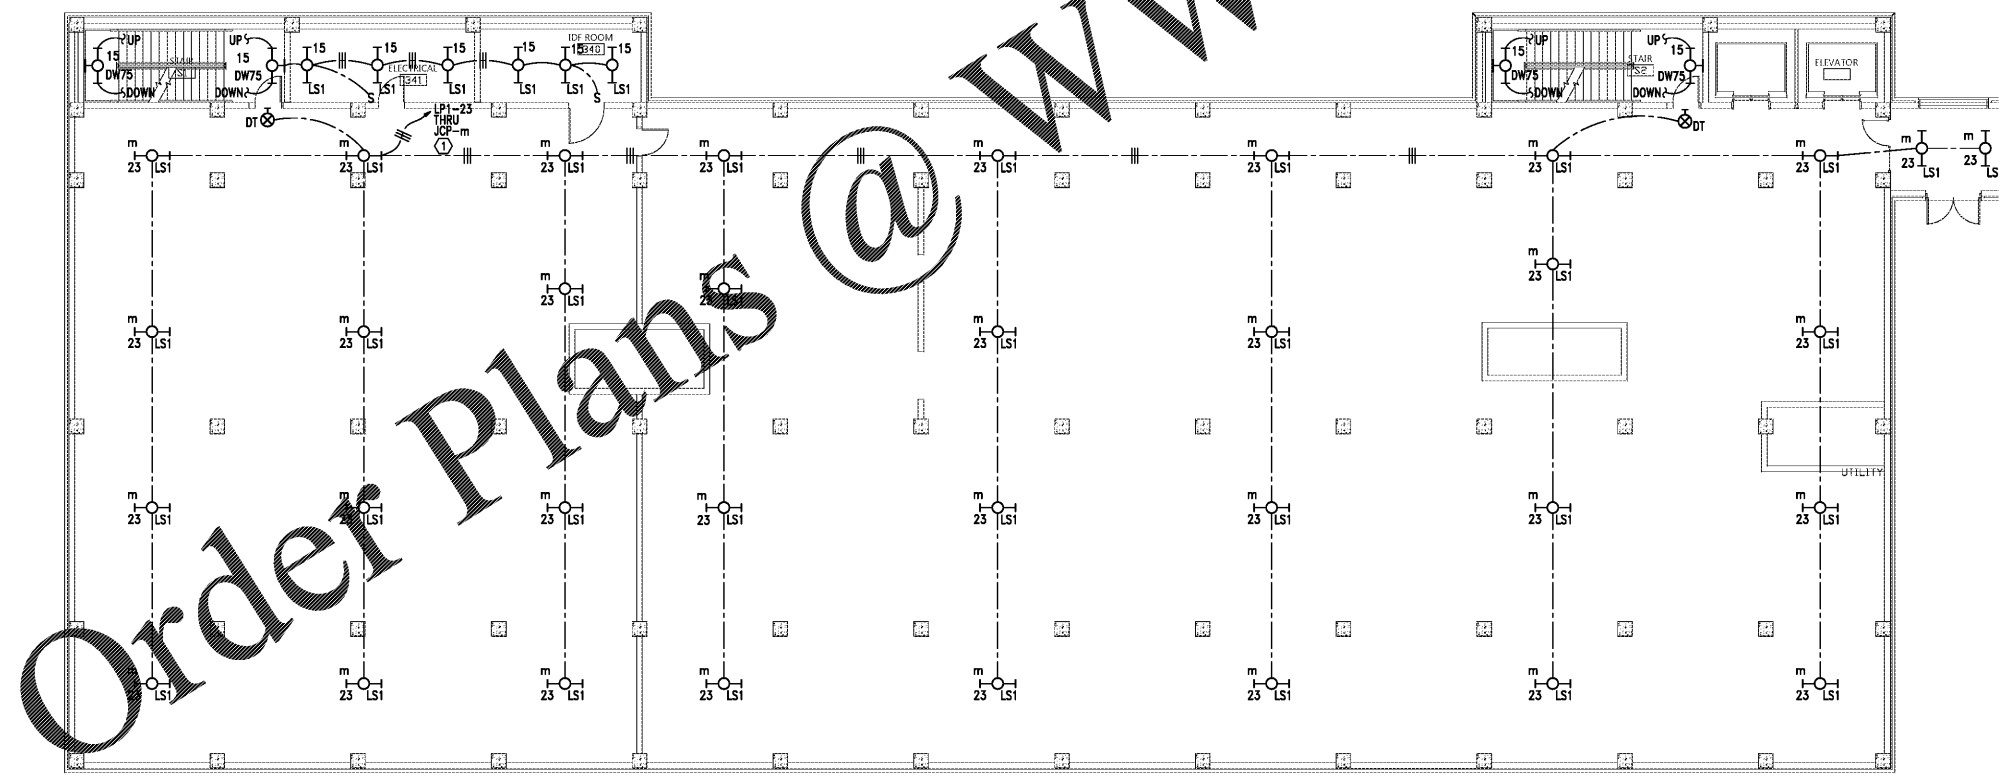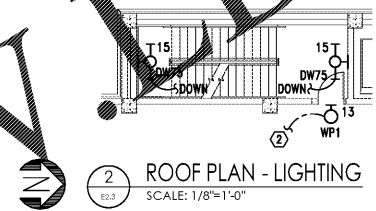


Order Plans @

CIP-2017-001
UPGRADES TO THE MOBILE COUNTY METRO JAIL
FOR THE MOBILE COUNTY COMMISSION
MOBILE, ALABAMA



DRAWN	J.C.T.	CHECK	K.A.G.
DATE	April 2, 2019 RTA		
REVISED			
REVISED			

SHEET TITLE	3RD FLOOR PLAN - ALTERNATE - LIGHTING
JOB NO.	PH&J 1801-GV
SEQUENCE NO.	142 of 175

 

GA Gunn & Associates, P.C.
Consulting Engineers
3102 Highway 14
Milledgeville, AL 36654
500 Southland Drive Suite 210
Hoover, AL 35226
Tel: 334.285.1273
GAP18-192

E2.3
© PH&J ARCHITECTS, INC.
ALL RIGHTS RESERVED