
 


NOTE:  
 ALL CONDUITS/CIRCUITRY SHALL BE  
 CONCEALED IN THE CONCRETE SLABS,  
 BEHIND WALLS, OR IN CHASES.

Order Plans @ [www.DILine.com](http://www.DILine.com)

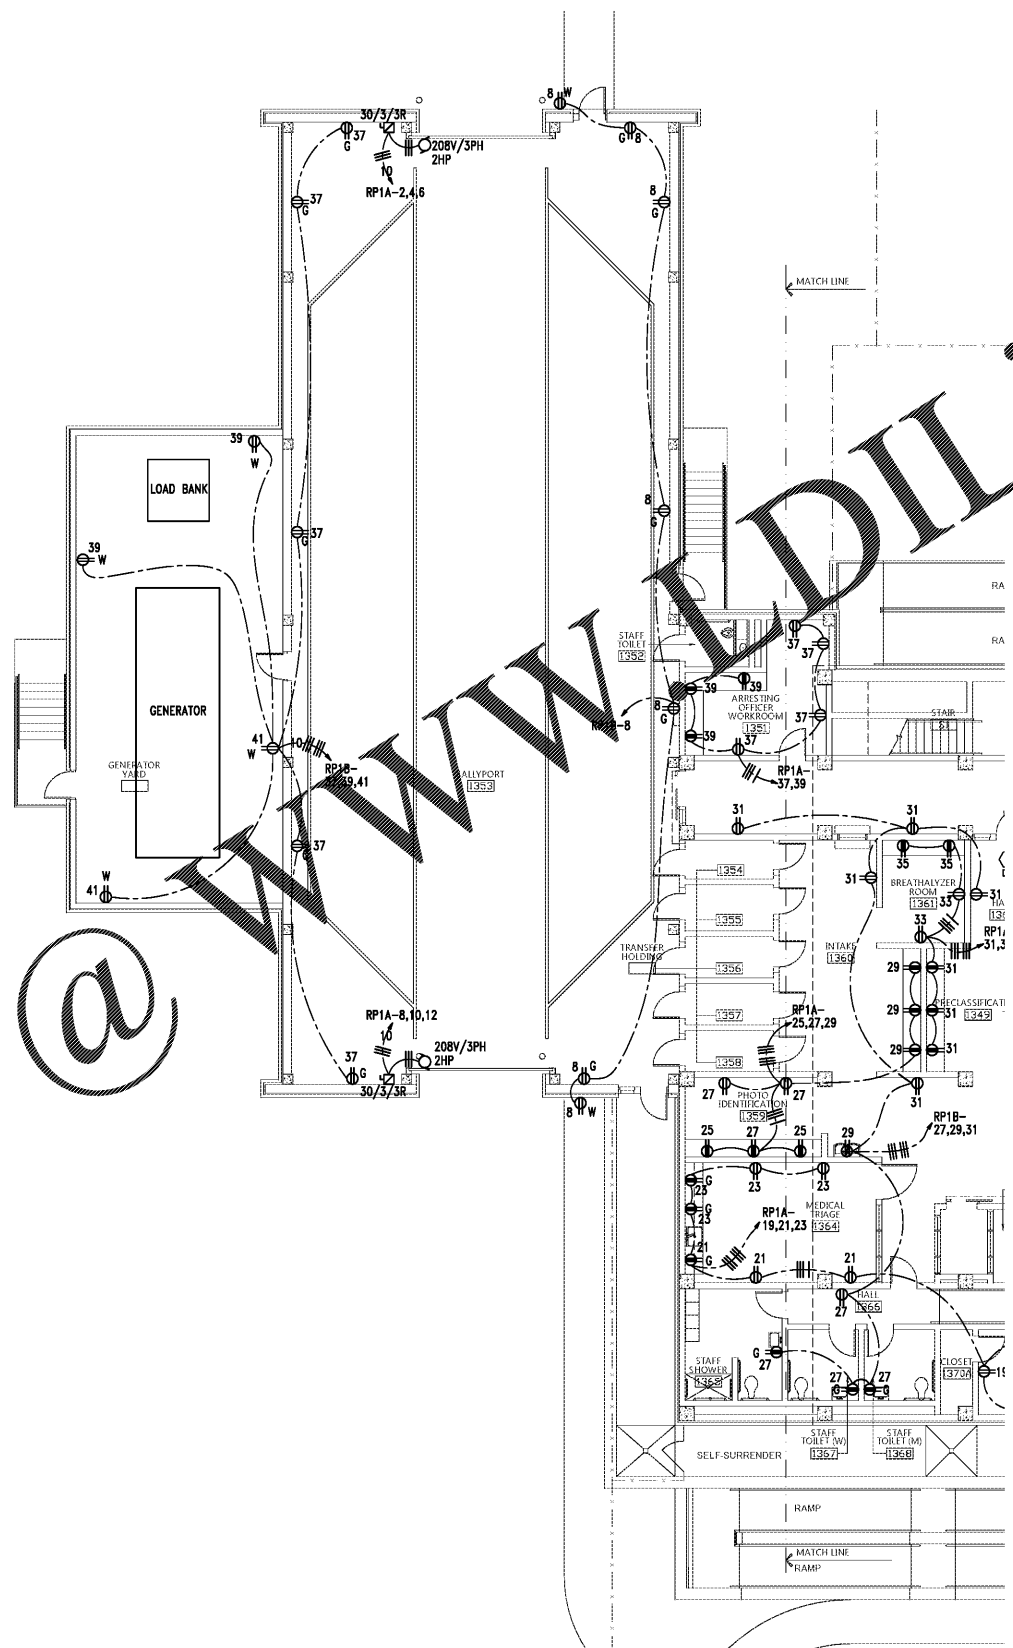


SALLY PORT  
 1ST FLOOR PLAN - BASE BID - POWER  
 SCALE: 1/8"=1'-0"



**GA** Gunn & Associates, P.C.  
 Consulting Engineers  
 3102 Highway 14  
 Millbrook, AL 36064  
 500 Southland Drive Suite 250  
 Hoover, AL 35226  
 Tel: 334.285.1273  
 GAI18-192

architects inc.  
 Montgomery, Alabama

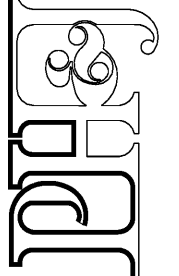

CIP-2017-001  
 UPGRADES TO THE MOBILE COUNTY METRO JAIL  
 For The MOBILE COUNTY COMMISSION  
 MOBILE, ALABAMA



DRAWN: J.C.T.	CHECK: K.A.G.
DATE: April 2, 2019 RTA	
REVISED:	
REVISED:	

SHEET TITLE  
 SALLY PORT - 1ST FLOOR  
 PLAN - BASE BID -  
 POWER

COR NO.  
 PH&J 1801-GV

SEQUENCE  
 NO. 144 OF 175

**E3.0**  
 © PH&J ARCHITECTS, INC.  
 ALL RIGHTS RESERVED