


NOTE:
 ALL CONDUITS/CIRCUITRY SHALL BE
 CONCEALED IN THE CONCRETE SLABS.
 BEHIND WALLS, OR IN CHASES.

GENERAL NOTES:

1. COORDINATE WITH CORRESPONDING RISER DIAGRAMS ON SHEETS E7.0 & E7.1.
2. COORDINATE AND MOUNT COMMUNICATIONS OUTLETS WITHIN 6" OF CORRESPONDING POWER RECEPTACLES.
3. PROVIDE A GREEN DOT STICKER ON THE CEILING GRID UNDER EACH WIRELESS ACCESS POINT LOCATION TO SHOW LOCATION TO THE IT STAFF. PROVIDE AT LEAST 15' OF COILED CAT5 SLACK AT EACH WIRELESS ACCESS POINT.


SHEET NOTES:

- ① PROVIDE WALL OUTLET FOR WIRELESS ACCESS POINT OUTLET AND MOUNT 12' AFF.
- ② PROVIDE WIREGUARDS FOR FIRE ALARM DEVICES.
- ③ UPON FIRE ALARM DETECTION OF HEAT DETECTORS IN SALLYPORT, THIS MOTORIZED DOOR SHALL OPEN THRU THE JAIL CONTROL SYSTEM.

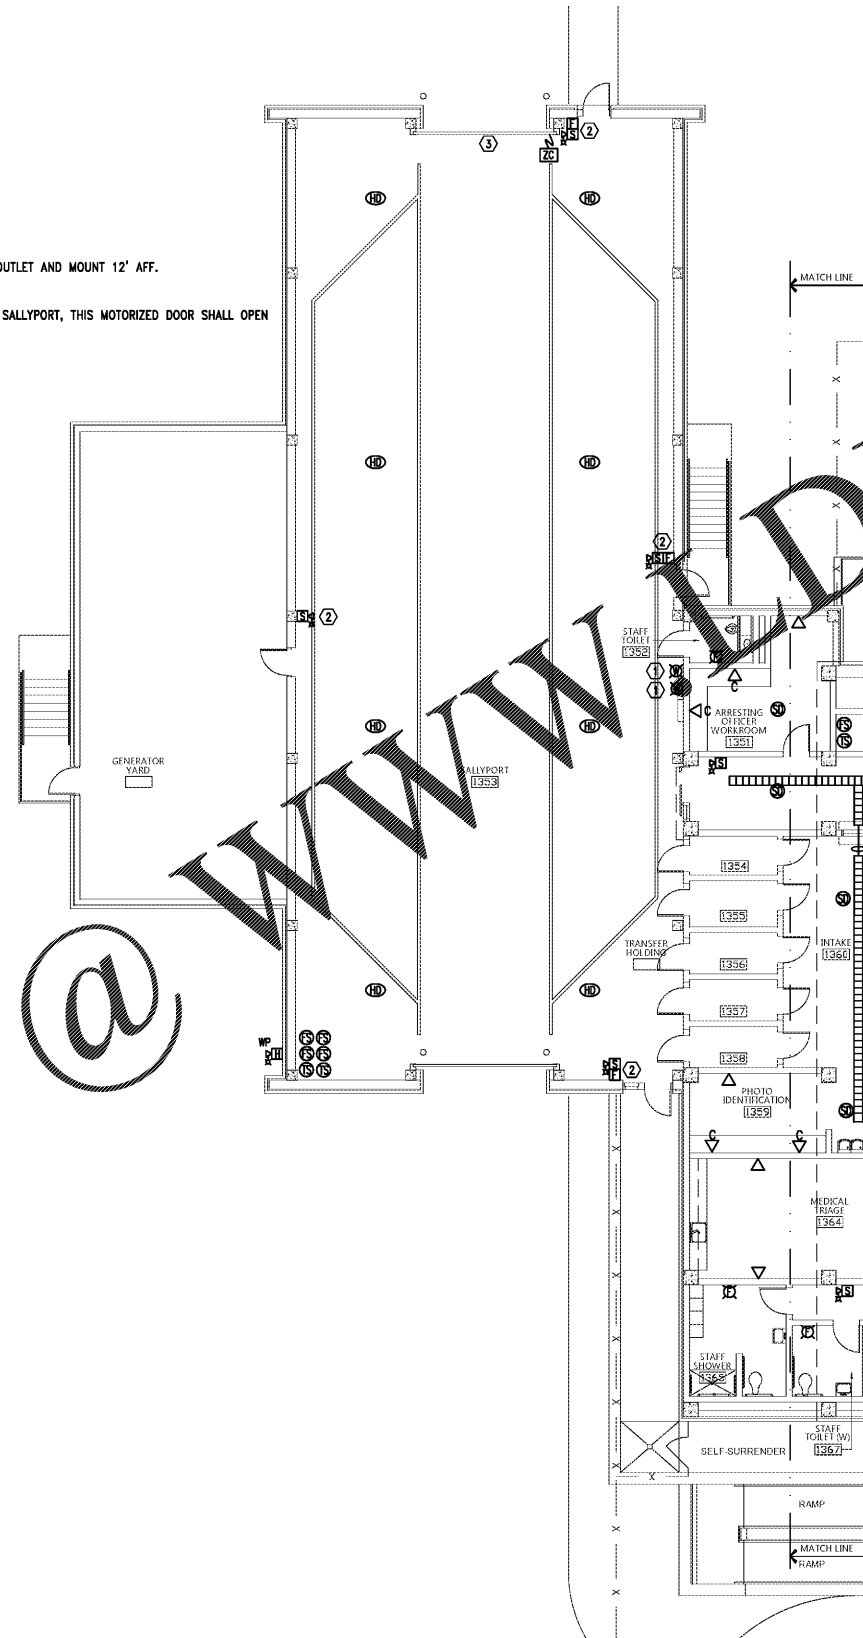

Order Plans @

 SALLY PORT
 1ST FLOOR PLAN - BASE BID - AUXILIARY
 SCALE: 1/8"=1'-0"



GA Gunn & Associates, P.C.
 Consulting Engineers
 3102 Highway 14
 Millbrook, AL 36054
 500 Southland Drive Suite 250
 Hoover, AL 35226
 Tel: 334.285.1273
 GAI18-192

CIP-2017-001
 UPGRADES TO THE MOBILE COUNTY METRO JAIL
 For The MOBILE COUNTY COMMISSION
 MOBILE, ALABAMA



DRAWN: J.C.T.	CHECK: K.A.G.
DATE: April 2, 2019 RTA	
REVISED:	
REVISED:	

SHEET TITLE
 SALLY PORT - 1ST FLOOR
 PLAN - BASE BID -
 AUXILIARY
 JOB NO.
 PH&J 1801-GV
 FREQUENCY
 NO. 153 OF 175

E4.0
 © PH&J ARCHITECTS, INC.
 ALL RIGHTS RESERVED

architects inc.
 Montgomery,
 Alabama