


GENERAL NOTES:

1. COORDINATE WITH CORRESPONDING RISER DIAGRAMS ON SHEETS E7.0 & E7.1.
2. COORDINATE AND MOUNT COMMUNICATIONS OUTLETS WITHIN 6" OF CORRESPONDING POWER RECEPTACLE.
3. PROVIDE A GREEN DOT STICKER ON THE CEILING GRID UNDER EACH WIRELESS ACCESS POINT LOCATION TO SHOW LOCATION TO THE IT STAFF. PROVIDE AT LEAST 15' OF COILED CAT6 SLACK AT EACH WIRELESS ACCESS POINT.

NOTE:


ALL CONDUITS/CIRCUITRY SHALL BE CONCEALED IN THE CONCRETE SLABS, BEHIND WALLS, OR IN CHASES.

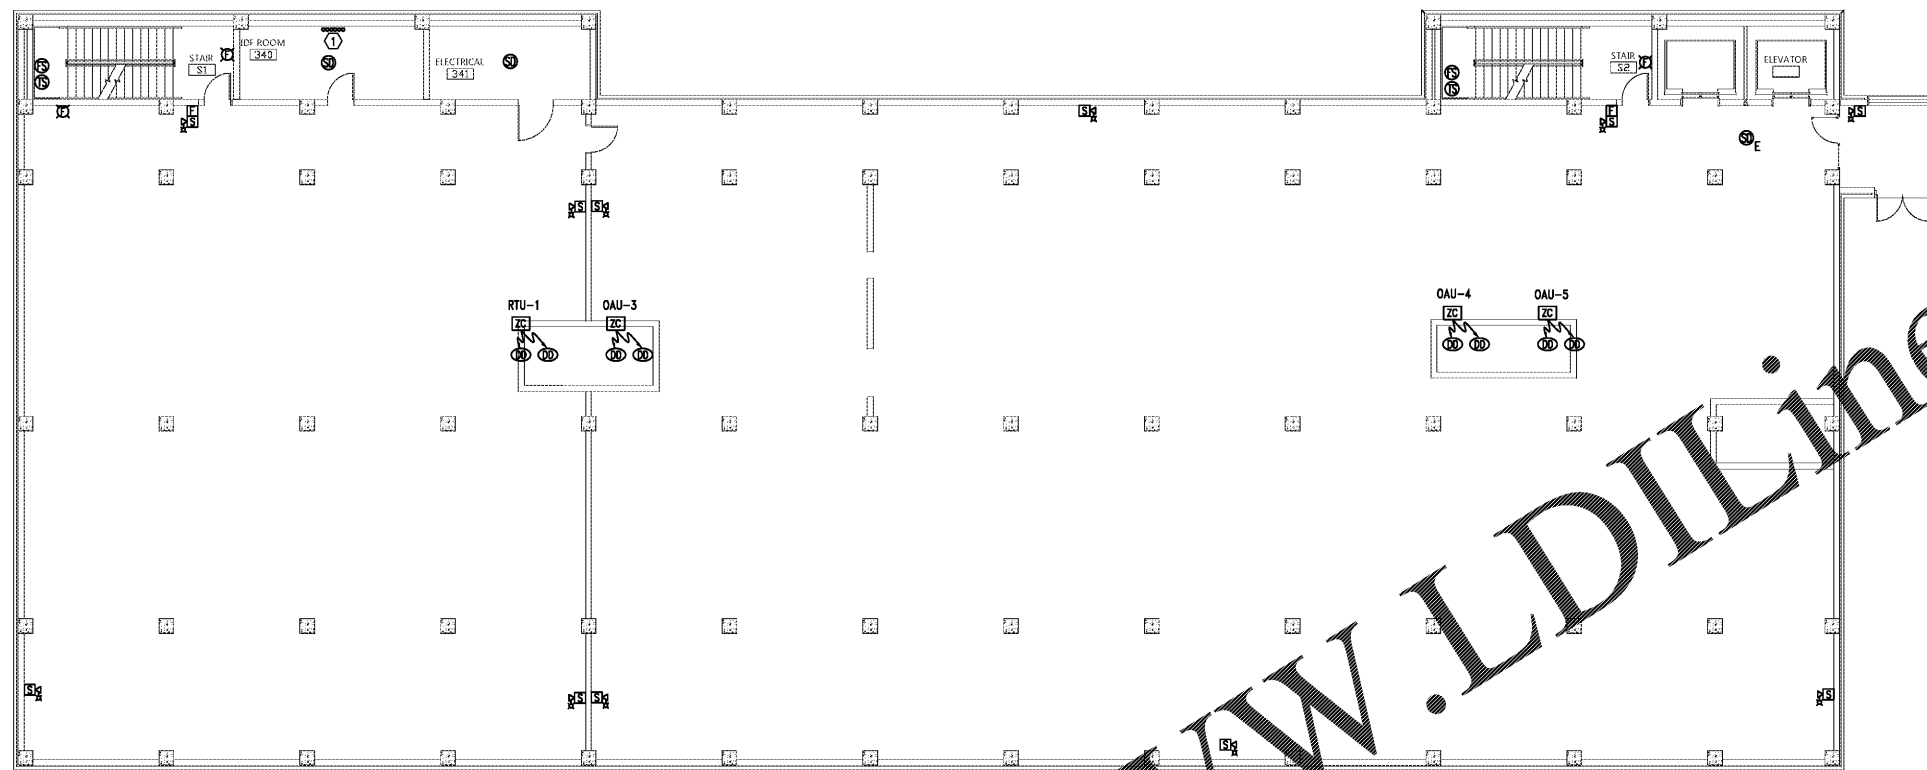

2 3RD FLOOR PLAN - ALTERNATE - AUXILIARY
SCALE: 1/8"=1'-0"

SHEET NOTES:

1. PROVIDE SIX (6) 4" SLEEVES TO THE IDF ROOM BELOW.

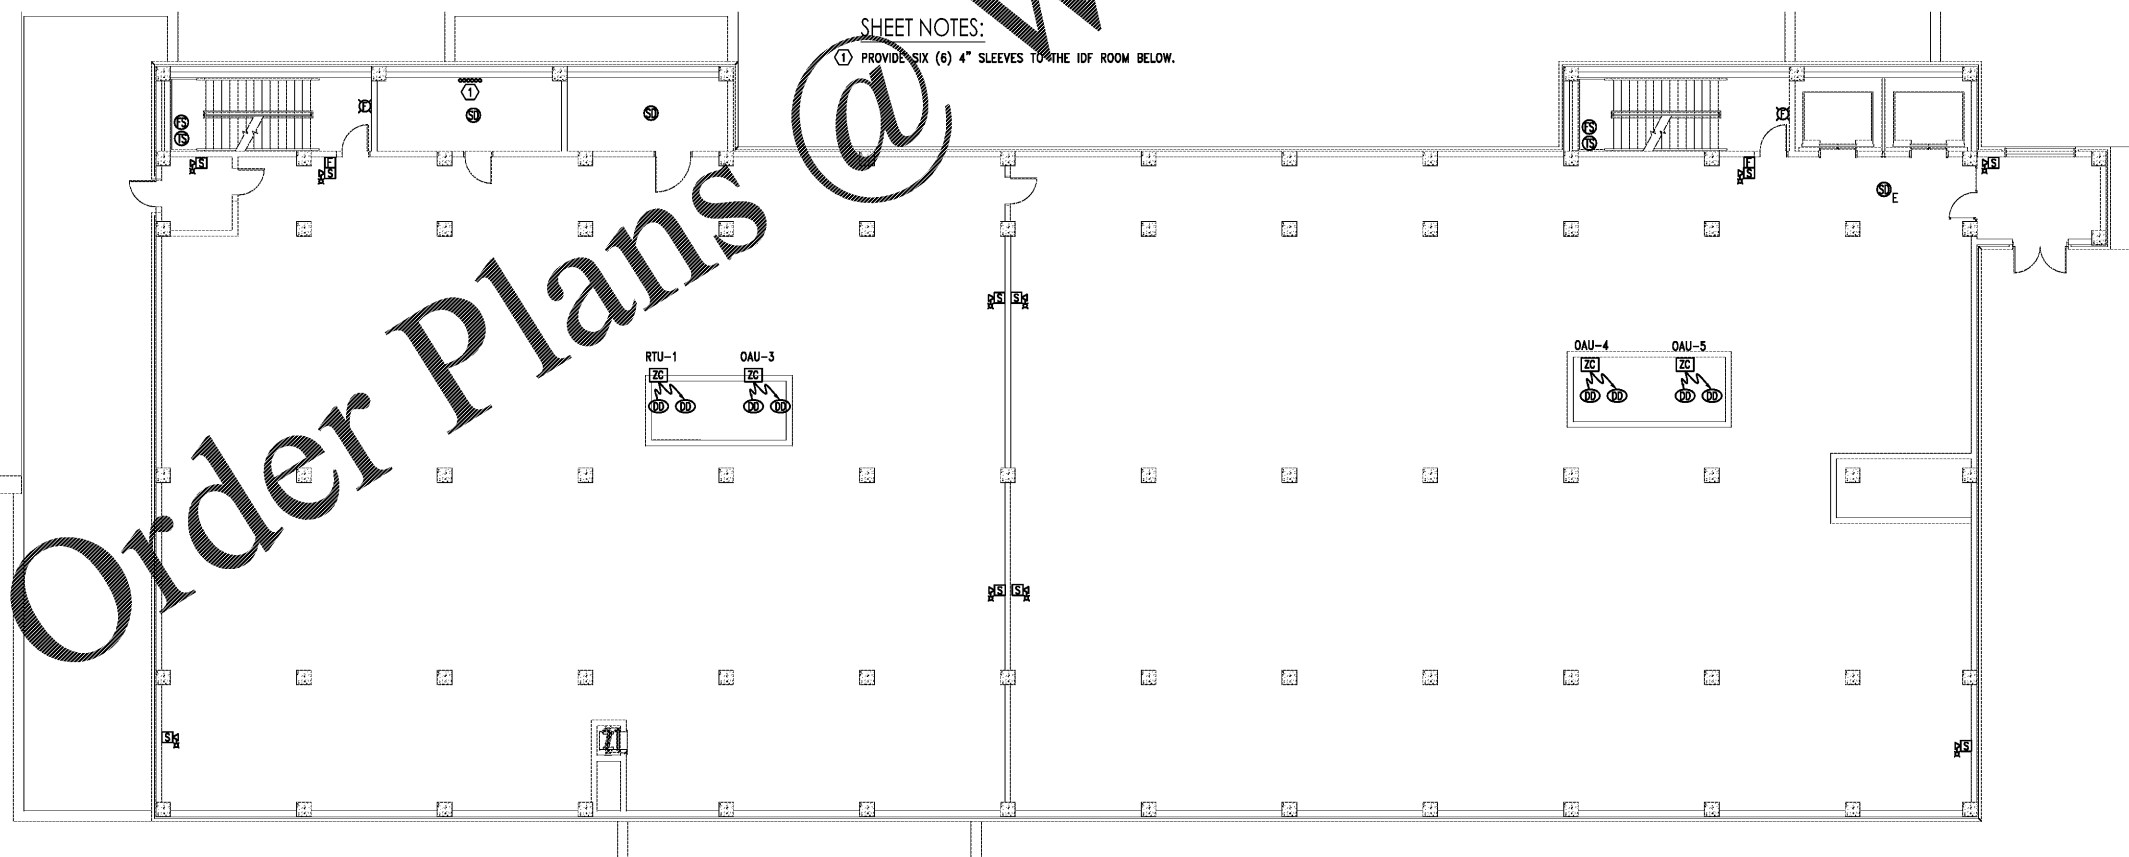


1 2ND FLOOR PLAN - ALTERNATE - AUXILIARY
SCALE: 1/8"=1'-0"

Order Plans @ www.LDILine.com


WWW.LDILine.com

CIP-2017-001
UPGRADES TO THE MOBILE COUNTY METRO JAIL
FOR THE MOBILE COUNTY COMMISSION
MOBILE, ALABAMA

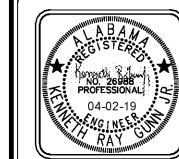

DRAWN	J.C.T.	CHECK	K.A.G.
DATE	April 2, 2019 RTA		
REVISED			
REVISED			

SHEET TITLE	
2ND & 3RD FLOOR PLANS - ALTERNATE - AUXILIARY	
JOB NO.	PH&J 1801-GV
SEQUENCE NO.	155 OF 175

 

GA Gunn & Associates, P.C.
Consulting Engineers
1102 Highway 14
Montgomery, AL 36104
500 Southland Drive Suite 250
Hoover, AL 35226
Tel: 334.285.1273
GAP18-192

E4.2

© PH&J ARCHITECTS, INC.
ALL RIGHTS RESERVED

architects inc.
Montgomery, Alabama