


Order Plans @ WWW.LDILine.com

SHEET NOTES:


- ① PROVIDE COMPLETE LIGHTNING PROTECTION SYSTEM FOR THE ENTIRE BUILDING. LIGHTNING PROTECTION SYSTEM SHALL COMPLY WITH NEC AND NFPA 780. THE CONTRACTOR SHALL FURNISH AN UL MASTER LABEL FOR THE COMPLETE LIGHTNING PROTECTION SYSTEM PRIOR TO FINAL ACCEPTANCE OF THE FACILITY. CONTRACTOR WILL HAVE TO MEET THE PERFORMANCE SPECIFICATION. SEE MECHANICAL AND ARCHITECTURAL FOR FINAL ROOF PLANS AND EQUIPMENT ON ROOF.

GENERAL NOTES:

- 1. INSTALL A COMPLETE LIGHTNING PROTECTION SYSTEM AT EQUAL-POTENTIAL GROUND BONDED TOGETHER AS ONE COMPLETE SYSTEM.
- 2. CONTRACTOR SHALL OBTAIN UL LABEL FOR LIGHTNING PROTECTION SYSTEM. CONTRACTOR SHALL PROVIDE ALL NECESSARY TIME AND MATERIAL TO OBTAIN UL LABEL.
- 3. ALL DOWNLEAD CONDUCTORS SHALL BE CONSIDERED. NO EXCEPTIONS.
- 4. ALUMINUM SYSTEM WILL BE ACCEPTED FOR THE LIGHTNING PROTECTION.
- 5. PLEASE NOTE THAT THE ROOF CHANGES WITH ALTERNATES. BE SURE TO COVER THIS IN BID.

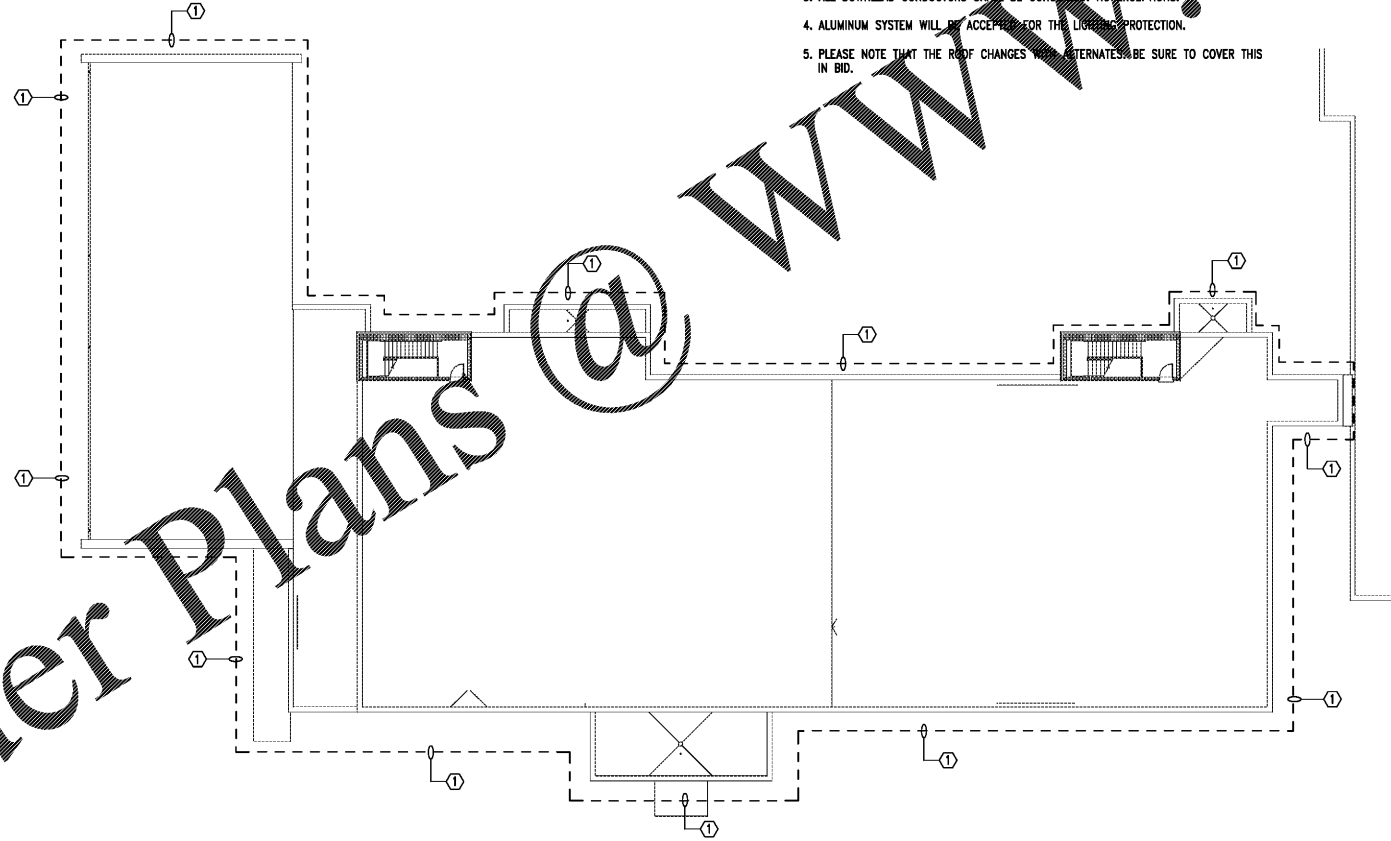


  ① ROOF PLAN - LIGHTNING PROTECTION
SCALE: 1/16"=1'-0"




GA Gunn & Associates, P.C.
Consulting Engineers
3102 Highway 14
Millbrook, AL 36054
500 Southland Drive Suite 250
Hoover, AL 35226
Tel: 334.285.1273
GAP18-192

architects inc.
Montgomery, Alabama

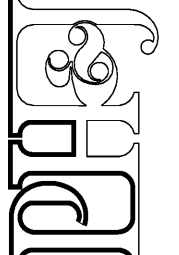

CIP-2017-001
UPGRADES TO THE MOBILE COUNTY METRO JAIL
For The MOBILE COUNTY COMMISSION
MOBILE, ALABAMA

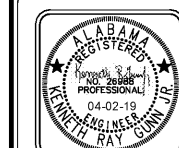

DRAWN	J.C.T.	CHECK	K.A.G.
DATE	April 2, 2019 RTA		
REVISED			
REVISED			

SHEET TITLE
ROOF PLAN -
LIGHTNING PROTECTION
JOB NO.
PH&J 1801-GV
SEQUENCE
NO. 156 OF 175

E4.3
© PH&J ARCHITECTS, INC.
ALL RIGHTS RESERVED