


NOTE:
ALL CONDUITS/CIRCUITRY SHALL BE CONCEALED IN THE CONCRETE SLABS, BEHIND WALLS, OR IN CHASES.

SECURITY LEGEND

- NOTE:
ALL 8" CMU WALL ALL CELLS FILLED WITH CONCRETE REINFORCED WITH #4 BARS 16" O.C.
- DURESS BUTTON
SINGLE GANG JUNCTION BOX WITH 3/4" CONDUIT TO CABLE BASKET OR IDF
 - DURESS STROBE
PROVIDE 120V POWER AS SHOWN. PROVIDE CONTROL CONDUIT AS DIRECTED BY DURESS SYSTEM PROVIDER
 - ELECTRONIC SECURITY DOOR
PROVIDE 3/4" CONDUIT FROM ELECTRONIC SECURITY DEVICE AT DOOR/GATE/GARAGE TO IDF. UP TO TWO DOORS CAN BE ON A SINGLE HOMERUN CONDUIT. COORDINATE WITH SECURITY CONTRACTOR AND PROVIDE PROPER ROUGH-IN LOCATION AT SECURE DOOR/GATE/GARAGE.
 - INTERCOM STATION
PROVIDE DOUBLE GANG JUNCTION BOX AT 48" AFF TO CENTER OF BOX WITH 3/4" CONDUIT TO THE CABLE BASKET OR IDF.
 - DIRECTIONAL CAMERA
CAMERA BY SECURITY CONTRACTOR
RACEWAYS BY ELECTRICAL CONTRACTOR
 - PAN, TILT, ZOOM FUNCTION
CAMERA BY SECURITY CONTRACTOR
RACEWAYS BY ELECTRICAL CONTRACTOR
 - 270° CAMERA
CAMERA BY SECURITY CONTRACTOR
RACEWAYS BY ELECTRICAL CONTRACTOR
 - CONCRETE CAMERA POLE. ELECTRICAL CONTRACTOR PROVIDES DIRECT BURY CONCRETE POLE AND RACEWAY
 - "GOOSE NECK" INTERCOM & CAMERA MOUNT.
PEDESTAL BY SECURITY CONTRACTOR
RACEWAYS BY ELECTRICAL CONTRACTOR
 - DUAL INTERCOM & MOUNT ON PEDESTAL
PEDESTAL BY SECURITY CONTRACTOR
RACEWAYS BY ELECTRICAL CONTRACTOR
 - SINGLE INTERCOM & MOUNT ON PEDESTAL
PEDESTAL BY SECURITY CONTRACTOR
RACEWAYS BY ELECTRICAL CONTRACTOR
 - HANDHOLE

GENERAL NOTES:

- COORDINATE ALL LOCATIONS AND CONDUIT REQUIREMENTS WITH ARCHITECTURAL SECURITY SHEETS PRIOR TO BIDS. PROVIDE CONDUIT TO ADDITIONAL SECURITY DEVICES SHOWN ON ARCHITECTURAL SECURITY PLANS THAT ARE NOT SHOWN ON THE E-SHEETS.

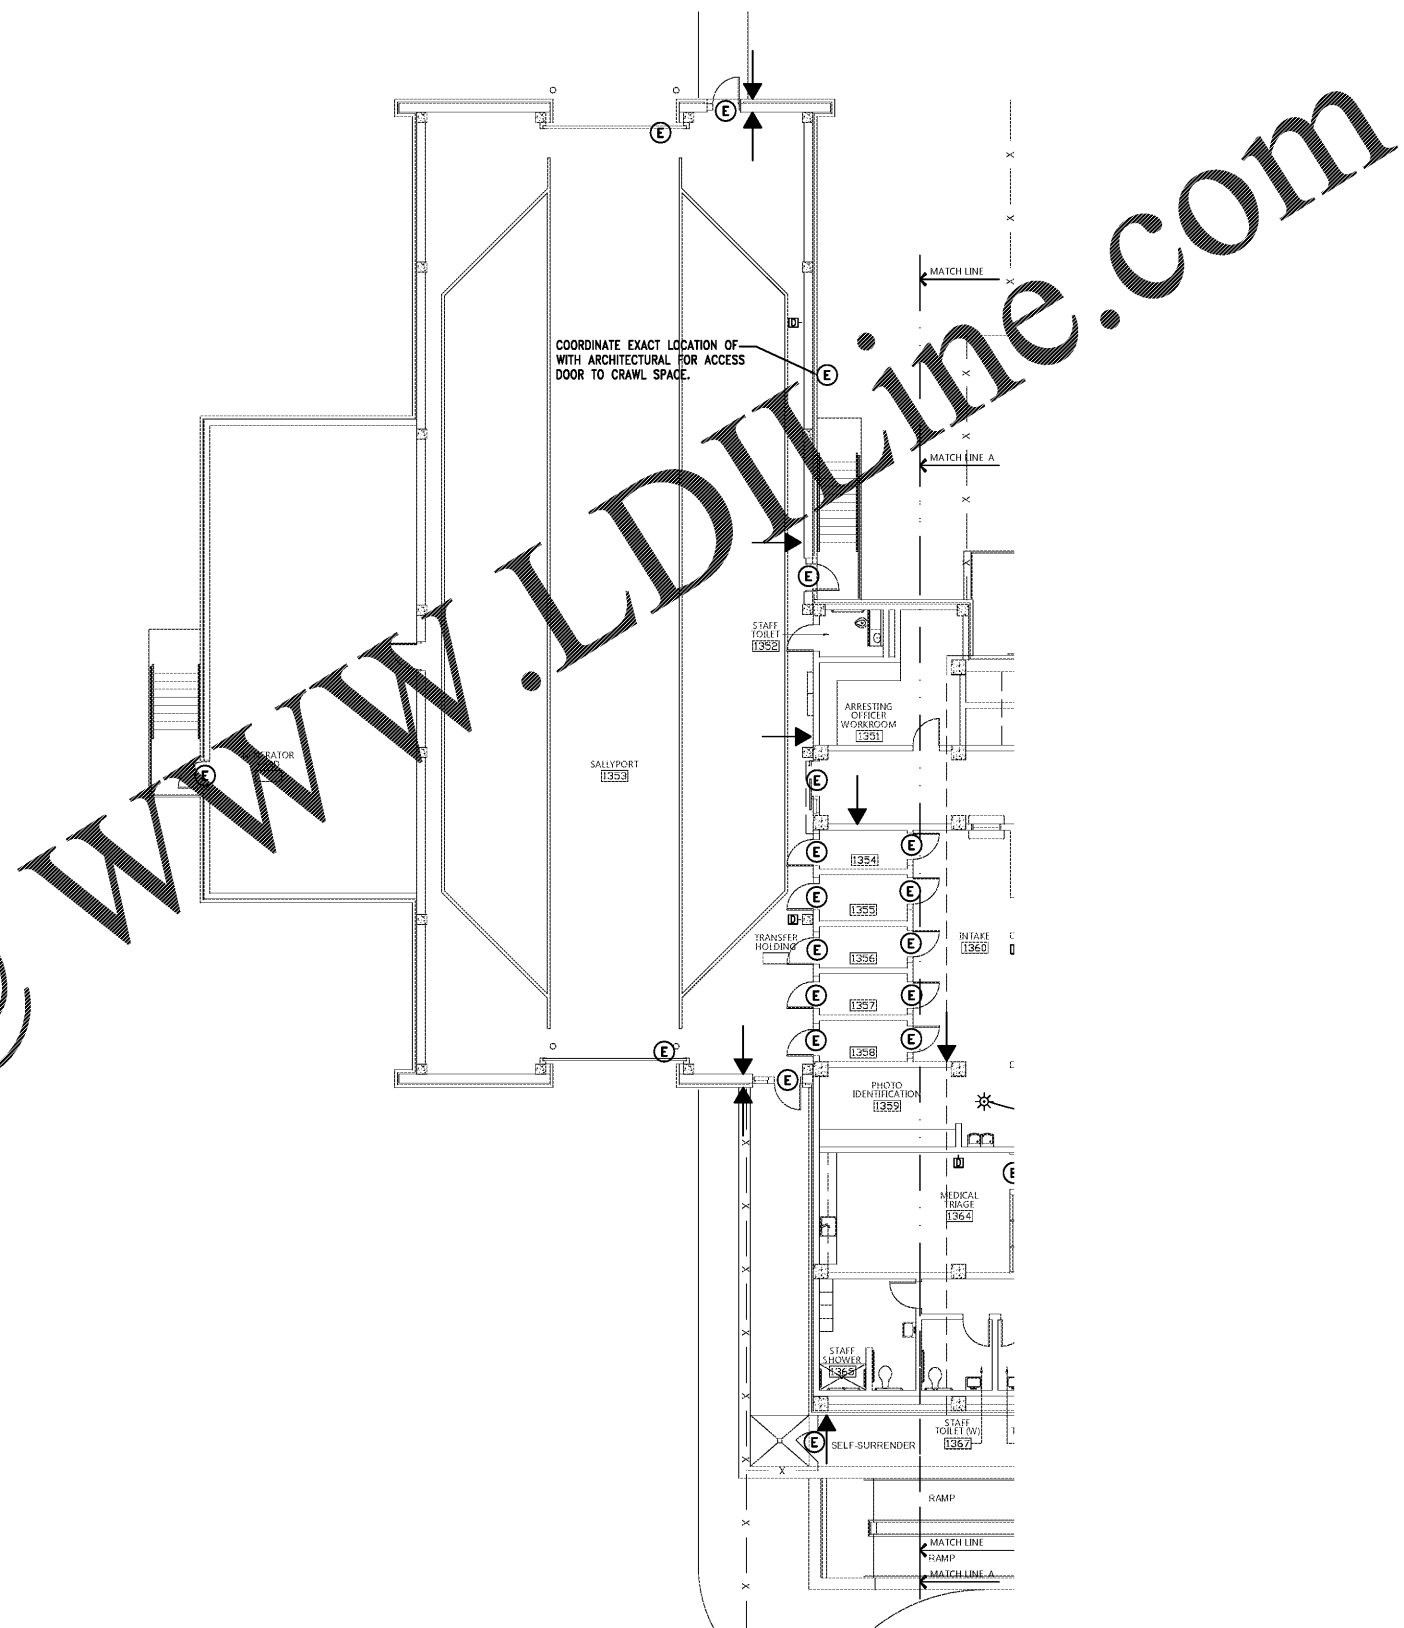

Order Plans @ www.LDILine.com

PH&J architects inc.
 Montgomery, Alabama

CIP-2017-001
 UPGRADES TO THE MOBILE COUNTY METRO JAIL
 For The MOBILE COUNTY COMMISSION
 MOBILE, ALABAMA




DRAWN: J.C.T.	CHECK: K.A.G.
DATE: April 2, 2019 RTA	
REVISED:	
REVISED:	

SHEET TITLE	SALLY PORT - 1ST FLOOR PLAN - BASE BID - SECURITY
JOB NO.	PH&J 1801-GV
SEQUENCE NO.	157 of 175

E5.0

© PH&J ARCHITECTS, INC.
ALL RIGHTS RESERVED

 SALLY PORT
 1ST FLOOR PLAN - BASE BID - SECURITY
 SCALE: 1/8"=1'-0"



GA

Gunn & Associates, P.C.
Consulting Engineers

3102 Highway 14
Montgomery, AL 36104
Tel: 334.285.1273

500 Southland Drive Suite 210
Hoover, AL 35226
GAP18-492