


NOTE:
 ALL CONDUITS/CIRCUITRY SHALL BE
 CONCEALED IN THE CONCRETE SLABS,
 BEHIND WALLS, OR IN CHASES.

 
GENERAL NOTES:

- COORDINATE ALL LOCATIONS AND CONDUIT REQUIREMENTS WITH ARCHITECTURAL SECURITY SHEETS PRIOR TO BIDS. PROVIDE CONDUIT TO ADDITIONAL SECURITY DEVICES SHOWN ON ARCHITECTURAL SECURITY PLANS THAT ARE NOT SHOWN ON THE E-SHEETS.

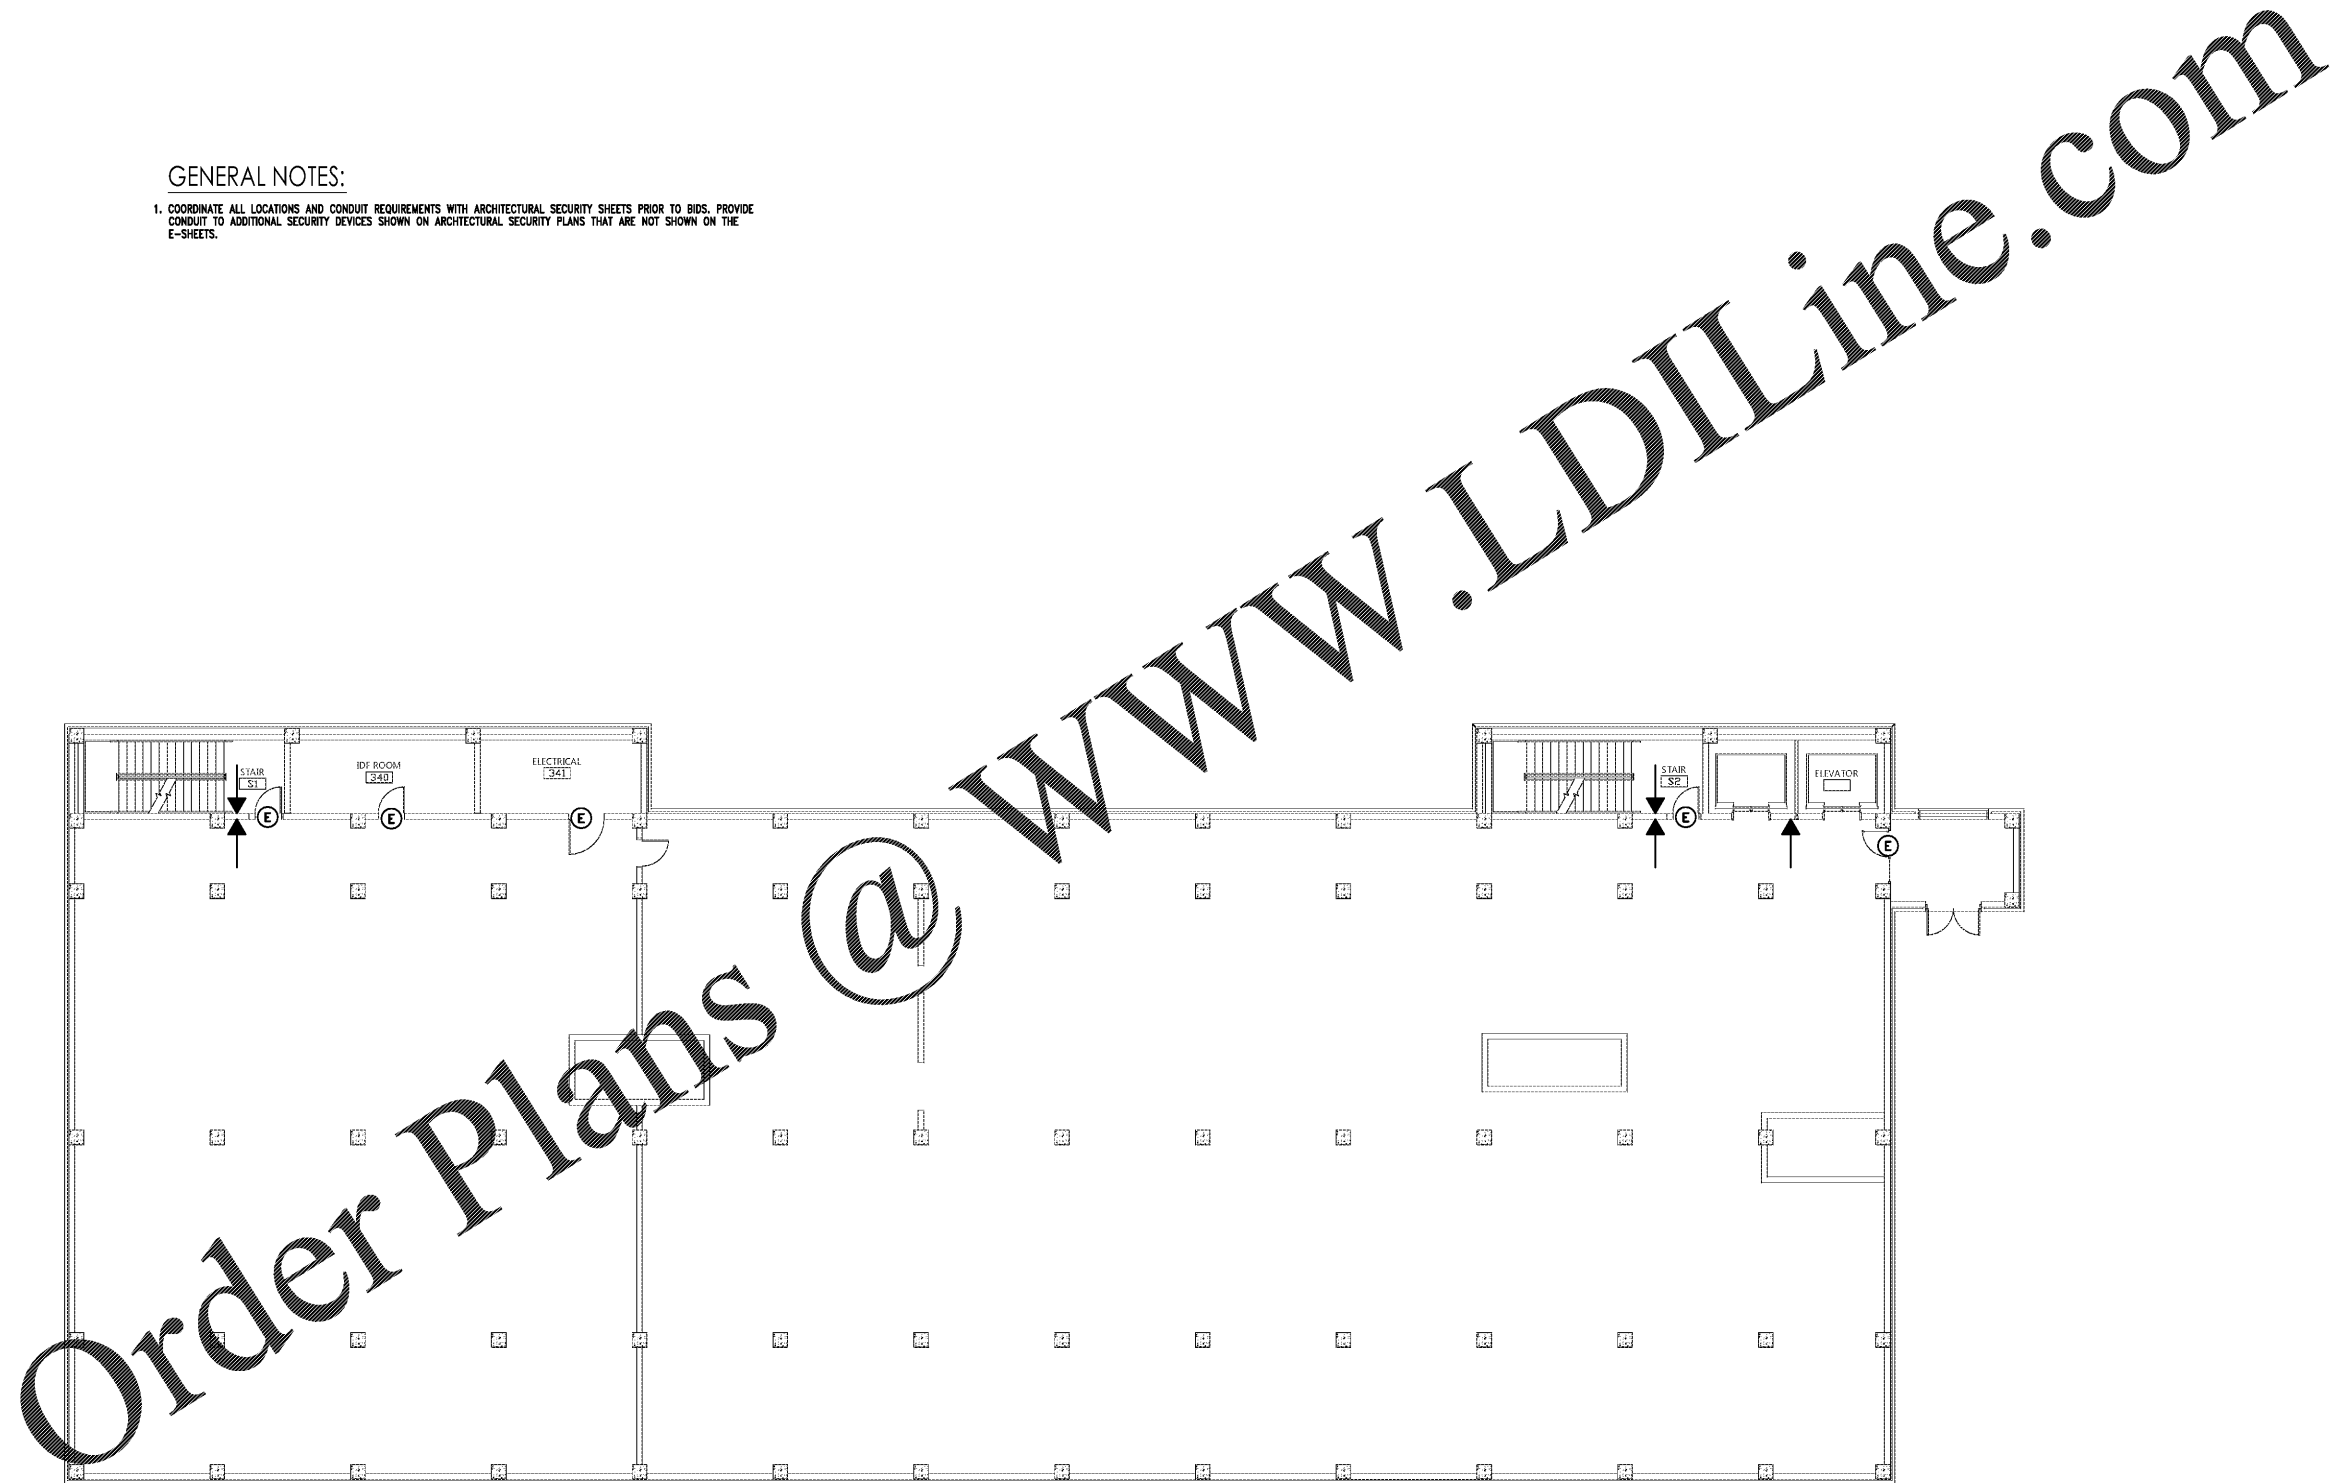

Order Plans @

1 3RD FLOOR PLAN - ALTERNATE - SECURITY
 SCALE: 1/8"=1'-0"



GA Gunn & Associates, P.C.
 Consulting Engineers
 3102 Highway 14
 Millbrook, AL 36054
 500 Southland Drive Suite 250
 Hoover, AL 35226
 Tel: 334.285.1273
 GAP18-192

CIP-2017-001
 UPGRADES TO THE MOBILE COUNTY METRO JAIL
 For The MOBILE COUNTY COMMISSION
 MOBILE, ALABAMA



| DATE | BY | CHECK | DATE |
|---------------|-----|-------|------|
| April 2, 2019 | RTA | | |
| | | | |
| | | | |


SHEET TITLE
 3RD FLOOR PLAN -
 ALTERNATE - SECURITY

JOB NO.
 PH&J 1801-GV

SEQUENCE
 NO. 160 OF 175

E5.3

© PH&J ARCHITECTS, INC.
 ALL RIGHTS RESERVED

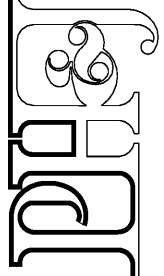

architects inc.
 Montgomery,
 Alabama