



NOTE:
ALL CONDUITS/CIRCUITRY SHALL BE
CONCEALED IN THE CONCRETE SLABS,
BEHIND WALLS, OR IN CHASES.

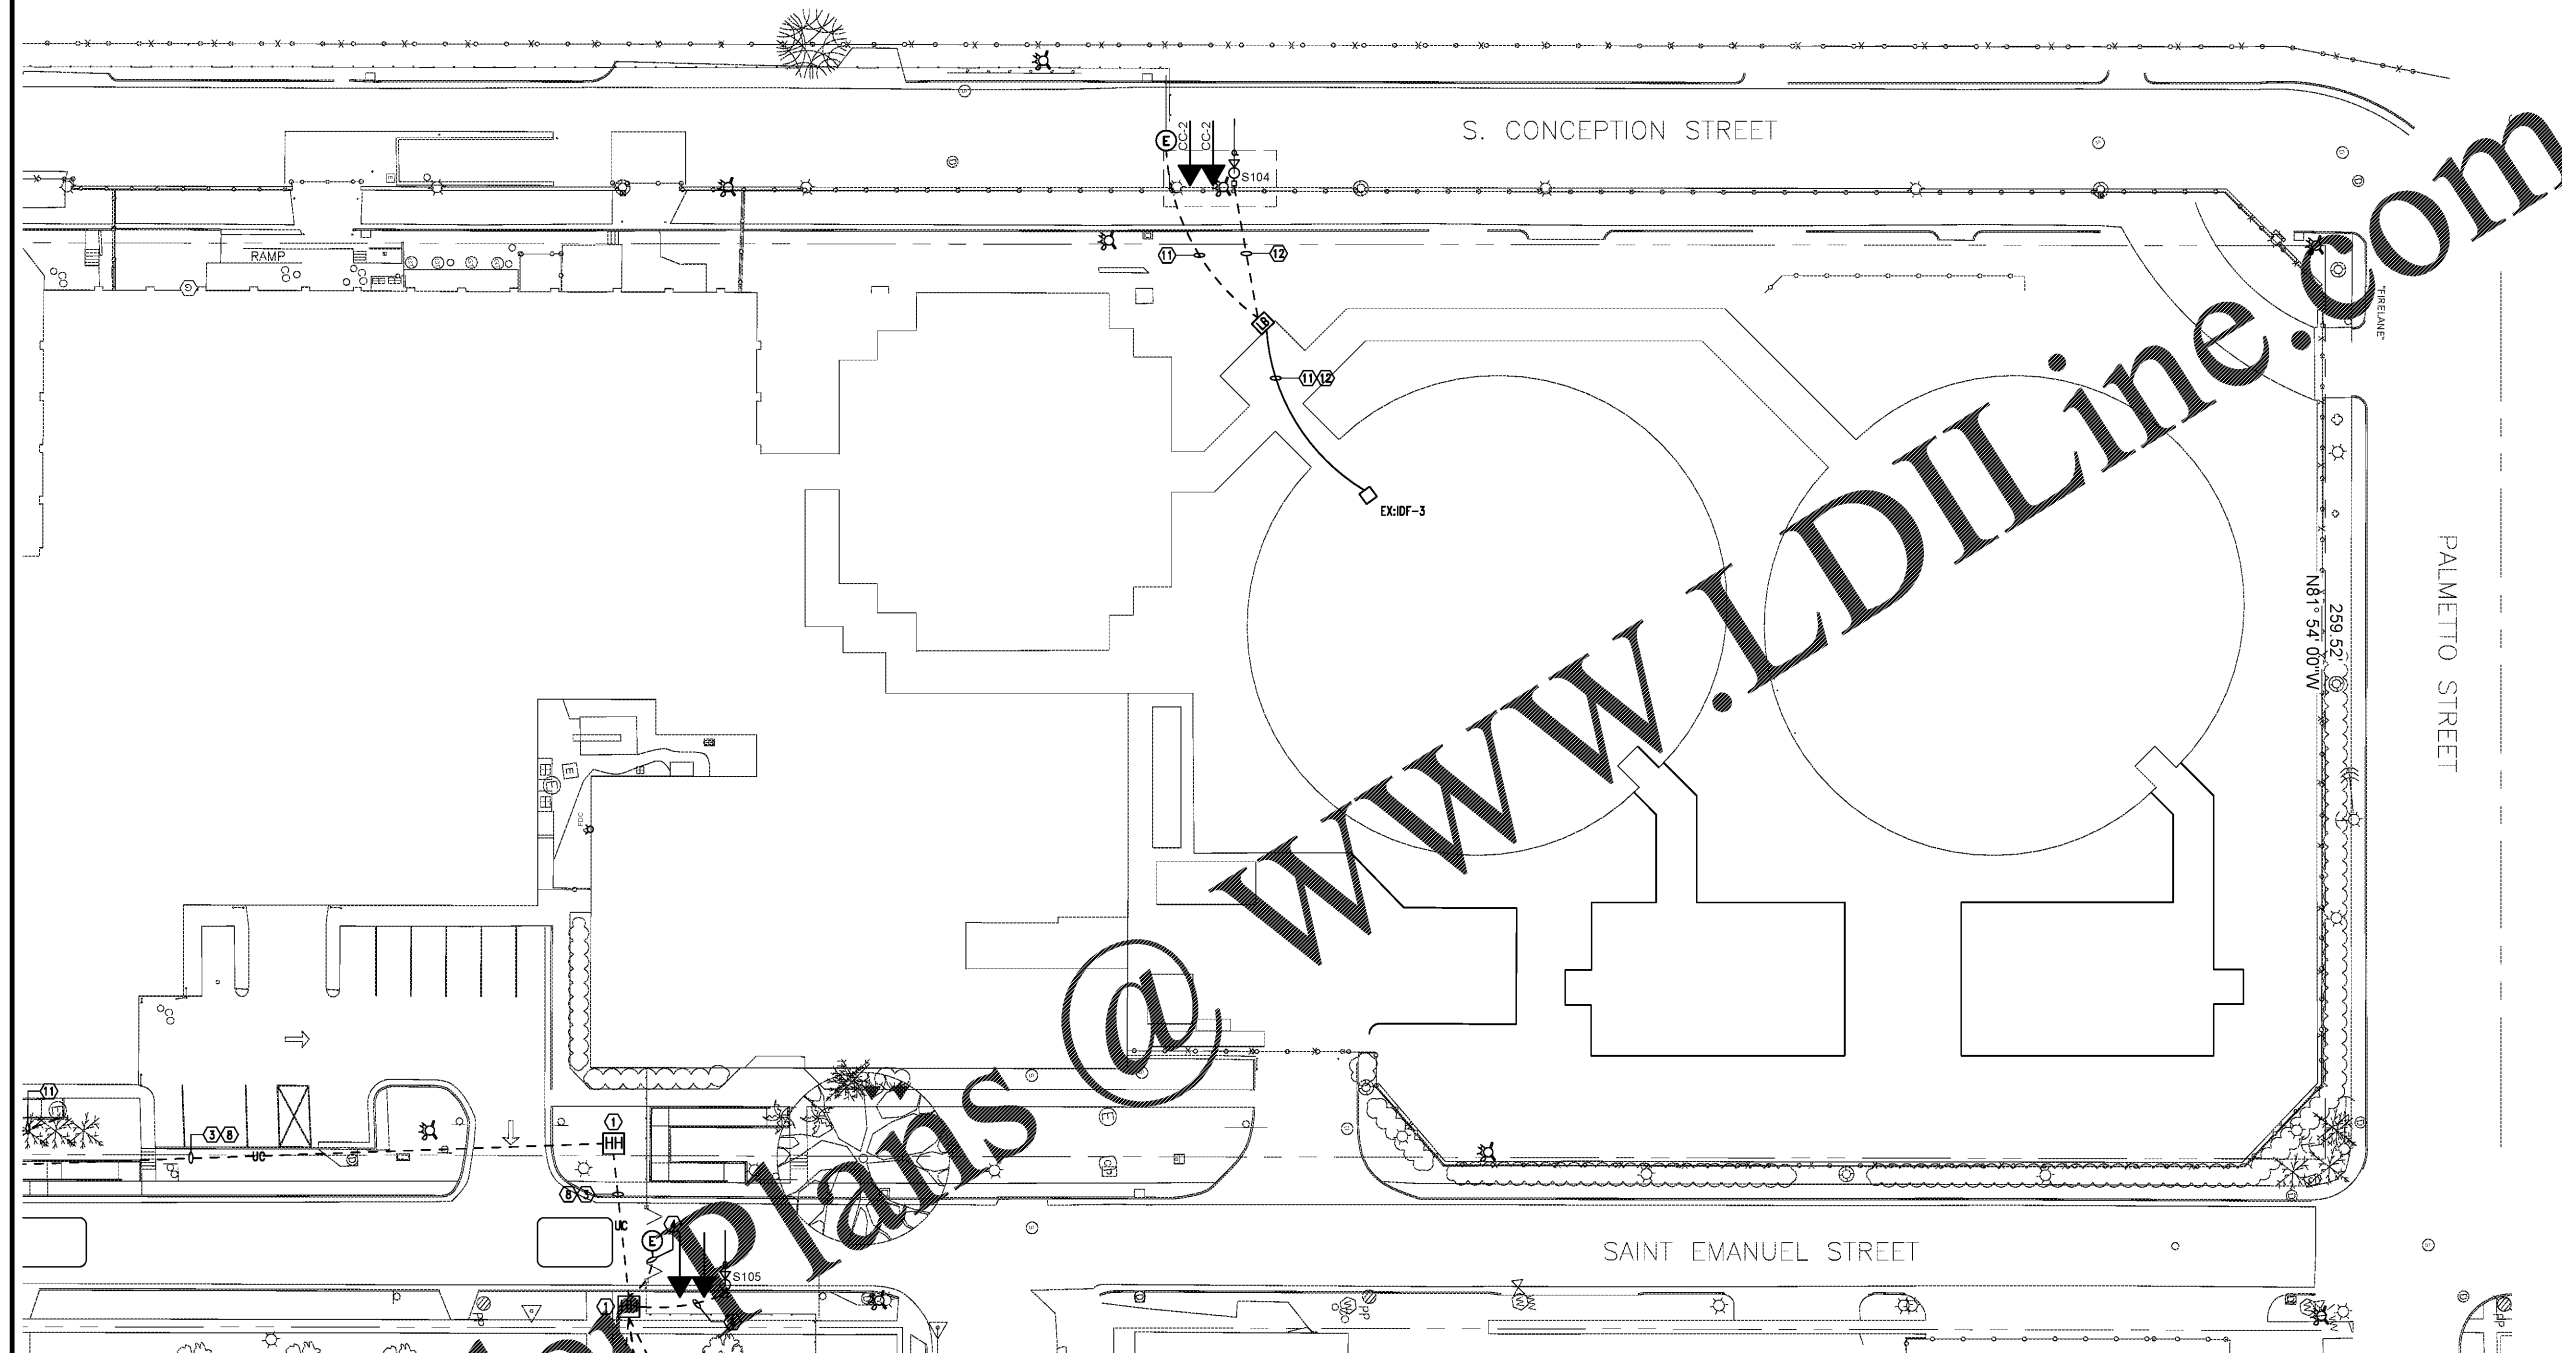

architects inc.
Montgomery, Alabama

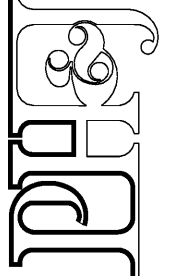

CIP-2017-001
UPGRADES TO THE MOBILE COUNTY METRO JAIL
FOR THE MOBILE COUNTY COMMISSION
MOBILE, ALABAMA

 
1 SITE PLAN PART "B" - SECURITY
SCALE: 1" = 20'-0"

SHEET NOTES:

- ① PROVIDE 30"x24"x18" NEMA 12 TRAFFIC RATED COMPOSITE CONCRETE BOX. PROVIDE 6" BED OF #57 STONE AS FOUNDATION.
- ② PROVIDE TWO (2) 3" CONDUITS FROM THE IDF-6 TO THE NEW HANDHOLE.
- ③ PROVIDE TWO (2) 3" CONDUITS FROM THE NEW HANDHOLE TO NEW HANDHOLE.
- ④ PROVIDE ONE (1) 1" CONDUIT FROM NEW HANDHOLE TO THE ELECTRONIC SECURITY DEVICE.
- ⑤ PROVIDE ONE (1) 1" CONDUIT FROM NEW HANDHOLE TO THE INTERCOM DEVICE.
- ⑥ PROVIDE ONE (1) 1" CONDUIT FROM NEW HANDHOLE TO THE PEDESTAL FOR INTERCOM DEVICE AND CAMERA.
- ⑦ PROVIDE ONE (1) 1" CONDUIT FROM NEW HANDHOLE TO THE NEW LIGHT POLE.
- ⑧ CONTRACTOR SHALL BORE CONDUIT WITH HDPE TYPE CONDUIT.
- ⑨ PROVIDE ONE (1) 1" CONDUIT FROM NEW HANDHOLE TO THE NEW CAMERA POLE.
- ⑩ CONTRACTOR SHALL PROVIDE NEW 32' OCTAGONAL TENON DIRECT BURIED CONCRETE POLE WITH CAMERA MOUNTS TO MOUNT NEW CAMERAS. SEE DETAIL 2 SHEET E5.4 FOR REQUIREMENTS. POLE SHALL BE MANUFACTURED BY BALDWIN LIGHTING OR APPROVED EQUALS. THESE POLES ARE IN ADDITION TO THE CONCRETE POLES THAT SHOULD BE PROVIDED FOR THE SITE LIGHTING.
- ⑪ PROVIDE ONE (1) 1" CONDUIT FROM EX:IDF TO THE ELECTRONIC SECURITY DEVICE. CONDUIT MUST BE CONCEALED INSIDE BUILDING ABOVE CEILINGS TO THE MEZZANINE. VISIT SITE PRIOR TO BIDS TO CONFIRM ROUTE.
- ⑫ PROVIDE ONE (1) 1" CONDUIT FROM EX:IDF TO THE PEDESTAL FOR INTERCOM DEVICE AND CAMERA. CONDUIT MUST BE CONCEALED INSIDE BUILDING ABOVE CEILINGS TO THE MEZZANINE. VISIT SITE PRIOR TO BIDS TO CONFIRM ROUTE.

GENERAL NOTES:

1. COORDINATE EXACT ROUGH-IN LOCATIONS WITH SECURITY CONTRACTOR PRIOR TO INSTALLATION.
2. COORDINATE ALL LOCATIONS AND CONDUIT REQUIREMENTS WITH ARCHITECTURAL SECURITY SHEETS PRIOR TO BIDS. PROVIDE CONDUIT TO ADDITIONAL SECURITY DEVICES SHOWN ON ARCHITECTURAL SECURITY PLANS THAT ARE NOT SHOWN ON THE E-SHEETS.



Gunn & Associates, P.C.
Consulting Engineers
3102 Highway 14
Millbrook, AL 36054
500 Southland Drive Suite 250
Hoover, AL 35226
Tel: 334.285.1273
GAP18-192



DRAWN	J.C.T.	CHECK	K.A.S.
DATE	April 2, 2019 RTA		
REVISED			
REVISED			

SHEET TITLE
SITE PLAN PART "B" -
SECURITY
JOB NO.
PH&J 1801-GV
REFERENCE
NO. 162 OF 175

E5.5
© PH&J ARCHITECTS, INC.
ALL RIGHTS RESERVED

2 SITE PLAN PART "C" - SECURITY
SCALE: 1" = 20'-0"